
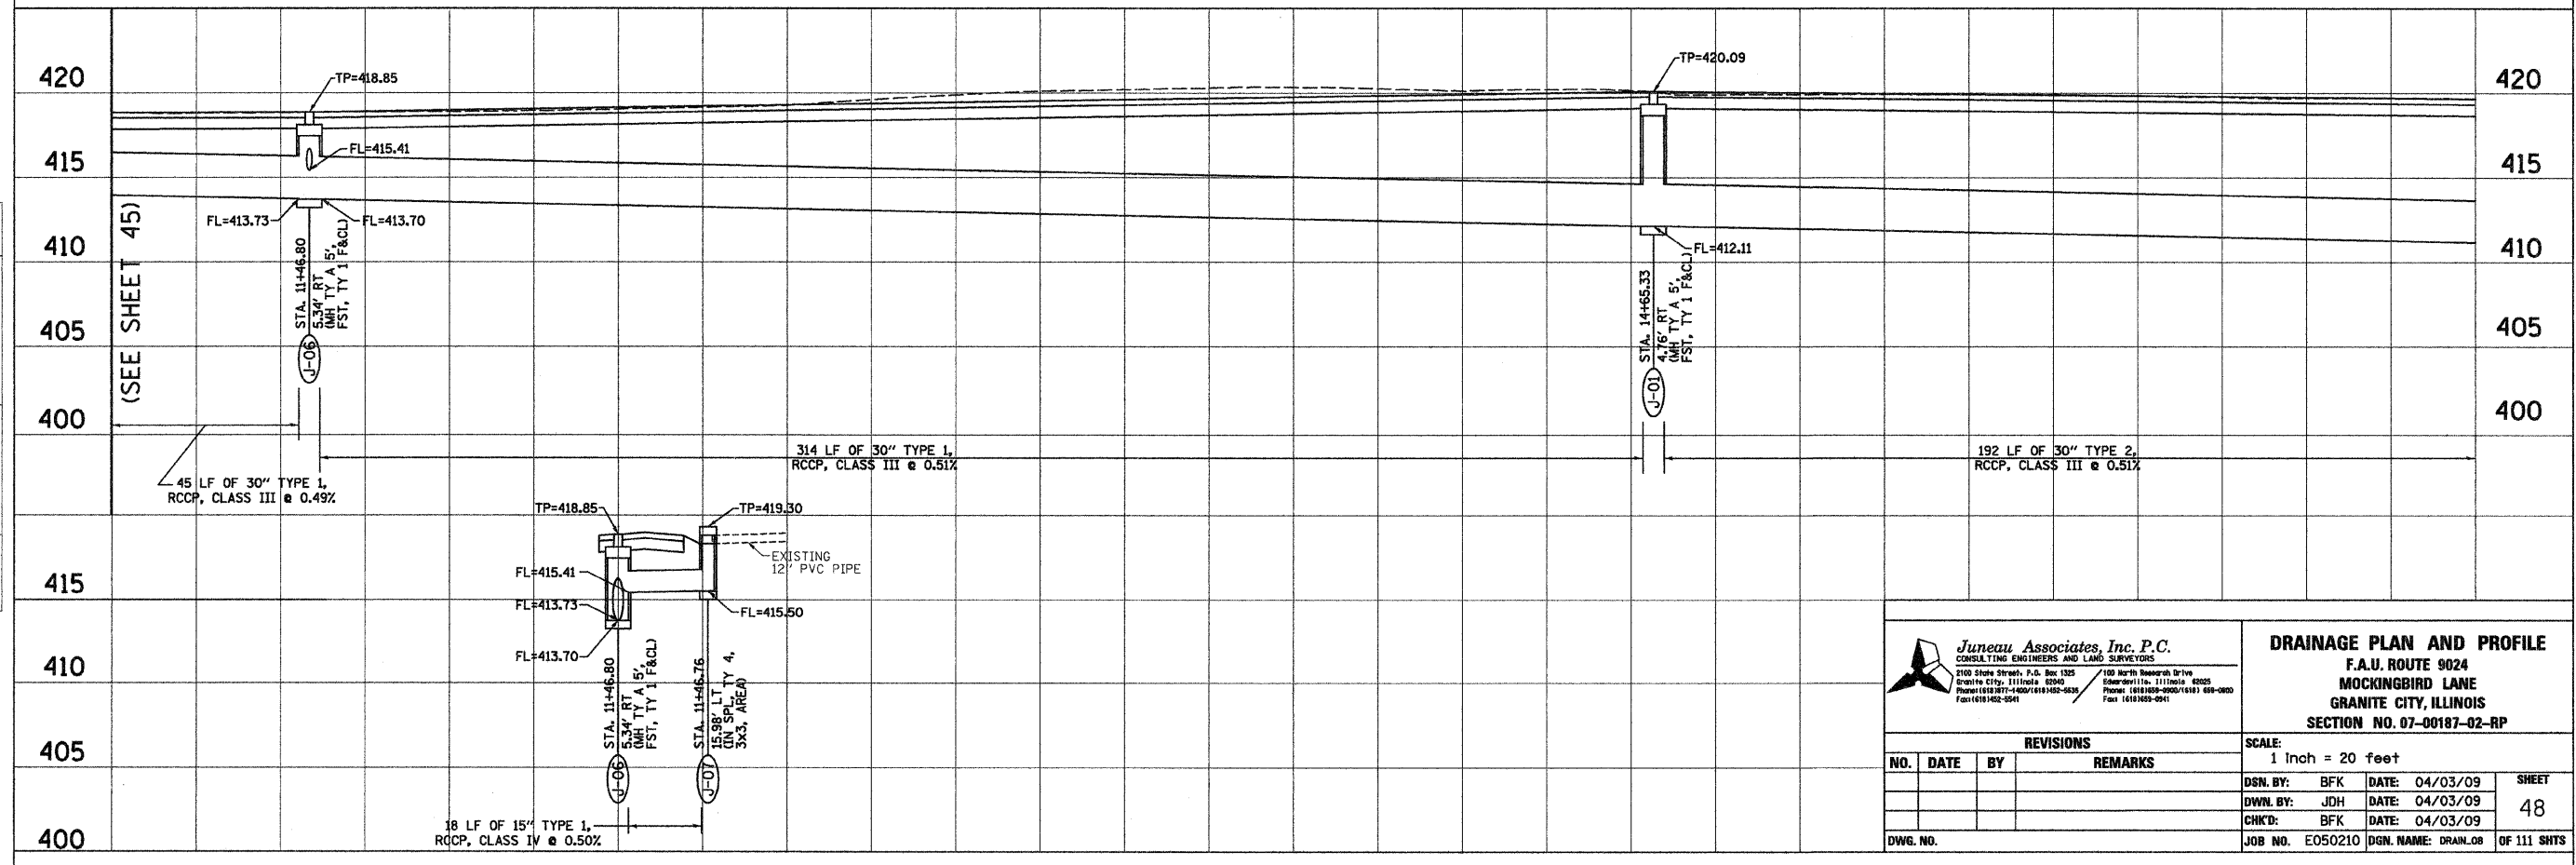


F.A.U. RTE.	SECTION	COUNTY	TOTAL SHEETS	SHEET NO.
9024	07-00187-02-RP	MADISON	111	48
FED. ROAD DIST. NO.	ILLINOIS	FED. AID PROJECT		
CONTRACT NO. 07370				

BY	DATE
SURVEYED	
PLOTTED	
NOTE BOOK	
TEMPLATE	
AREAS	
CHECKED	
NO.	

BY	DATE
ORIGINAL SURVEYED	
PLOTTED	
NOTE BOOK	
TEMPLATE	
AREAS	
CHECKED	
NO.	

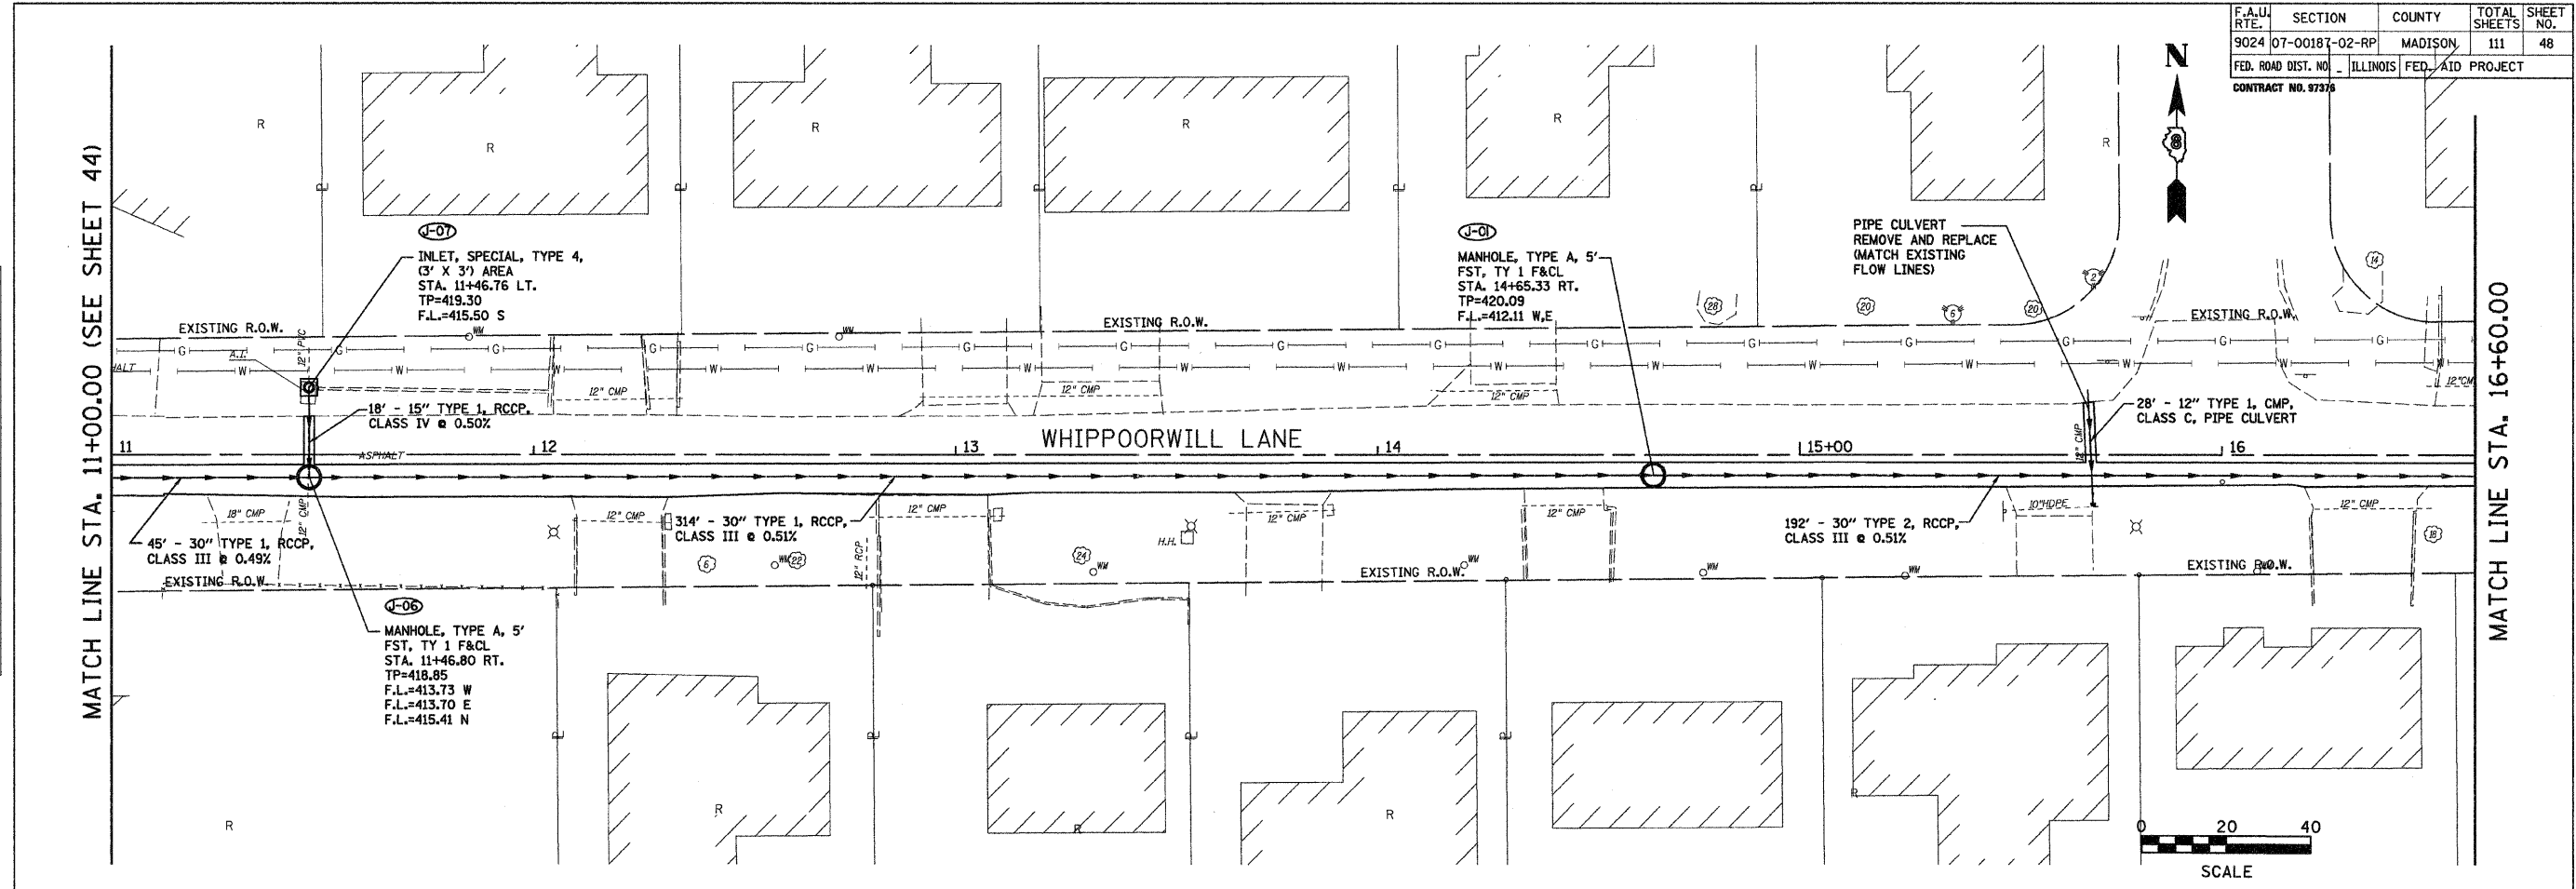

Juneau Associates, Inc. P.C.
CONSULTING ENGINEERS AND LAND SURVEYORS
2102 Stone Street, P.O. Box 1322
Granite City, Illinois 62040
Phone: (618) 271-4600 / (618) 482-9838
Fax: (618) 482-2641

100 North Research Drive
Edwardsville, Illinois 62025
Phone: (618) 698-9900 / (618) 699-9900
Fax: (618) 698-0941

DRAINAGE PLAN AND PROFILE
F.A.U. ROUTE 9024
MOCKINGBIRD LANE
GRANITE CITY, ILLINOIS
SECTION NO. 07-00187-02-RP

REVISIONS				SCALE:	
NO.	DATE	BY	REMARKS	1 Inch = 20 feet	
				DSN. BY:	BFK DATE: 04/03/09 SHEET
				DWN. BY:	JDH DATE: 04/03/09 48
				CHK'D:	BFK DATE: 04/03/09
DWG. NO.				JOB NO. E050210	DGN. NAME: DRAIN_08 OF 111 SHTS