


K:\Pinckneyville\0706203 SITE WORK HGR\Draw\Site
 FILE: UNDERDRAIN AND FENCING PLAN.c
 UPDATE BY: Dale Draughan
 PLOT DATE: 4/17/2009 1:29 PM
 PROP-GEO
 BASE_PROPDRAIN
 BASE_EXISTOPO
 ALP1A
 TOP01A
 ALP3A


 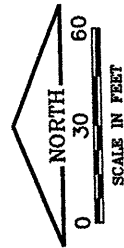


LEGEND

- SS — EXISTING STORM SEWER
- EXISTING INLET
- NEW INLET
- ▽ EXISTING F.E.S.
- - - EXISTING DITCHLINE

REVISIONS

NUMBER	BY	DATE

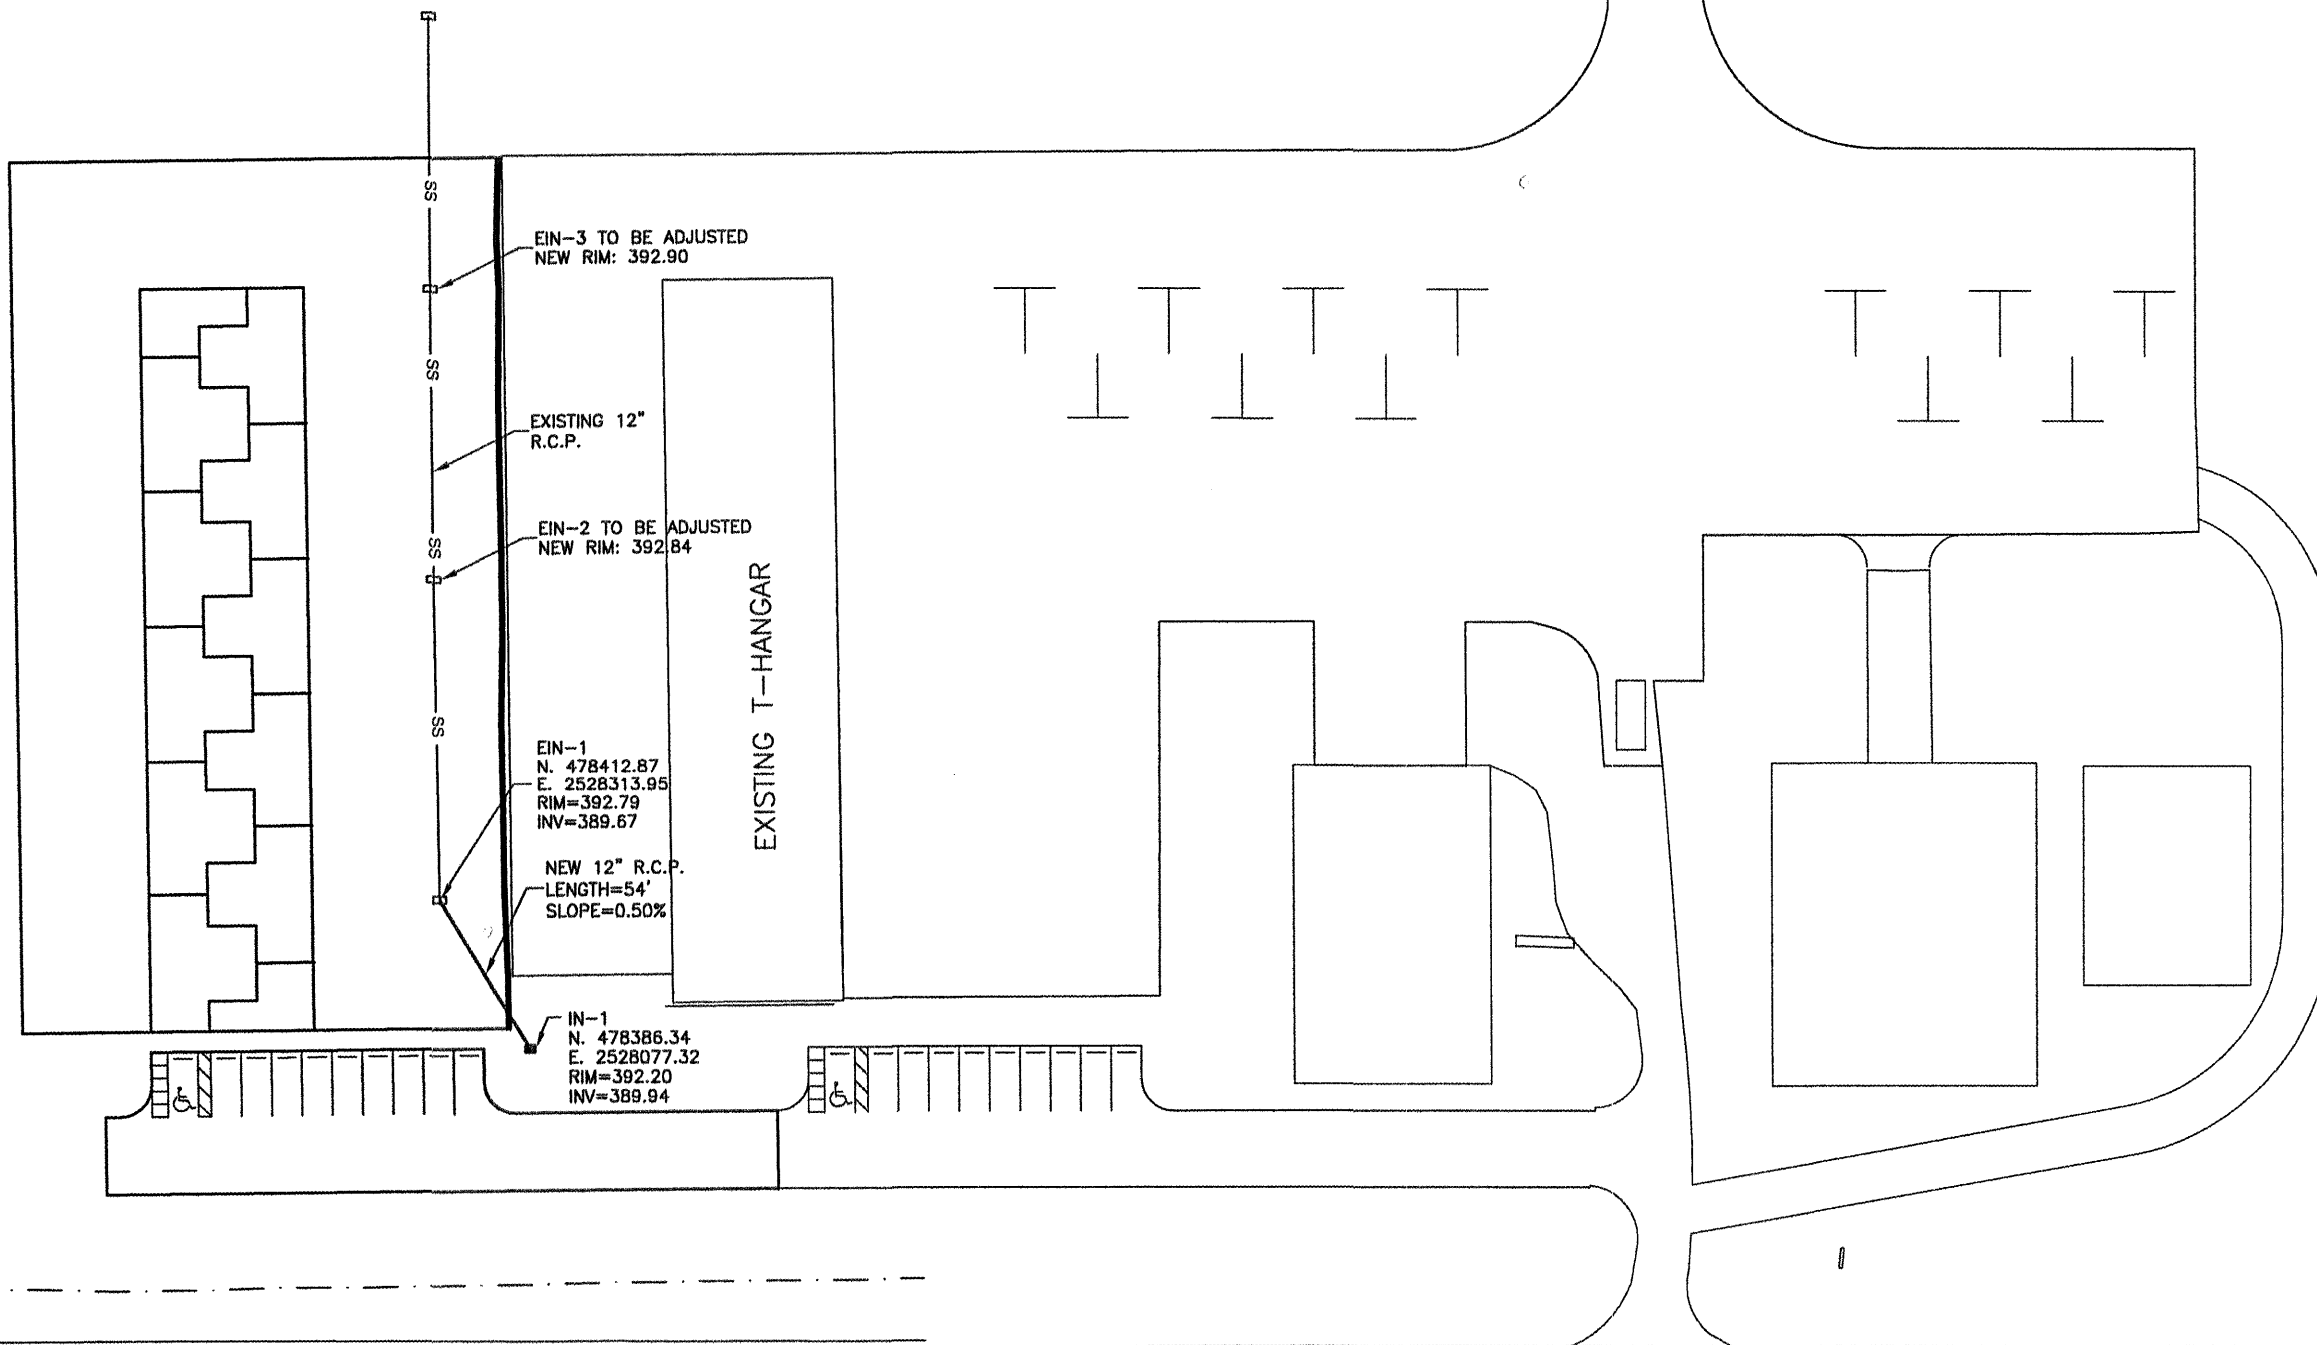

PINCKNEYVILLE-DUQUOIN AIRPORT
 PERRY COUNTY, ILLINOIS
 T-HANGAR SITE WORK
 DRAINAGE PLAN

© Copyright CMT, Inc.

CMT
 CRAWFORD, MURPHY & TILLY, INC.
 CONSULTING ENGINEERS
 License No. 184-000613

DESIGN BY:	TJH
DRAWN BY:	CMT
CHECKED BY:	JEF
APPROVED BY:	JEF
DATE:	4/17/2009
JOB No:	07062-03-00
IL PROJECT NO.	PJY-3373
A.I.P. PROJECT NO.	3-17-0037-B6
SHEET	09 OF 17 SHEETS