


F.A. RTE.	SECTION	COUNTY	TOTAL SHEETS	SHEET NO.
*	*	*	608	322
STA. TO STA.		FED. AID PROJECT		
ILLINOIS		*26HB-1BR & 114R-1		

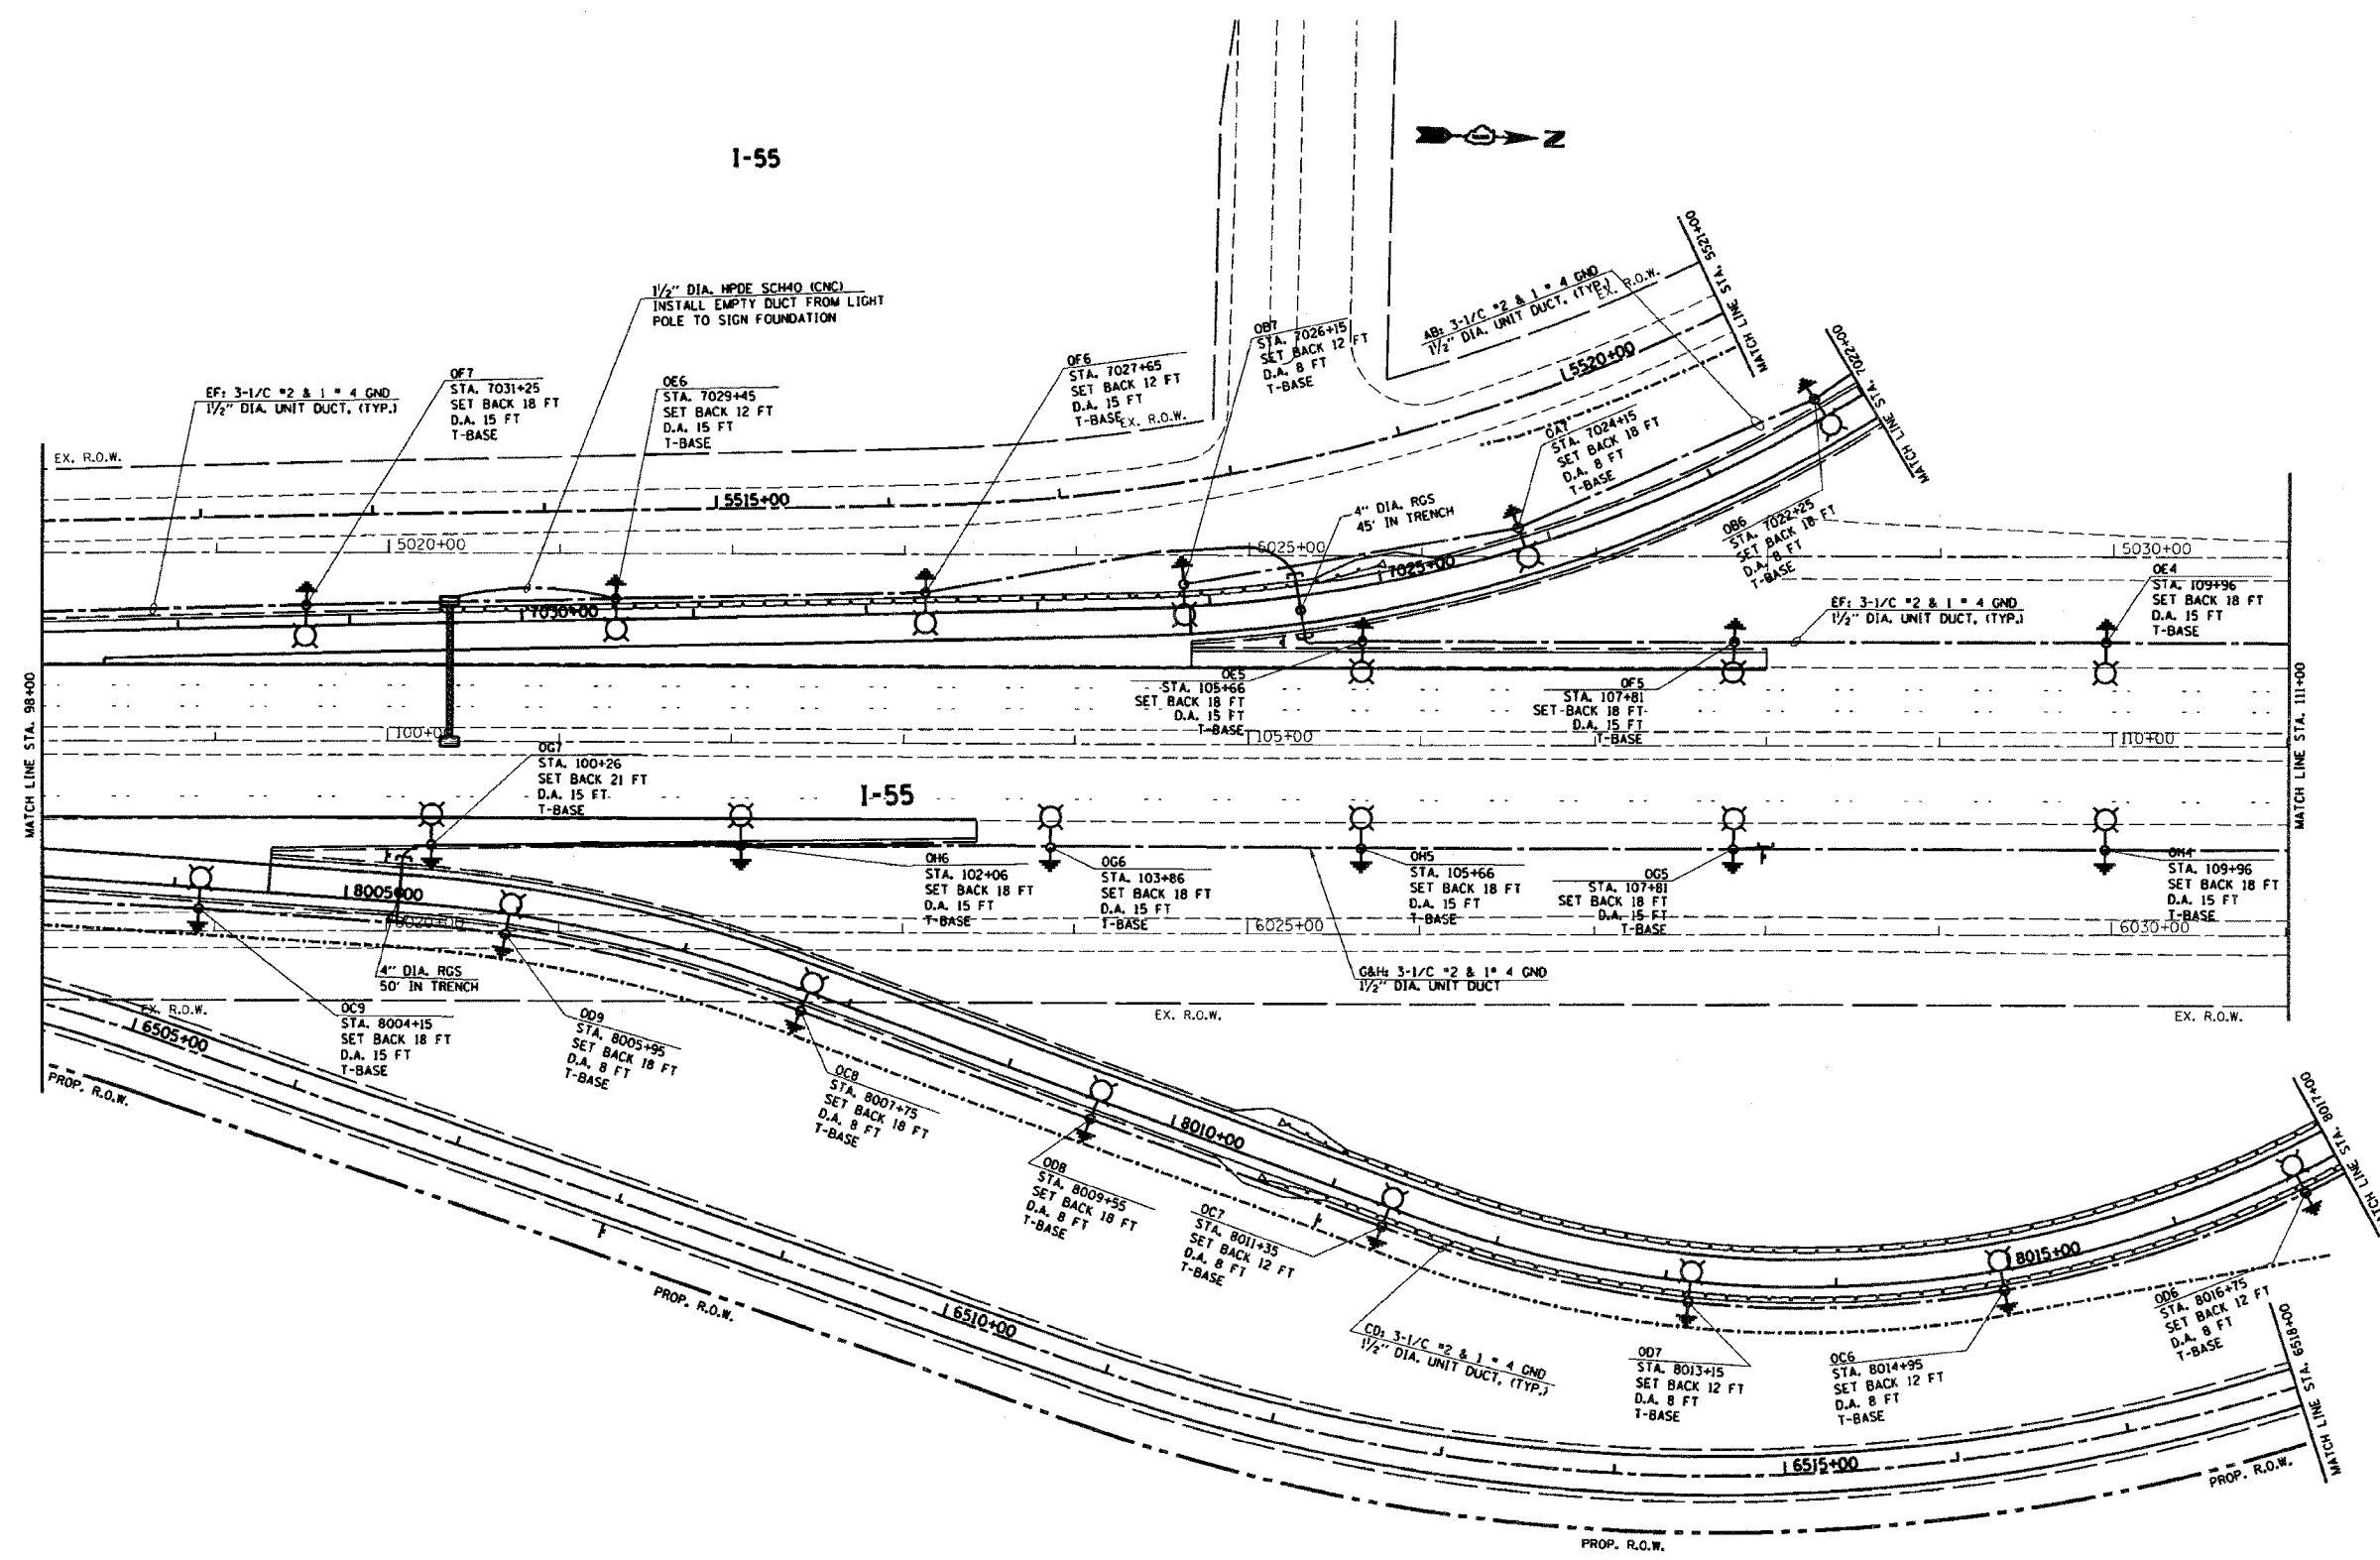

REVISIONS	
NAME	DATE

ILLINOIS DEPARTMENT OF TRANSPORTATION  
**I-55 AT IL. ROUTE 59**  
**IDOT LIGHTING PLAN**

SCALE: VERT. 1"=50'  
 HORIZ. DATE 3/13/2008

DRAWN BY T.G.  
 CHECKED BY