
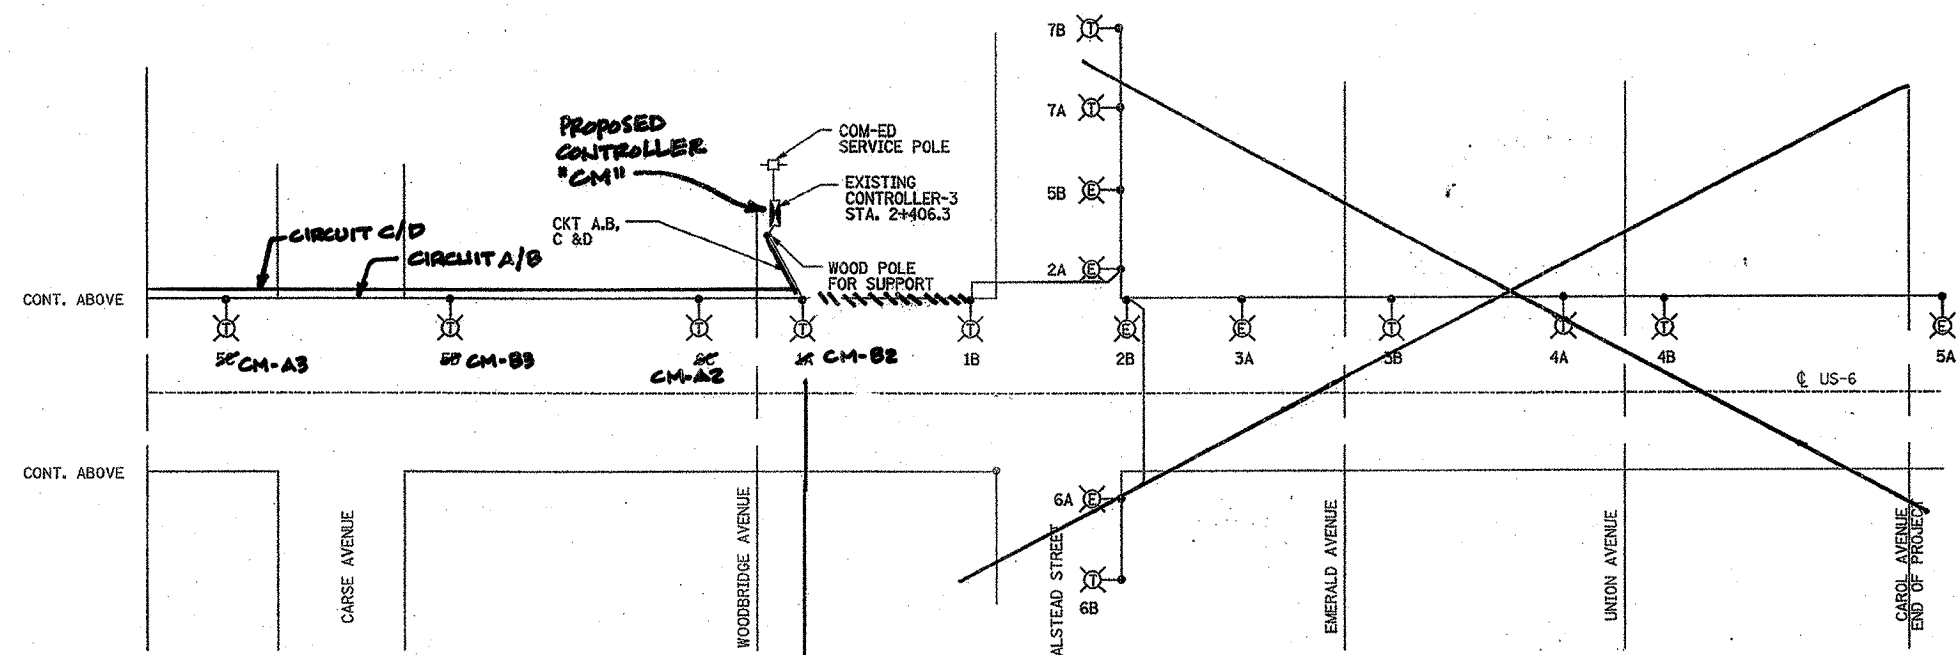


F.A. RTE.	SECTION	COUNTY	TOTAL SHEETS NO.
351	2008-001VB	COOK	519 102
STA.	TO STA.		
FED. ROAD DIST. NO.	ILLINOIS FED. AID PROJECT		

60E10

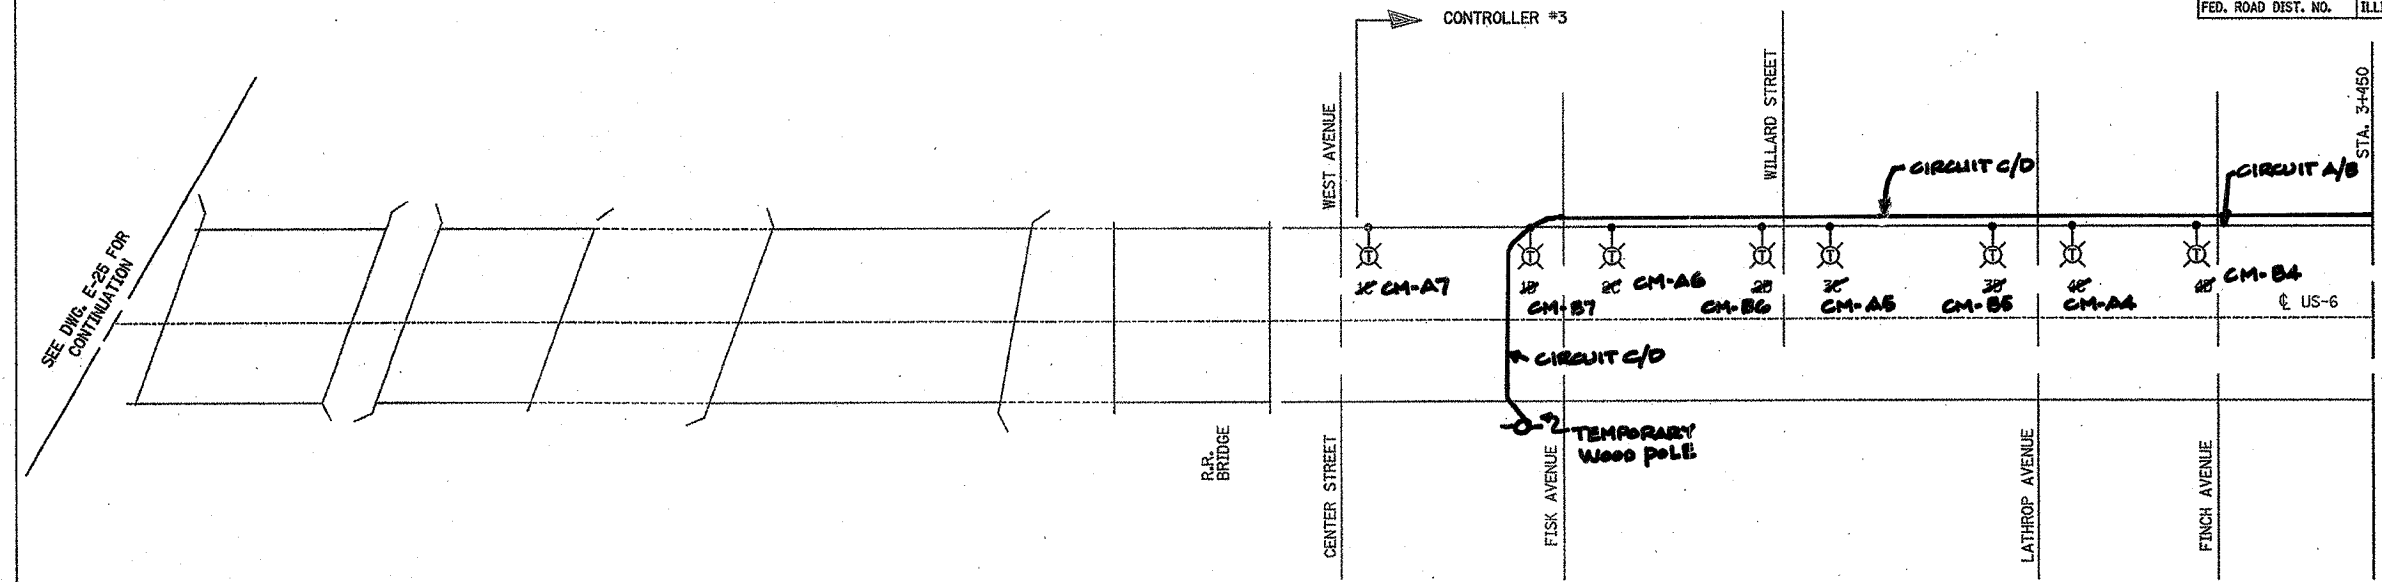

LOAD TABLE

CONTROLLER 3		
CIRCUIT NO.	LOAD	CURRENT
A	2410W	10.75A
B	3105W	9.89A
C	2500W	10.04A
D	2375W	12.43A

END PROPOSED LIGHTING IMPROVEMENTS CONTRACT 60E10

PROPOSED IMPROVEMENTS IN CONTRACT 60T74

- LEGEND:
- ⊙ LIGHT POLE, WOOD, WITH 14.5M MAST ARM
 - ⊙ EXISTING LIGHT POLE
 - ⊞ EXISTING LIGHTING CONTROLLER
 - ⊞ ComEd SERVICE POLE
 - LIGHT POLE, WOOD, FOR SUPPORT

REVISIONS	
NAME	DATE
URS CORP	2/15/08

DRAWING No. E-28

ILLINOIS DEPARTMENT OF TRANSPORTATION

US RTE 6 FROM I-294 TO IL RTE 1

SINGLE LINE DIAGRAM
TEMPORARY LIGHTING
SHEET '2' OF '2'

DRAWN BY S.S./W.S.
CHECKED BY C.K./H.S.

DATE 12/12/07

Delta Engineering, Inc.
CONSULTING ENGINEERS, CHICAGO, ILLINOIS.