


F.A.I. RTE.	SECTION	COUNTY	TOTAL SHEETS	SHEET NO.
345	BR-IN-1	COOK	196	110
STA. 86+00		TO STA. 92+66.9		
FED. ROAD DIST. NO.	ILLINOIS	FED. AID PROJECT		

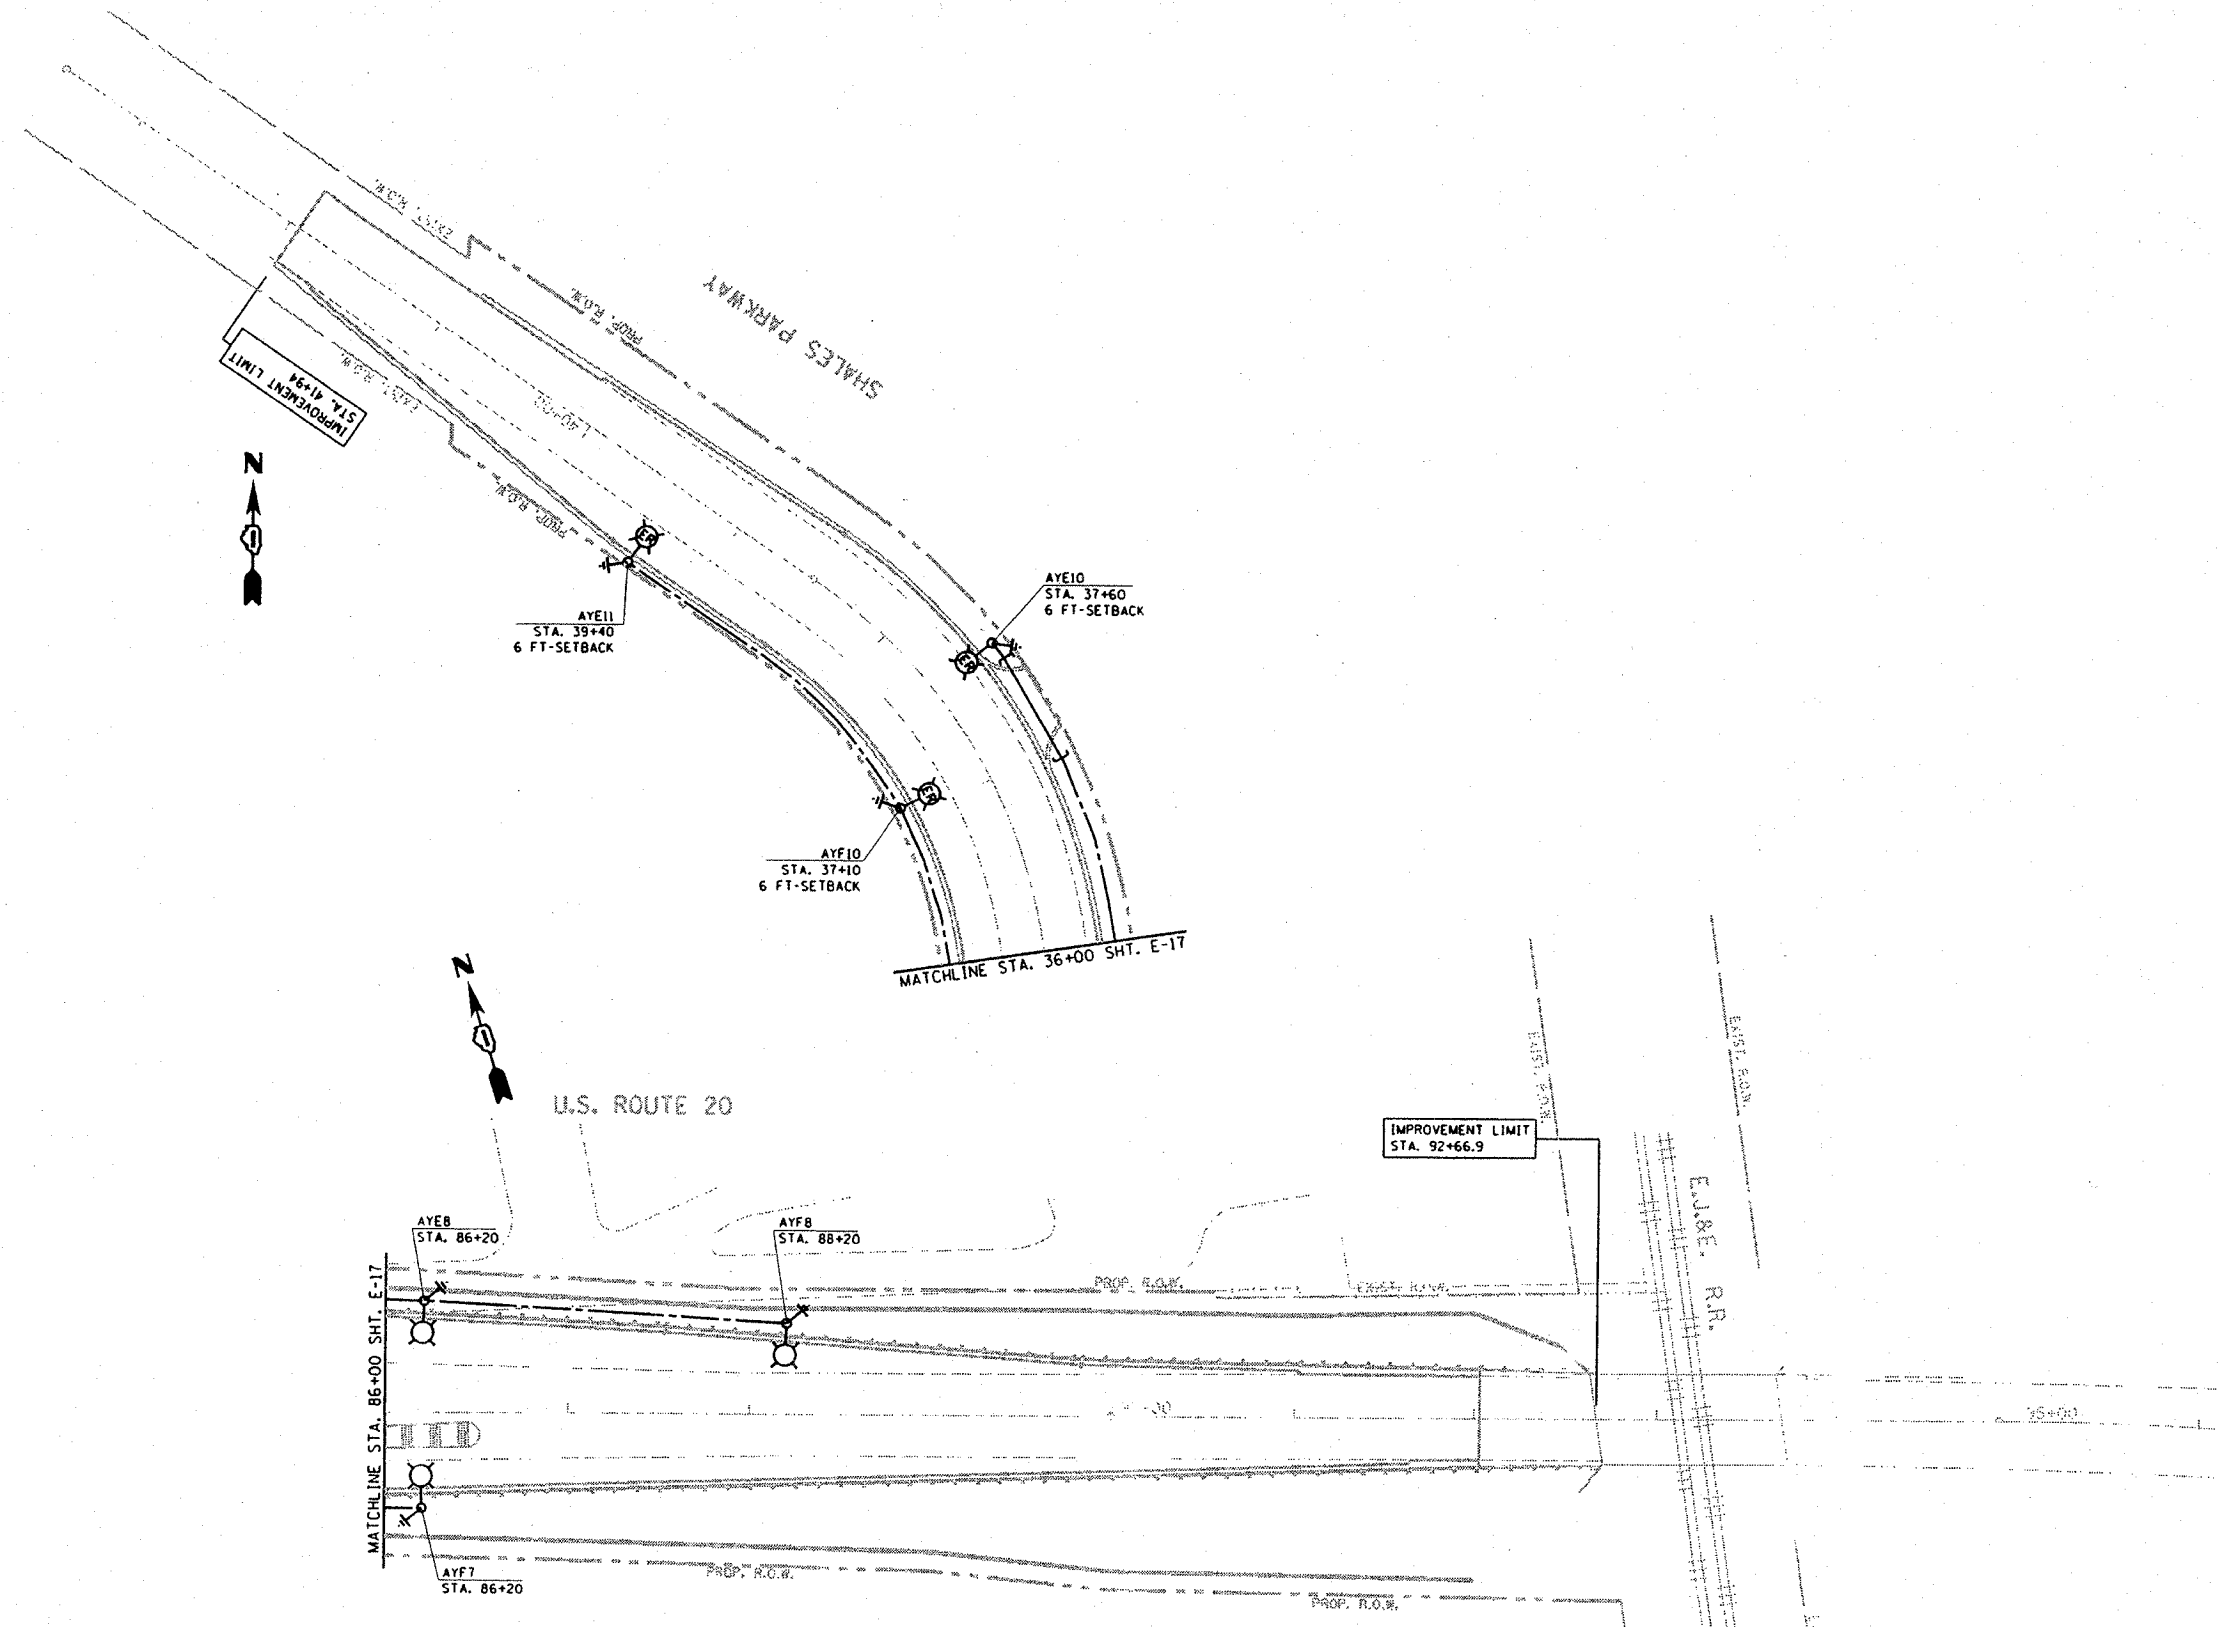

REVISIONS	
NAME	DATE

ILLINOIS DEPARTMENT OF TRANSPORTATION
PROPOSED LIGHTING PLAN 3
U.S. ROUTE 20
SHALES PARKWAY

SCALE: VERT. 1"=50'
 HORIZ. DATE 2/4/2008

DRAWN BY AC
 CHECKED BY MEA/MJ

PLOT DATE : 2/4/2008
 PLOT SCALE : 1"=50'
 USER NAME : paglanob