


F.A.P. RTE.	SECTION	COUNTY	TOTAL SHEETS	SHEET NO.
324	(7) DM	DEKALB	24	19
STA.		TO STA.		
FED. ROAD DIST. NO. 3 ILLINOIS FED. AID PROJECT				

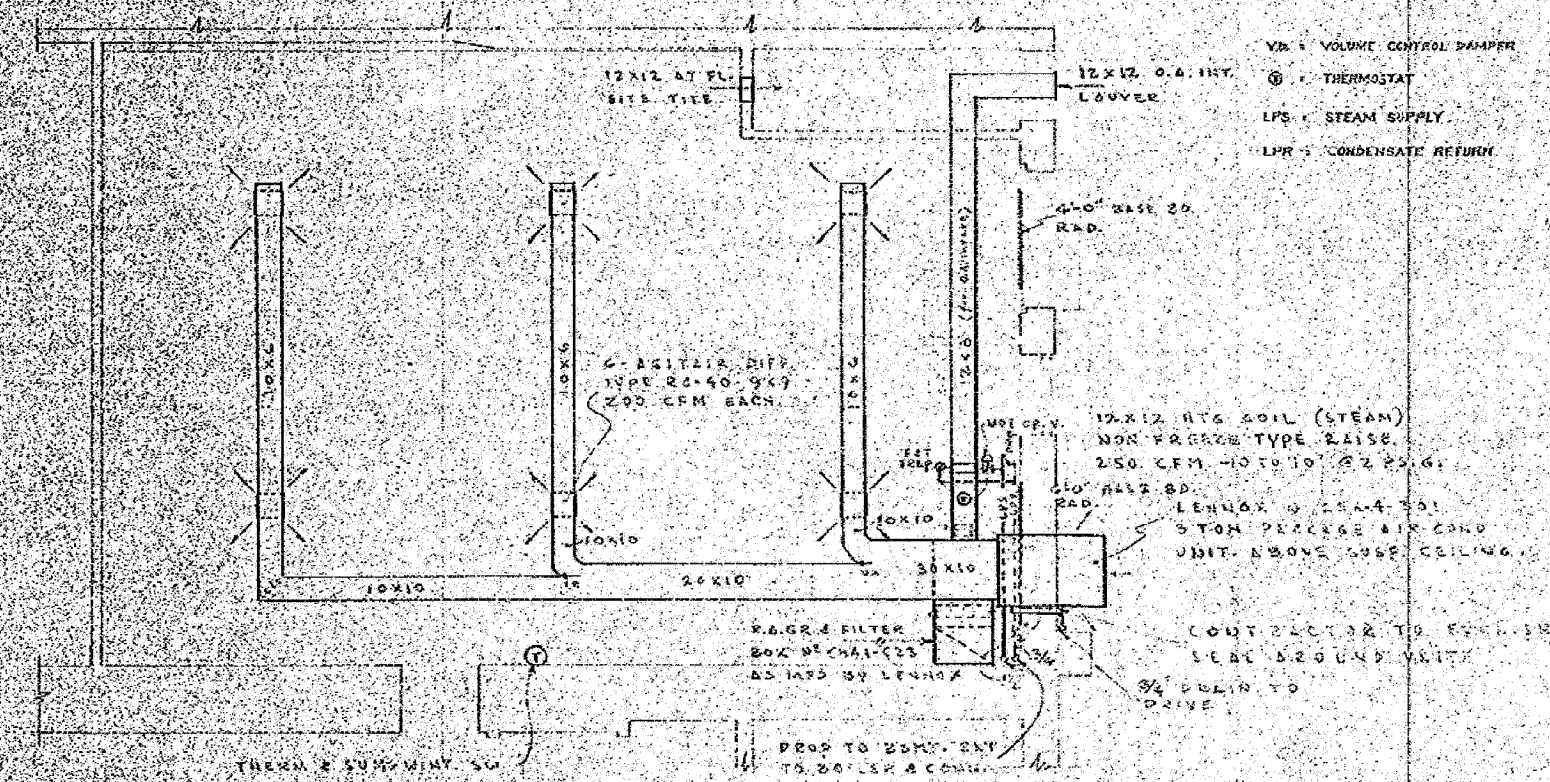

FIRST FLOOR PLAN  
SCALE 1/4" = 1'-0"

V.D. = VOLUME CONTROL DAMPER  
T = THERMOSTAT  
L.P.S. = STEAM SUPPLY  
L.P.R. = CONDENSATE RETURN

CONTRACTOR TO REMOVE EXIST. CONTROL ON EXIST. BOILER AND INSTALL CONSTANT PRESSURE CONTROL.  
DUCT STAT FOR O.A. COIL CONT. TO BE SET @ 70°  
O.A. & R.A. DAMPERS TO BE CONTROLLED BY CEILING QUADRANT CONTROL REGUL.  
PROVIDE HAND VALVE ON BOTH SEC. OF RADIATION. PIPING TO COME FROM BSMT. EXTEND TO BOILER & CONNECT.



REVISION	ADDITIONS AND ALTERATIONS TO THE	JOB	5831-A	SHEET	M-6
	DE KALB TRUST AND SAVINGS BANK	SCALE	AS NOTED	DRAWN BY: FEM	
	DE KALB ILLINOIS	DATE	3-23-59		
	WALTER E FOSS-BANK DESIGNERS				
	2-3 SOUTH CLARK STREET				
	CHICAGO 3 ILLINOIS				
		DRAWING 59016			

REVISIONS	
NAME	DATE

ILLINOIS DEPARTMENT OF TRANSPORTATION  
EXISTING PLAN  
FAP 324 (IL 23)  
SECTION (7) DM  
DEKALB COUNTY  
SCALE: VERT. \_\_\_\_\_  
HORIZ. \_\_\_\_\_  
DATE \_\_\_\_\_  
DRAWN BY A.R.R.  
CHECKED BY J.K.C.

FOR INFORMATION ONLY

PLOT DATE = 4/27/59  
PLOT SCALE = AS NOTED  
USER NAME = AFR