



CONTRACT #72679

FAH ROUTE	SECTION	COUNTY	TOTAL SHEETS	SHEET NO.
8071	*	SANGAMON	425	277
STA.	TO STA.			
FED. ROAD DIST. NO.	ILLINOIS	FED. AID PROJECT		
(84-9) RS-6; (G)Z *				

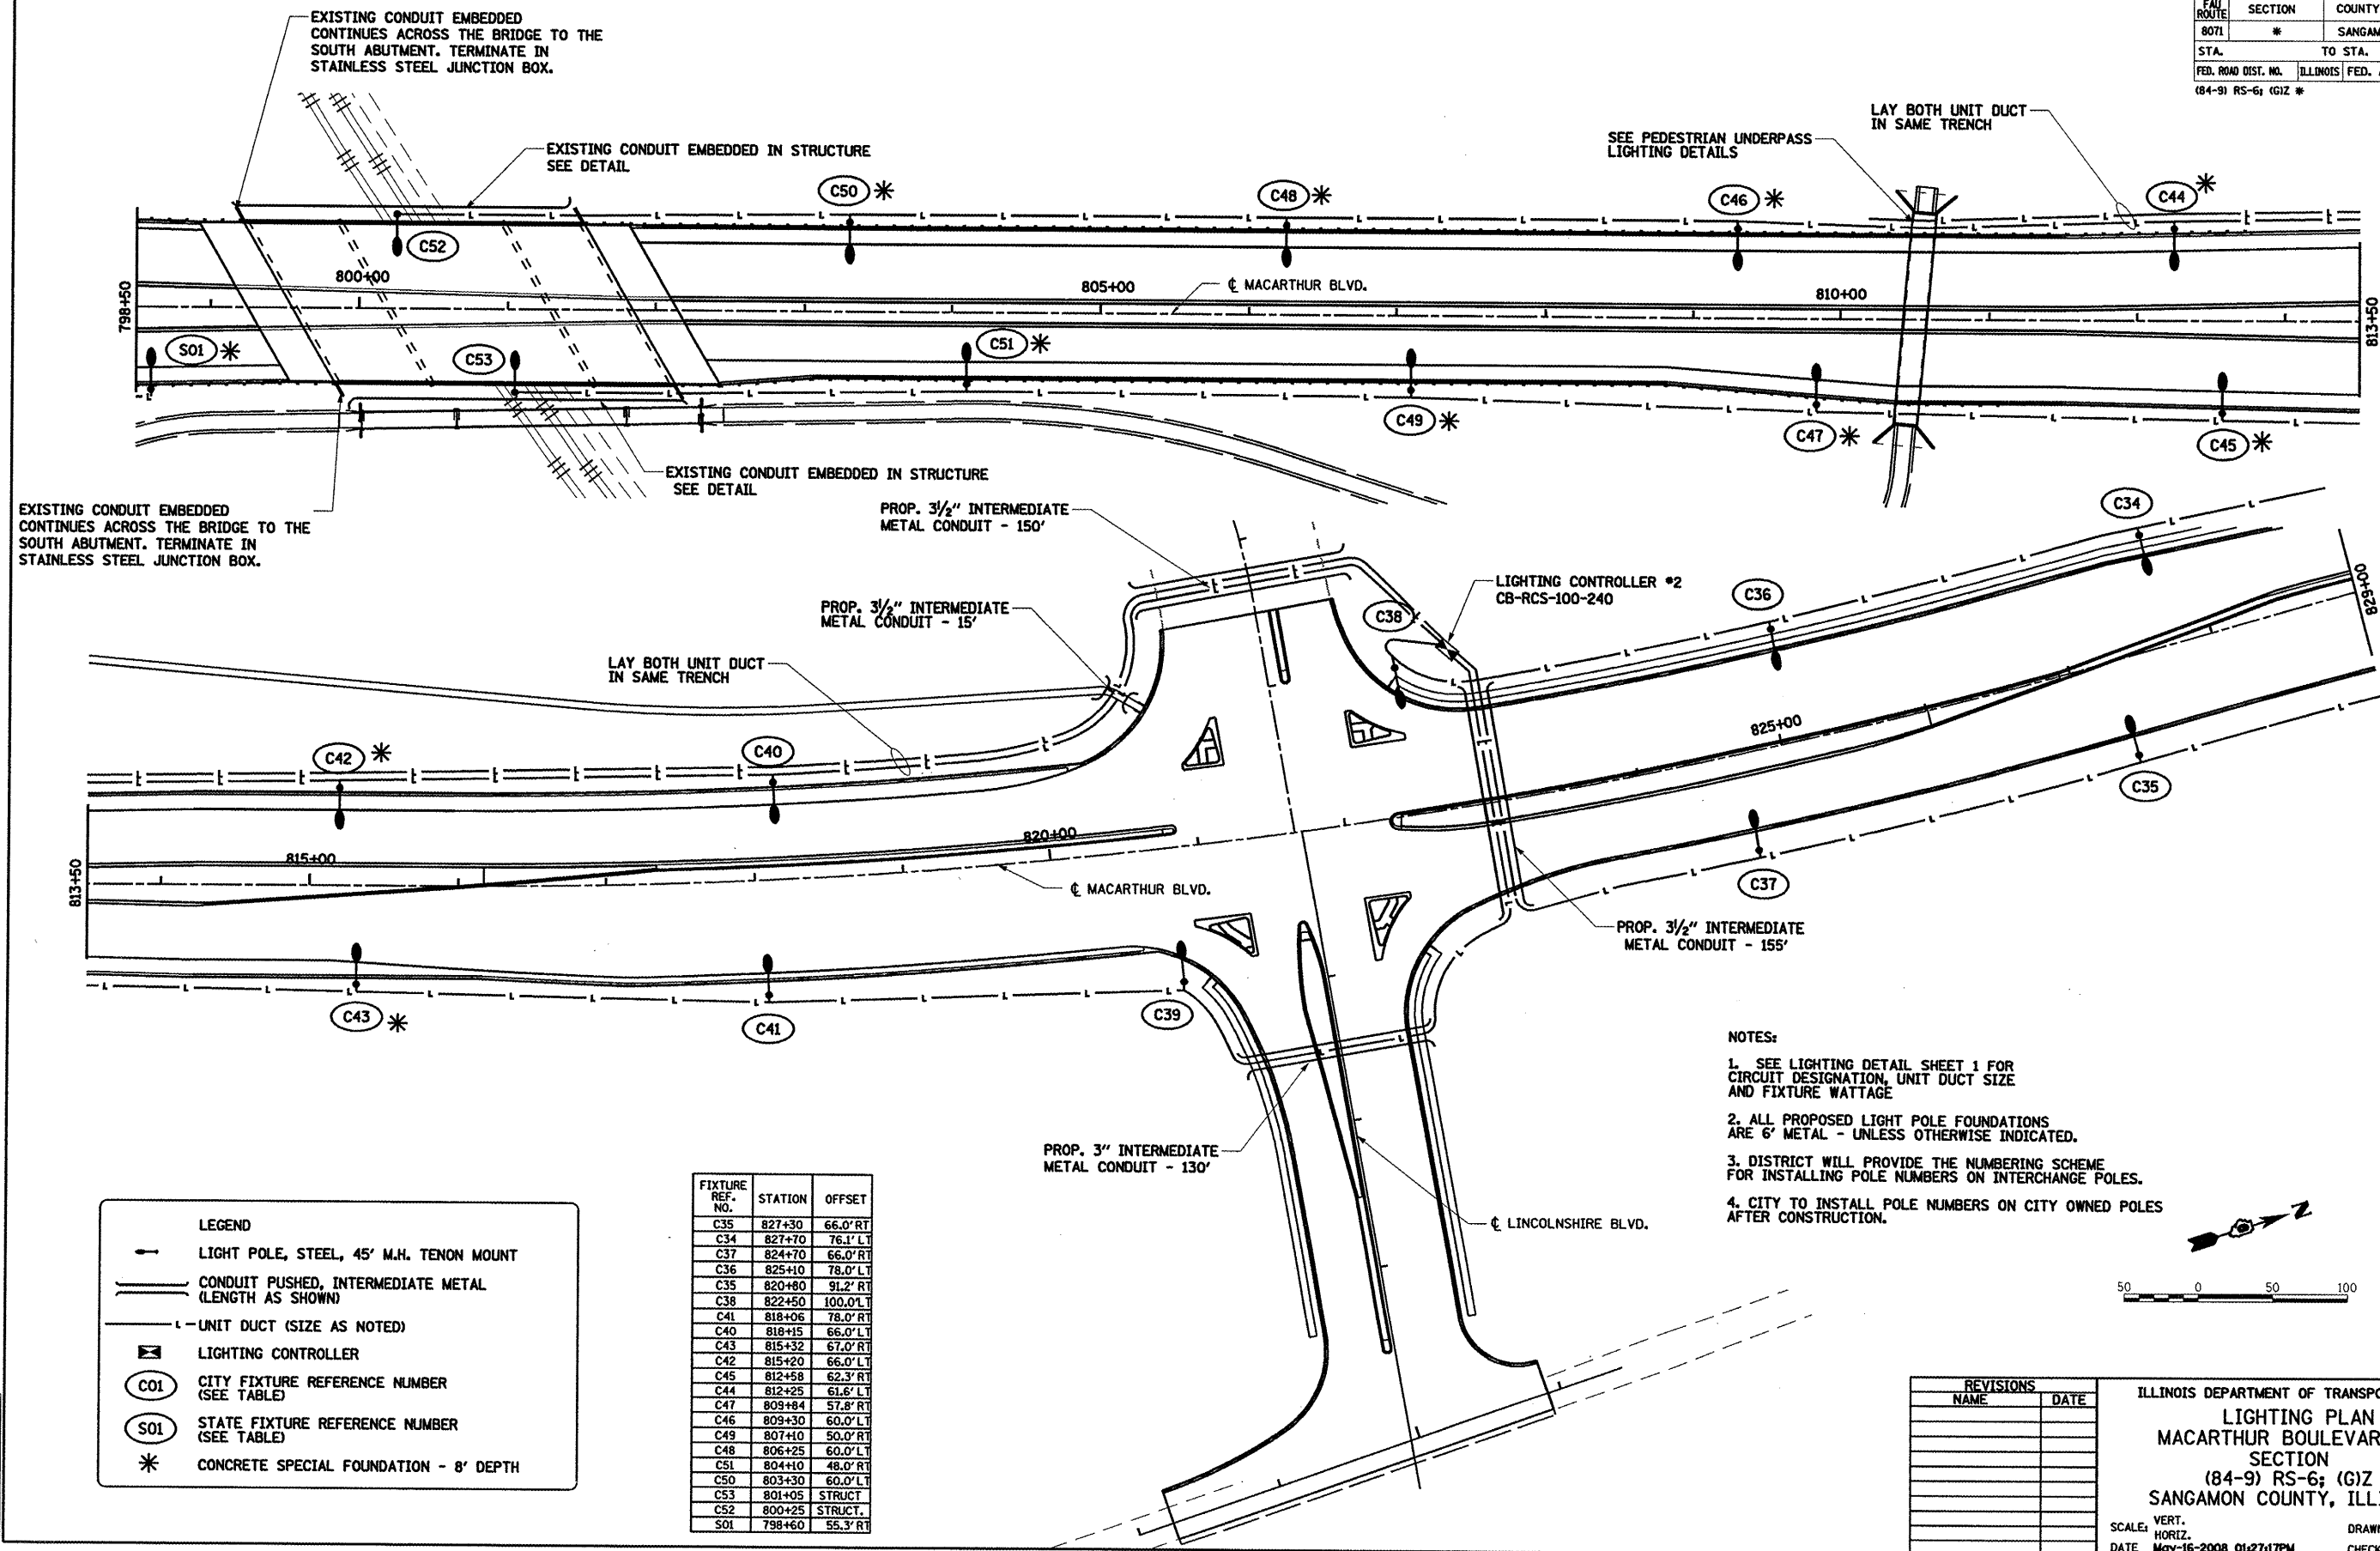

- NOTES:
1. SEE LIGHTING DETAIL SHEET 1 FOR CIRCUIT DESIGNATION, UNIT DUCT SIZE AND FIXTURE WATTAGE
 2. ALL PROPOSED LIGHT POLE FOUNDATIONS ARE 6" METAL - UNLESS OTHERWISE INDICATED.
 3. DISTRICT WILL PROVIDE THE NUMBERING SCHEME FOR INSTALLING POLE NUMBERS ON INTERCHANGE POLES.
 4. CITY TO INSTALL POLE NUMBERS ON CITY OWNED POLES AFTER CONSTRUCTION.

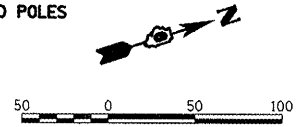

LEGEND

- LIGHT POLE, STEEL, 45' M.H. TENON MOUNT
- CONDUIT PUSHED, INTERMEDIATE METAL (LENGTH AS SHOWN)
- UNIT DUCT (SIZE AS NOTED)
- ☒ LIGHTING CONTROLLER
- (C01) CITY FIXTURE REFERENCE NUMBER (SEE TABLE)
- (S01) STATE FIXTURE REFERENCE NUMBER (SEE TABLE)
- * CONCRETE SPECIAL FOUNDATION - 8' DEPTH

FIXTURE REF. NO.	STATION	OFFSET
C35	827+30	66.0' RT
C34	827+70	76.1' LT
C37	824+70	66.0' RT
C36	825+10	78.0' LT
C35	820+80	91.2' RT
C38	822+50	100.0' LT
C41	818+06	78.0' RT
C40	818+15	66.0' LT
C43	815+32	67.0' RT
C42	815+20	66.0' LT
C45	812+58	62.3' RT
C44	812+25	61.6' LT
C47	809+84	57.8' RT
C46	809+30	60.0' LT
C49	807+10	50.0' RT
C48	806+25	60.0' LT
C51	804+10	48.0' RT
C50	803+30	60.0' LT
C53	801+05	STRUCT.
C52	800+25	STRUCT.
S01	798+60	55.3' RT

REVISIONS	
NAME	DATE

ILLINOIS DEPARTMENT OF TRANSPORTATION
LIGHTING PLAN
MACARTHUR BOULEVARD - 2
SECTION
(84-9) RS-6; (G)Z
SANGAMON COUNTY, ILLINOIS

SCALE: VERT. _____
 HORIZ. _____
 DATE May-16-2008 01:27:17PM

DRAWN BY JAP
 CHECKED BY JWM

Copyright Hanson Professional Services Inc. 8MS_YEARS
HANSON

May-16-2008 01:27:17PM
 #FILE#