

| F.A. RTE. | SECTION | COUNTY | TOTAL SHEETS | SHEET NO. |
|-----------|----------------------------------|---------|--------------|-----------|
| | 03-00026-00-PK 06-00026-01-MS | MADISON | 53 | 37 |

FEDERAL AID PROJECT

KEYED NOTES:

- 1 SEE FOUNTAIN DETAILS ON SHEET PA3-04.
 - 2 COMPASS FOUNTAIN/WATERFALL FOUNTAIN CONTROLLER SHALL BE UL LISTED, NEMA 3R, WITH SINGLE POINT ELECTRICAL CONNECTION. CONTROLLER SHALL INCLUDE THE FOLLOWING:
 - *HAND-OFF-AUTO SWITCH (ONE FOR EACH FILTER/PUMP ASSEMBLY (FP-1, FP-2))
 - *TIMER FOR EACH SYSTEM
 - *INTERNAL BREAKERS
 - *LOW VOLTAGE TRANSFORMER FOR CONTROLS
 - *MICRO PROCESSOR FOR OPERATION
- SEE ELECTRICAL FOR SERVICE FEEDER AND PANEL.

211 N. Broadway
Suite 1900
St. Louis, MO 63102
(314) 241-8188
FAX (314) 241-0125



LEWIS AND CLARK MEMORIAL TOWER
VILLAGE OF HARTFORD, ILLINOIS
HARTFORD, ILLINOIS 62049

SHEET TITLE:
**FIRST FLOOR PLAN-
FOUNTAIN PIPING-
PLUMBING**


| REV. NO. | REMARKS | DATE |
|----------|---------|------|
| | | |
| | | |
| | | |

KENNEDY PROJECT NO
KAI# 10-02048

ISSUE DATE
APRIL 11, 2008

SHEET NO
P3-03

© 2008 KENNEDY ASSOCIATES INCORPORATED

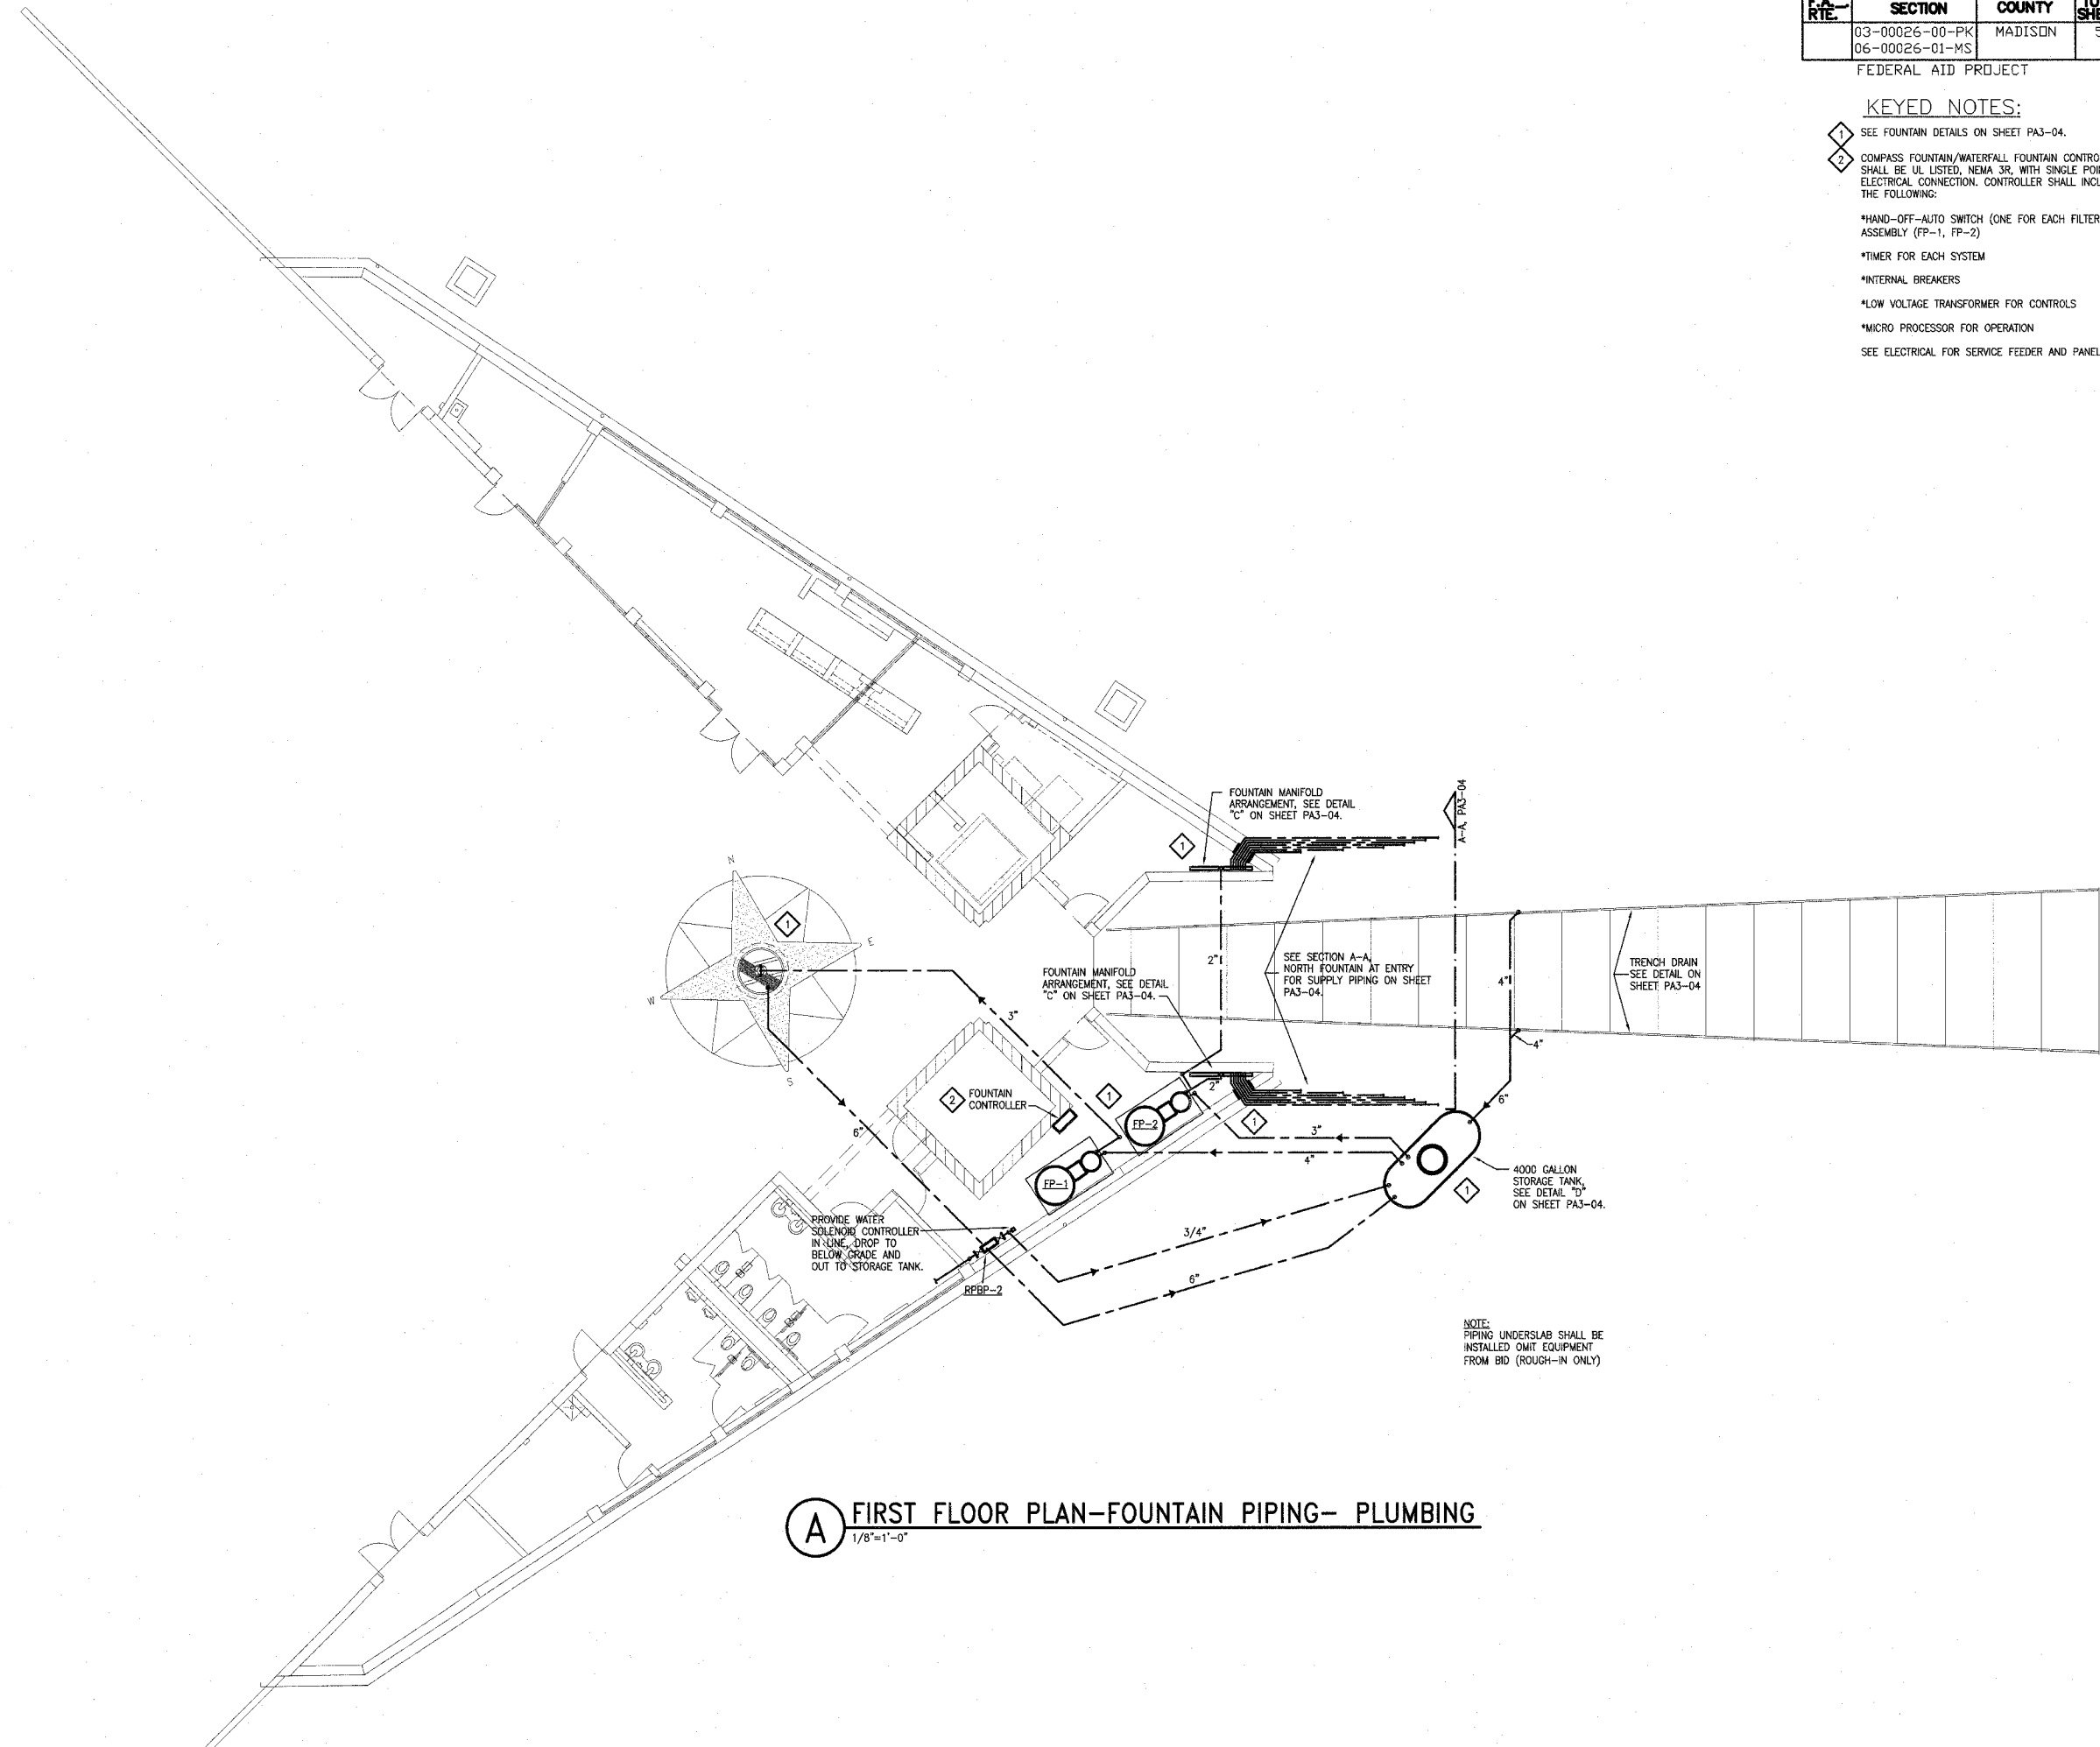

A FIRST FLOOR PLAN-FOUNTAIN PIPING- PLUMBING
1/8"=1'-0"

NOTE:
PIPING UNDERSLAB SHALL BE
INSTALLED OMIT EQUIPMENT
FROM BID (ROUGH-IN ONLY)

U:\10-02048\CAD\PHASE-2\2B\PHASE2A\PA3-03.DWG | 7/11/2005 1:17:18 PM | Xref's: BS-PLAN-2A TB2436CDL | Images: none