


| F.A. RTE. | SECTION | COUNTY | TOTAL SHEETS | SHEET NO. |
|-----------|----------------------------------|---------|--------------|-----------|
| | 03-00026-00-PK 06-00026-01-MS | MADISON | 53 | 44 |

FEDERAL AID PROJECT

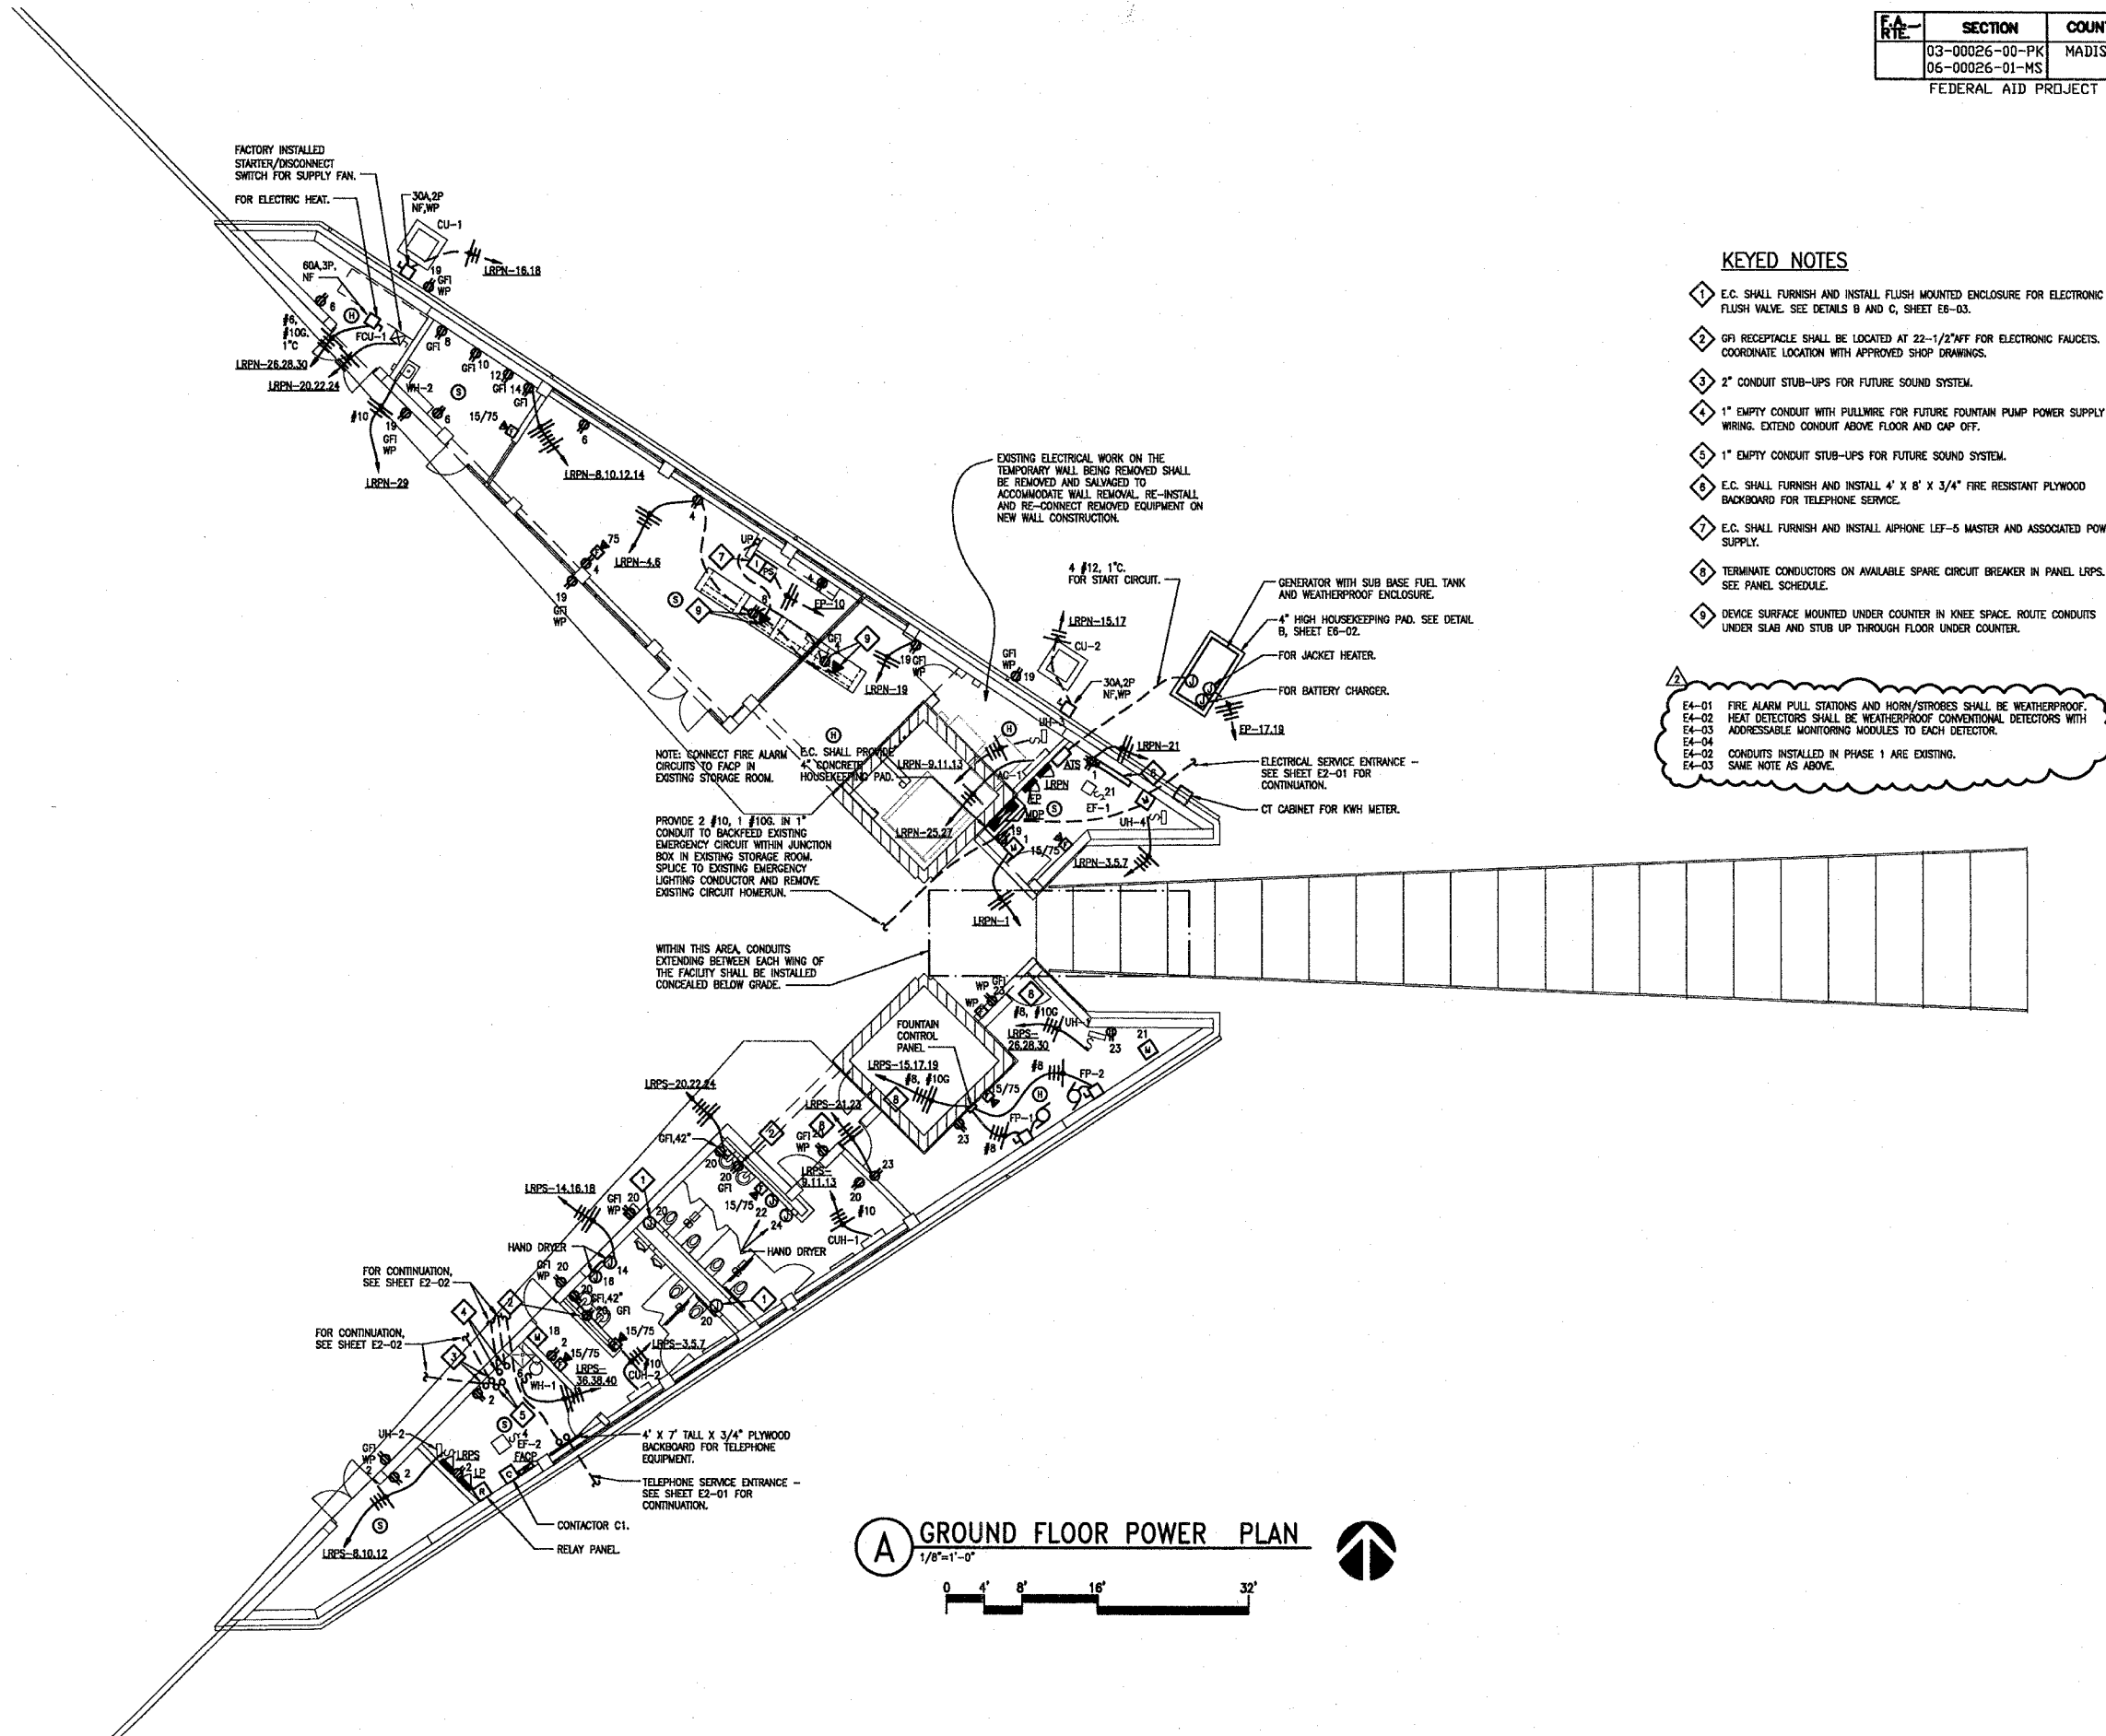

KEYED NOTES

- 1 E.C. SHALL FURNISH AND INSTALL FLUSH MOUNTED ENCLOSURE FOR ELECTRONIC FLUSH VALVE. SEE DETAILS B AND C, SHEET E6-03.
- 2 GFI RECEPTACLE SHALL BE LOCATED AT 22-1/2" AFF FOR ELECTRONIC FAUCETS. COORDINATE LOCATION WITH APPROVED SHOP DRAWINGS.
- 3 2" CONDUIT STUB-UPS FOR FUTURE SOUND SYSTEM.
- 4 1" EMPTY CONDUIT WITH PULLWIRE FOR FUTURE FOUNTAIN PUMP POWER SUPPLY WIRING. EXTEND CONDUIT ABOVE FLOOR AND CAP OFF.
- 5 1" EMPTY CONDUIT STUB-UPS FOR FUTURE SOUND SYSTEM.
- 6 E.C. SHALL FURNISH AND INSTALL 4' X 8' X 3/4" FIRE RESISTANT PLYWOOD BACKBOARD FOR TELEPHONE SERVICE.
- 7 E.C. SHALL FURNISH AND INSTALL ALPHAONE LEF-5 MASTER AND ASSOCIATED POWER SUPPLY.
- 8 TERMINATE CONDUCTORS ON AVAILABLE SPARE CIRCUIT BREAKER IN PANEL LRPS. SEE PANEL SCHEDULE.
- 9 DEVICE SURFACE MOUNTED UNDER COUNTER IN KNEE SPACE. ROUTE CONDUITS UNDER SLAB AND STUB UP THROUGH FLOOR UNDER COUNTER.

E4-01 FIRE ALARM PULL STATIONS AND HORN/STROBES SHALL BE WEATHERPROOF.
 E4-02 HEAT DETECTORS SHALL BE WEATHERPROOF CONVENTIONAL DETECTORS WITH ADDRESSABLE MONITORING MODULES TO EACH DETECTOR.
 E4-04 ADDRESSABLE MONITORING MODULES TO EACH DETECTOR.
 E4-02 CONDUITS INSTALLED IN PHASE 1 ARE EXISTING.
 E4-03 SAME NOTE AS ABOVE.

A GROUND FLOOR POWER PLAN
 1/8" = 1'-0"
 0 4' 8' 16' 32'

211 N. Broadway
 Suite 100
 St. Louis, MO 63102
 (314) 241-0100
 FAX (314) 241-0128

KAI

LEWIS AND CLARK MEMORIAL TOWER
VILLAGE OF HARTFORD, ILLINOIS
 HARTFORD, ILLINOIS 62049

SHEET TITLE
GROUND FLOOR POWER PLAN

| REV. NO. | DATE | REMARKS |
|----------|------|---------|
| | | |
| | | |
| | | |

KENNEDY PROJECT NO
 KAI# 10-02048
 ISSUE DATE
 APRIL 11, 2008
 SHEET NO
E4-01