
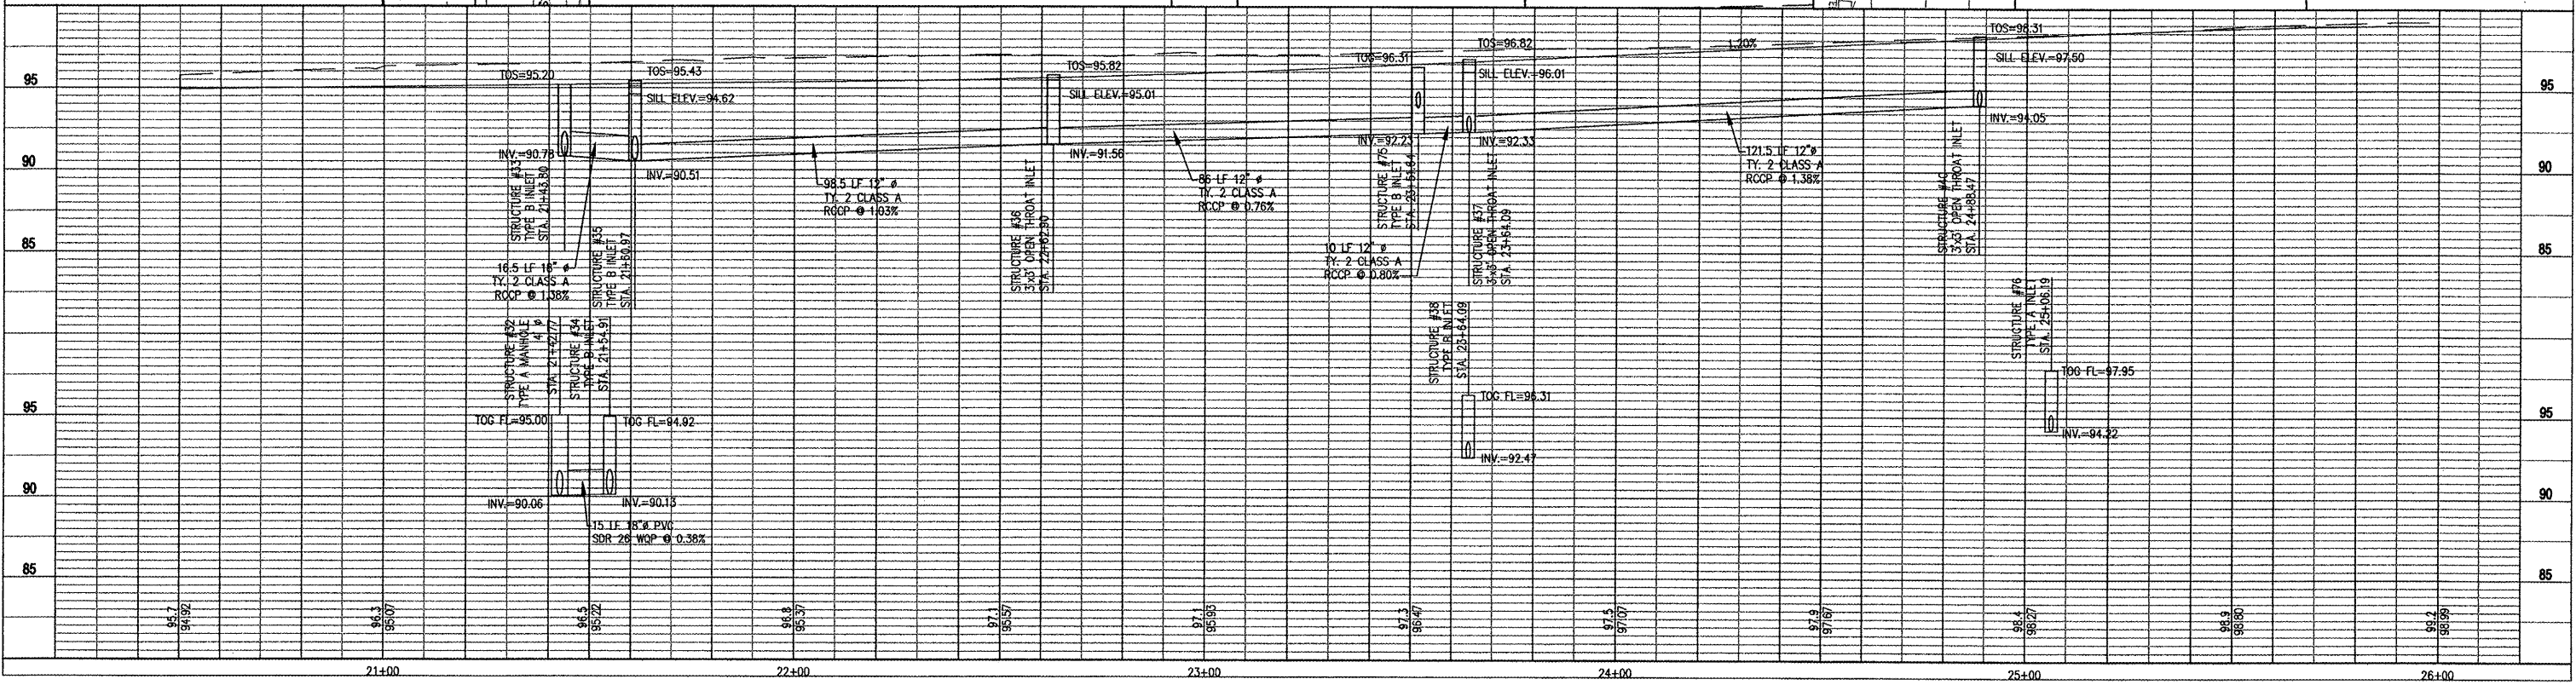


#/SECTION	COUNTY	TOTAL SHEETS	SHEET NO.
9392 05-00024-00-PV	MADISON	81	26
STA. 20+50.00 TO STA. 26+00.00			

CONTRACT NO. 97347

DRAINAGE PLAN AND PROFILE

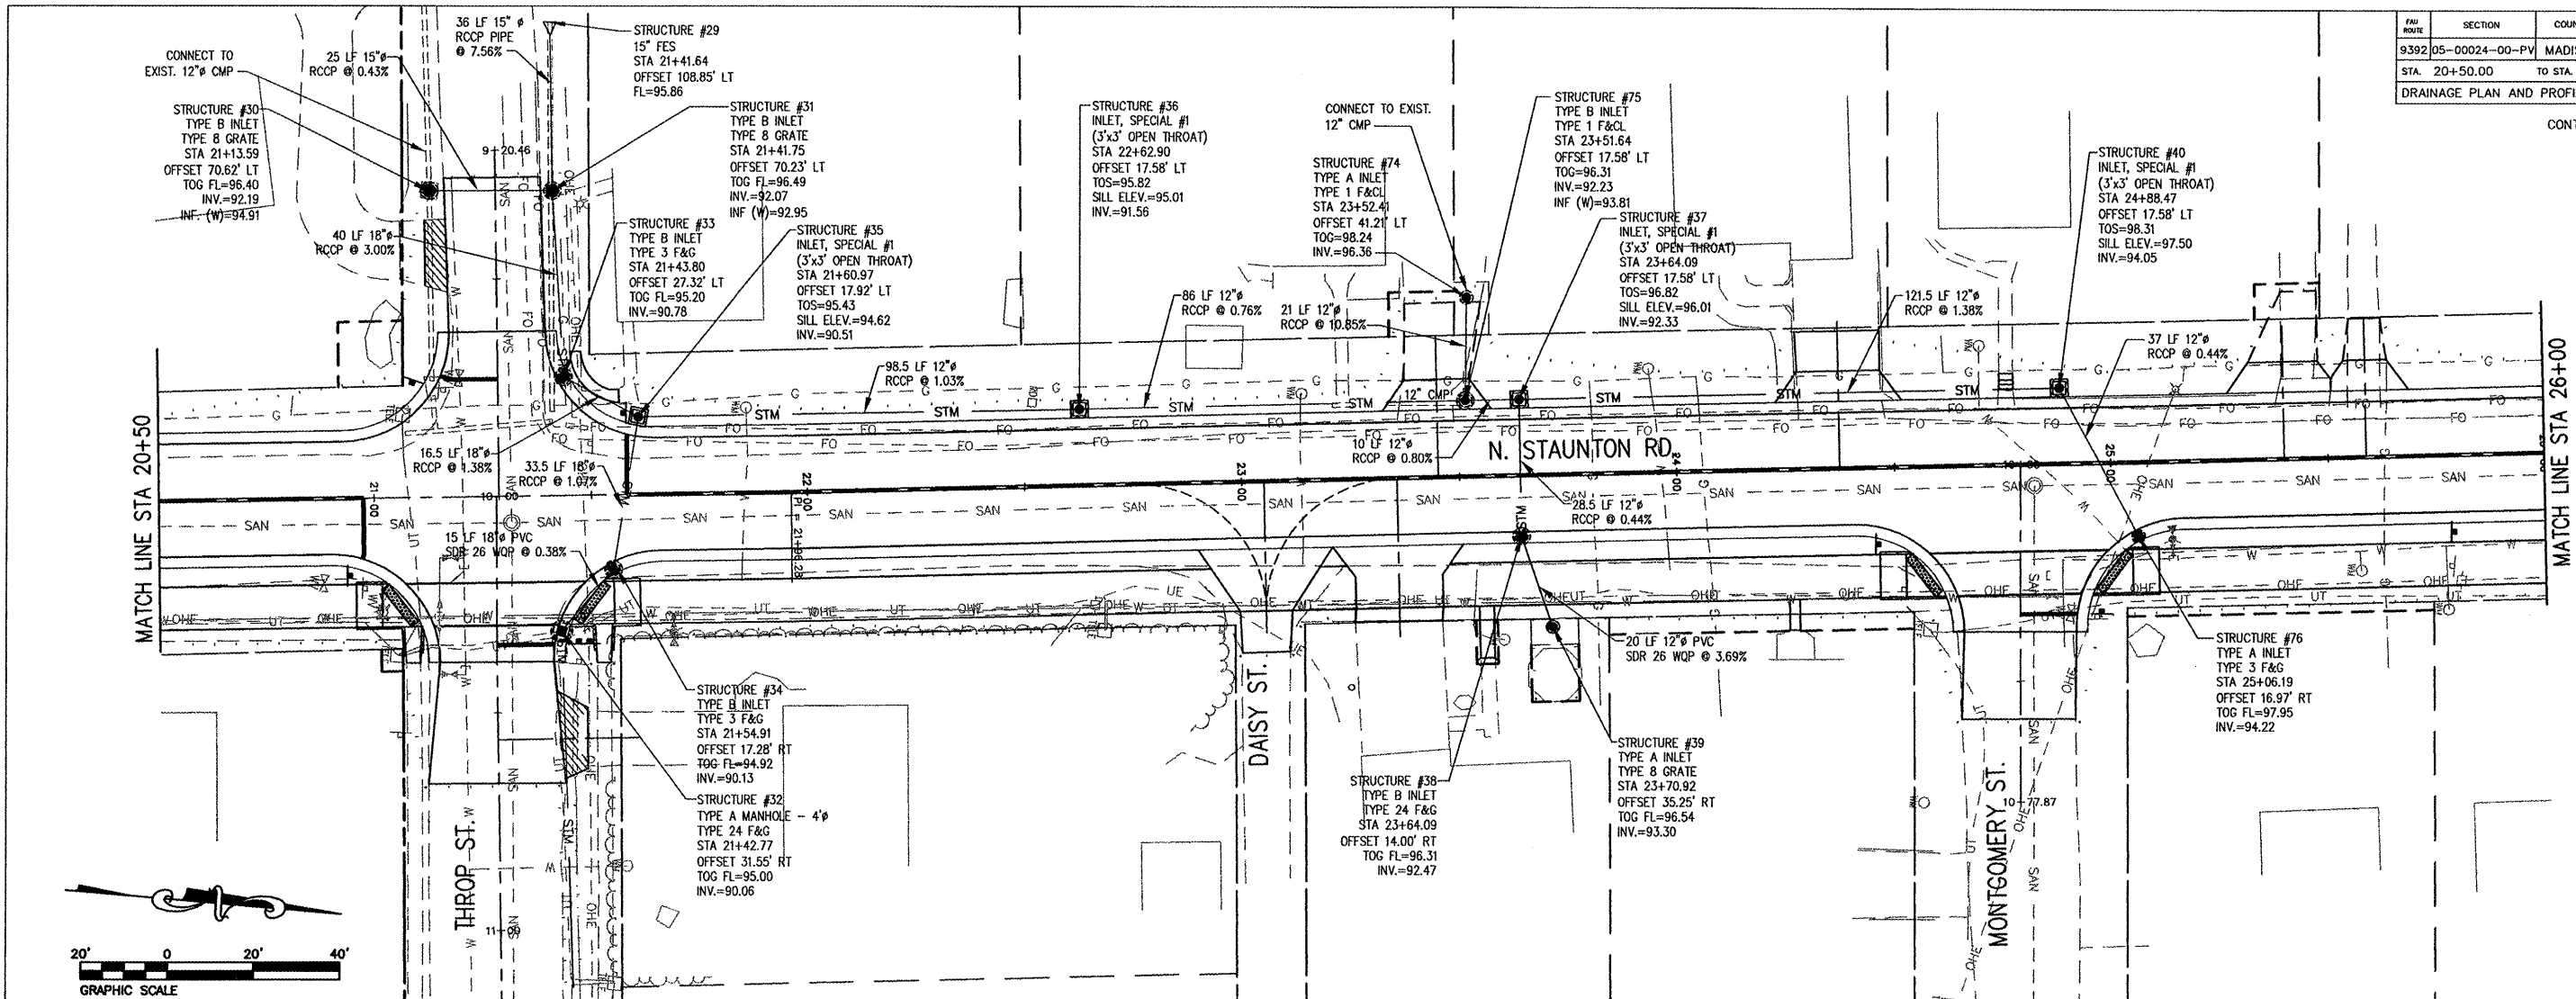

P:\030131\dwg\030131-PPSTORM.dwg 1/16/2008 11:27:19 AM CST