




ROUTE NO.	SECTION	COUNTY	TOTAL SHEETS	SHEET NO.
F.A.U. 9641	05-00100-00-FP	WILLIAMSON	53	48

ILLINOIS FAIR STREET  
CONTRACT NO. 99309

ITEM NO.	ITEM	TONS	ITEM NO.	ITEM	TONS
0	ADJUST W/M	20	7	G.V. / CAP	4
1	(2) G.V. / CAP	6	8	ADJUST W/M	20
2	ADJUST W/M	20	9	G.V.	2
3	INT. / FIRE HY.	4	10	M.H. ADJUST	2
4	S.C.	2	11	SERVICE LINE	20
5	M.H. ADJUST	2	12	G.V. / METER	4
6	S.C.	2	13	G.V.	2

140 L.F. WATER MAIN BORED, YELOMINE (6")	1 EA. GATE VALVES TO BE REMOVED
140 L.F. LOCATOR WIRE	3 EA. ADJUST EX. WATER MAIN (6")
2 EA. GATE VALVES TO BE ADJUSTED	2 EA. GATE VALVE W/ BOX, (6")
1 EA. FIRE HY. TO BE REMOVED	2 EA. RELOCATE/ADJUST WATER METER
1 EA. CUT AND CAP EX. WATER MAIN (6")	1 EA. WATER SERVICE RECONNECTION
1 EA. FIRE HYDRANT W/ AUX. VALVE	52 TON TRENCH BACKFILL, WATERMAIN
20 L.F. COPPER SERVICE, TYPE K (3/4")	

290 L.F. WATER MAIN BORED, YELOMINE (6")	2 EA. ADJUST EX. WATER MAIN (6")
290 L.F. LOCATOR WIRE	1 EA. GATE VALVE W/ BOX, (6")
1 EA. GATE VALVES TO BE ADJUSTED	1 EA. RELOCATE/ADJUST WATER METER
2 EA. SANITARY M.H. TO BE ADJUSTED	1 EA. WATER SERVICE RECONNECTION
1 EA. CUT AND CAP EX. WATER MAIN (6")	32 TON TRENCH BACKFILL, WATERMAIN
40 L.F. PVC CASING, CL 160 (10")	

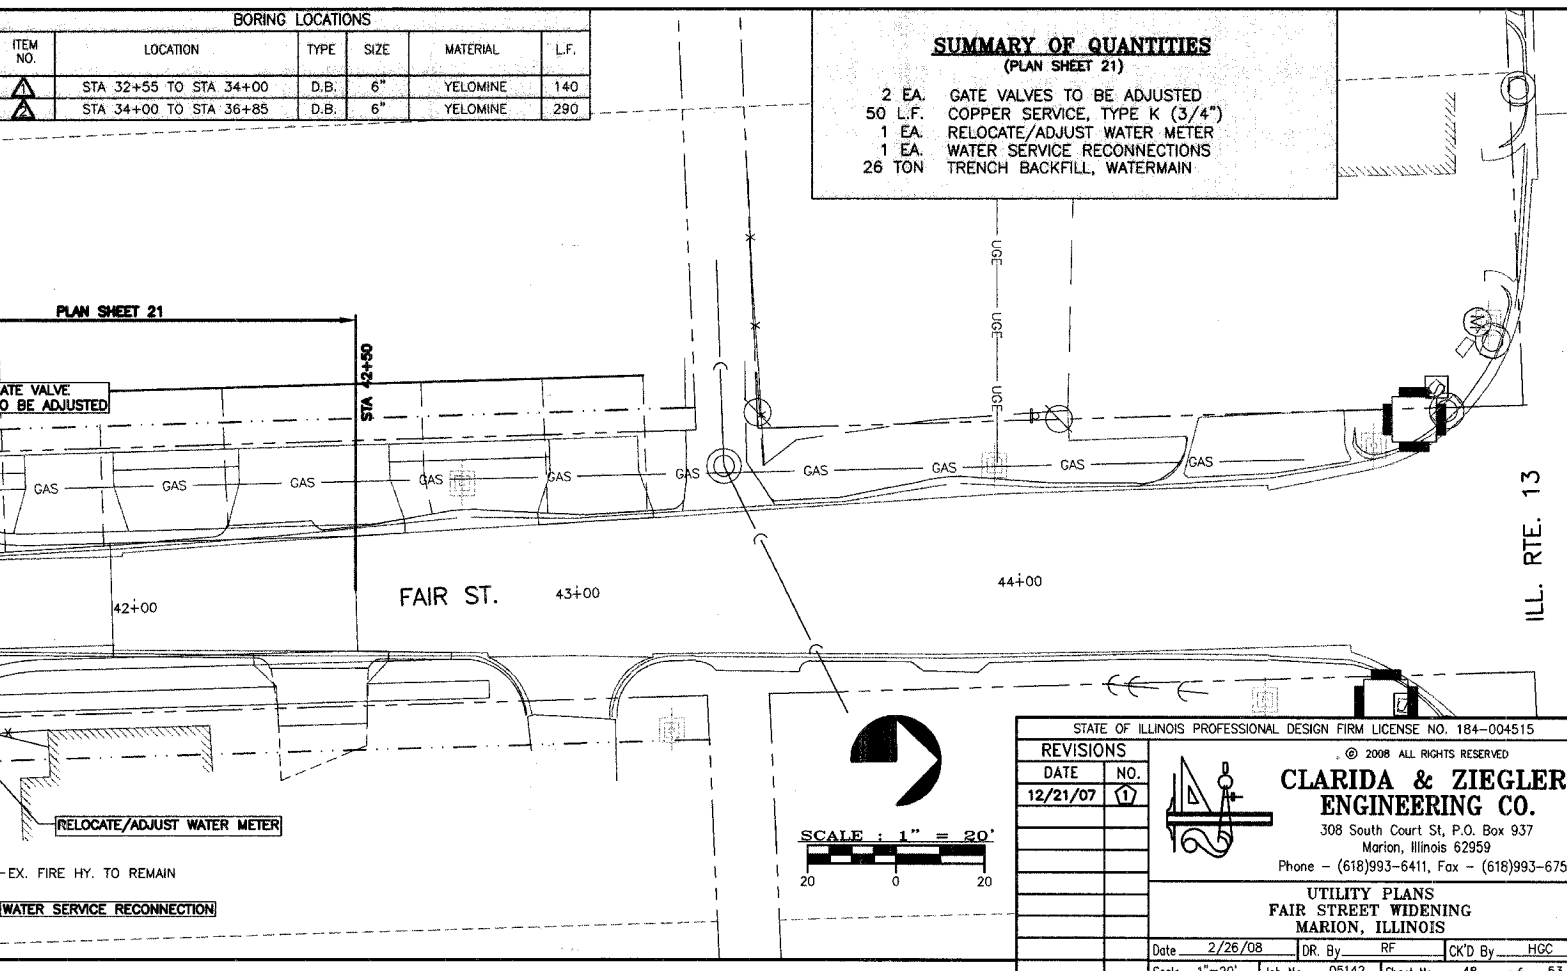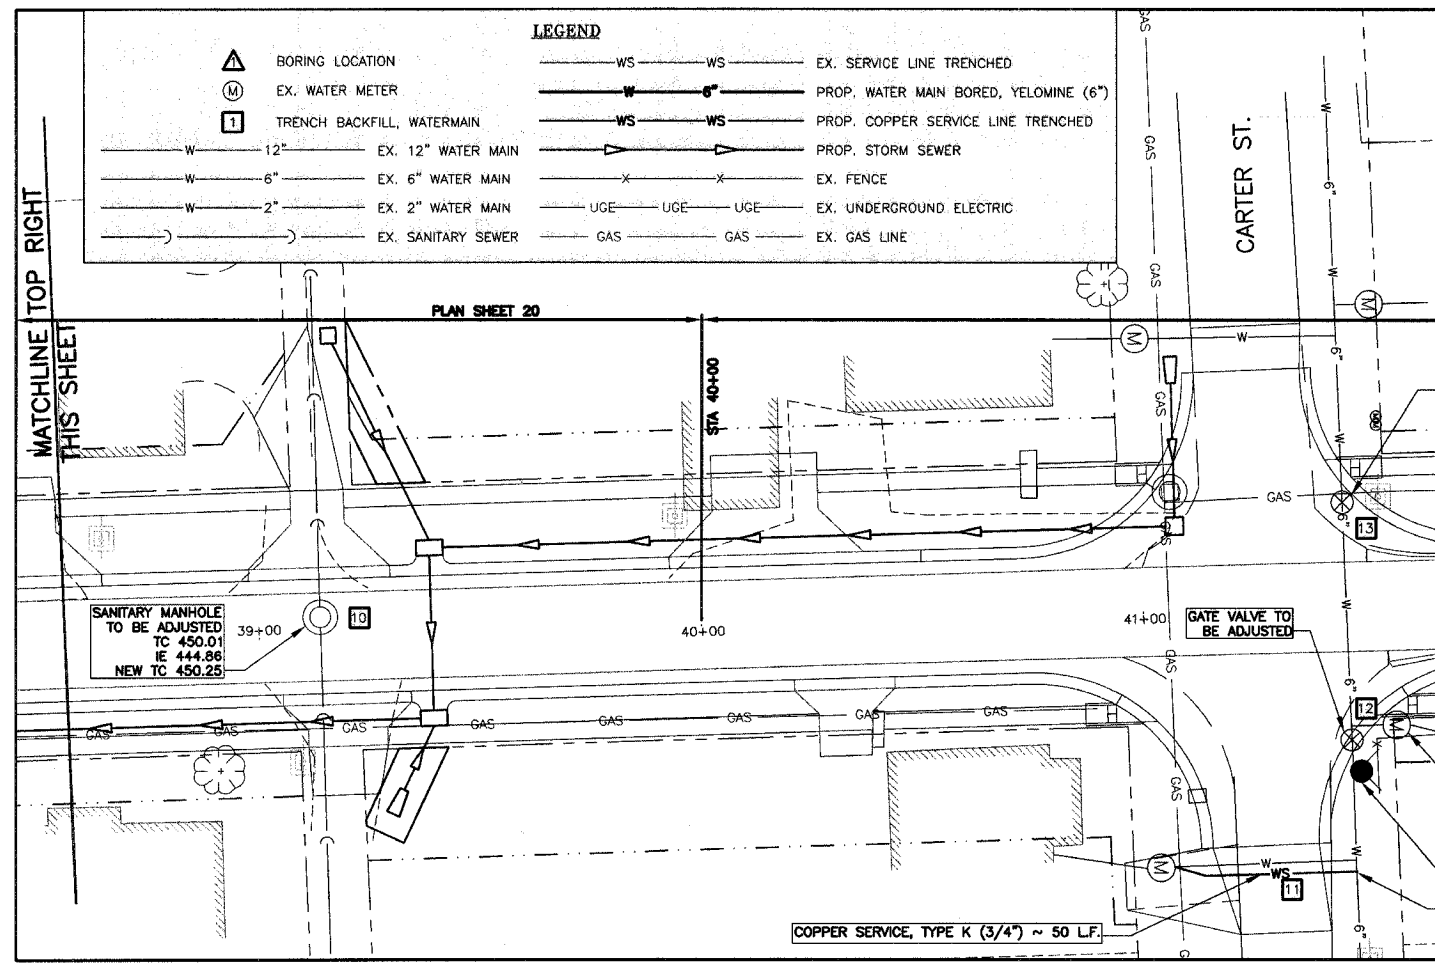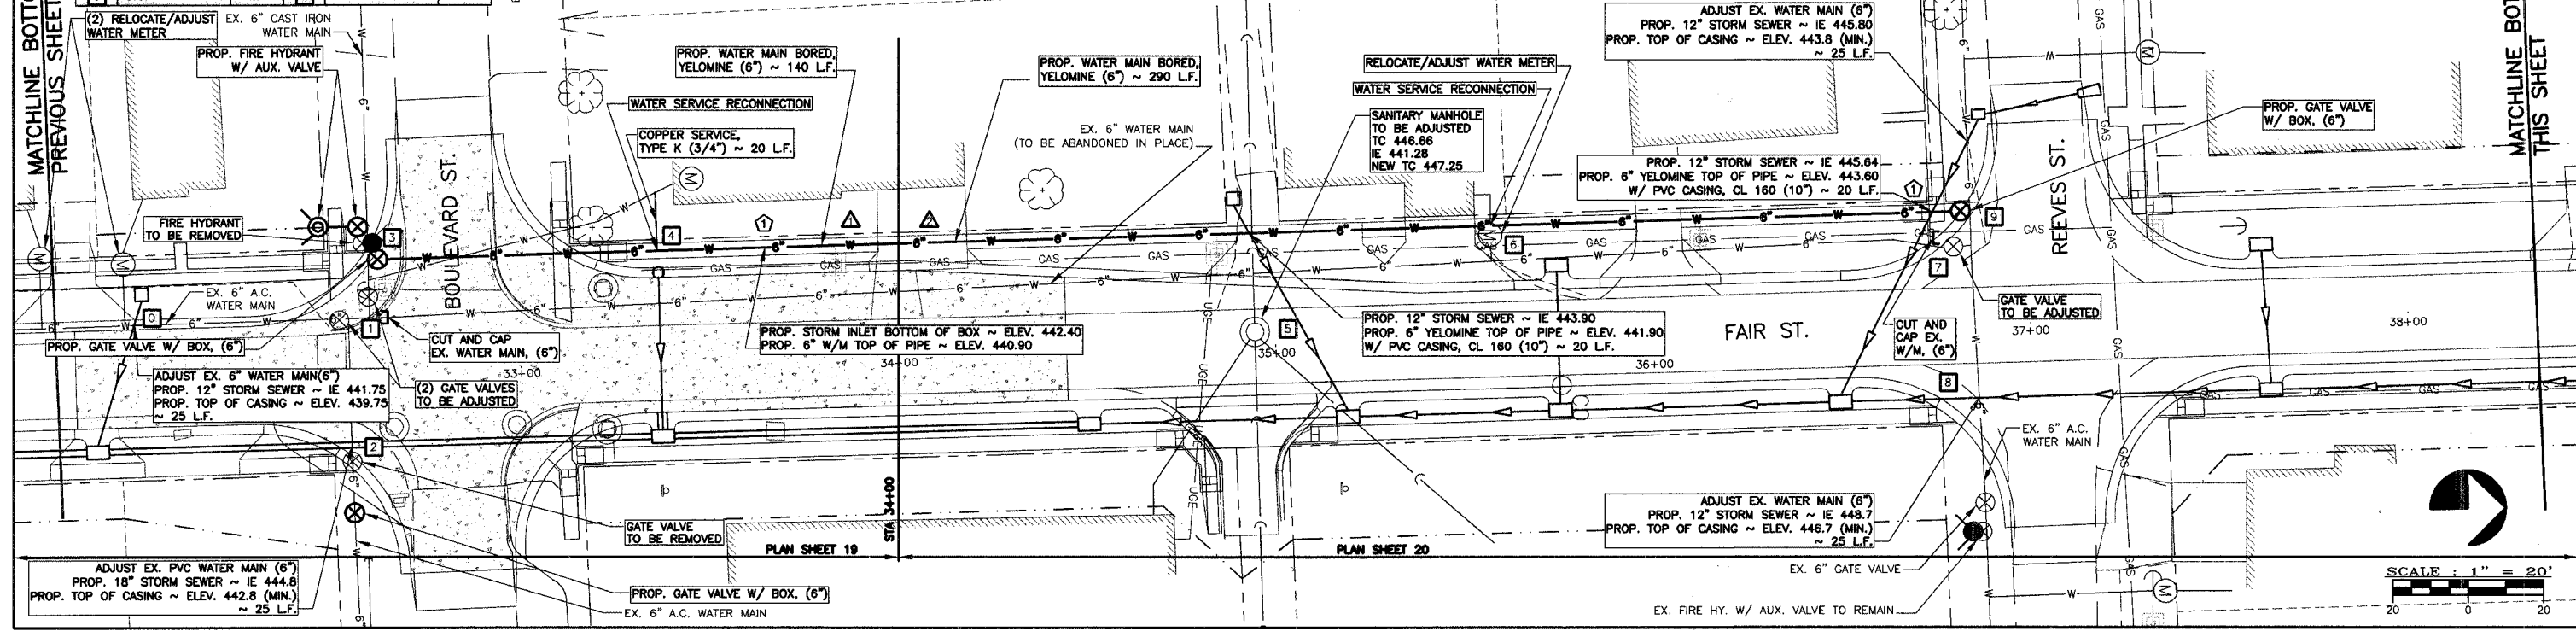

STATE OF ILLINOIS PROFESSIONAL DESIGN FIRM LICENSE NO. 184-004515  
© 2008 ALL RIGHTS RESERVED

DATE	NO.
12/21/07	1

**CLARIDA & ZIEGLER ENGINEERING CO.**  
308 South Court St, P.O. Box 937  
Marion, Illinois 62959  
Phone - (618)993-6411, Fax - (618)993-6750

UTILITY PLANS  
FAIR STREET WIDENING  
MARION, ILLINOIS

Date: 2/26/08 DR. By: RF CK'D By: HGC  
Scale: 1"=20' Job No. 05142 Sheet No. 48 of 53