



THE LOCATION, SIZE AND TYPE OF MATERIAL OF EXISTING UNDERGROUND UTILITIES INDICATED ON THE PLANS IS NOT REPRESENTED AS BEING ACCURATE, SUFFICIENT OR COMPLETE. IT SHALL BE THE CONTRACTOR'S RESPONSIBILITY TO DETERMINE THE ACTUAL LOCATION OF ALL SUCH FACILITIES, INCLUDING SERVICE CONNECTIONS TO UNDERGROUND UTILITIES. PRIOR TO CONSTRUCTION, THE CONTRACTOR SHALL NOTIFY THE UTILITY COMPANIES OF HIS OPERATIONAL PLANS AND SHALL OBTAIN FROM THE RESPECTIVE UTILITY COMPANIES DETAILED INFORMATION AND ASSISTANCE RELATIVE TO THE LOCATION OF THEIR FACILITIES AND THE WORKING SCHEDULE OF THE COMPANIES FOR REMOVAL OR ADJUSTMENT WHERE REQUIRED. IN THE EVENT AN UNEXPECTED UTILITY INTERFERENCE IS ENCOUNTERED DURING CONSTRUCTION, THE CONTRACTOR SHALL IMMEDIATELY NOTIFY THE UTILITY COMPANY OF JURISDICTION. THE ENGINEER SHALL ALSO BE IMMEDIATELY NOTIFIED. ANY SUCH MAINS AND SERVICES SHALL BE RESTORED TO SERVICE AT ONCE AND PAID FOR BY THE CONTRACTOR AT NO ADDITIONAL COST TO THE CONTRACT.

CALL J.U.I.E. FOR UTILITY INFORMATION AT 1-800-892-0123.

CO053

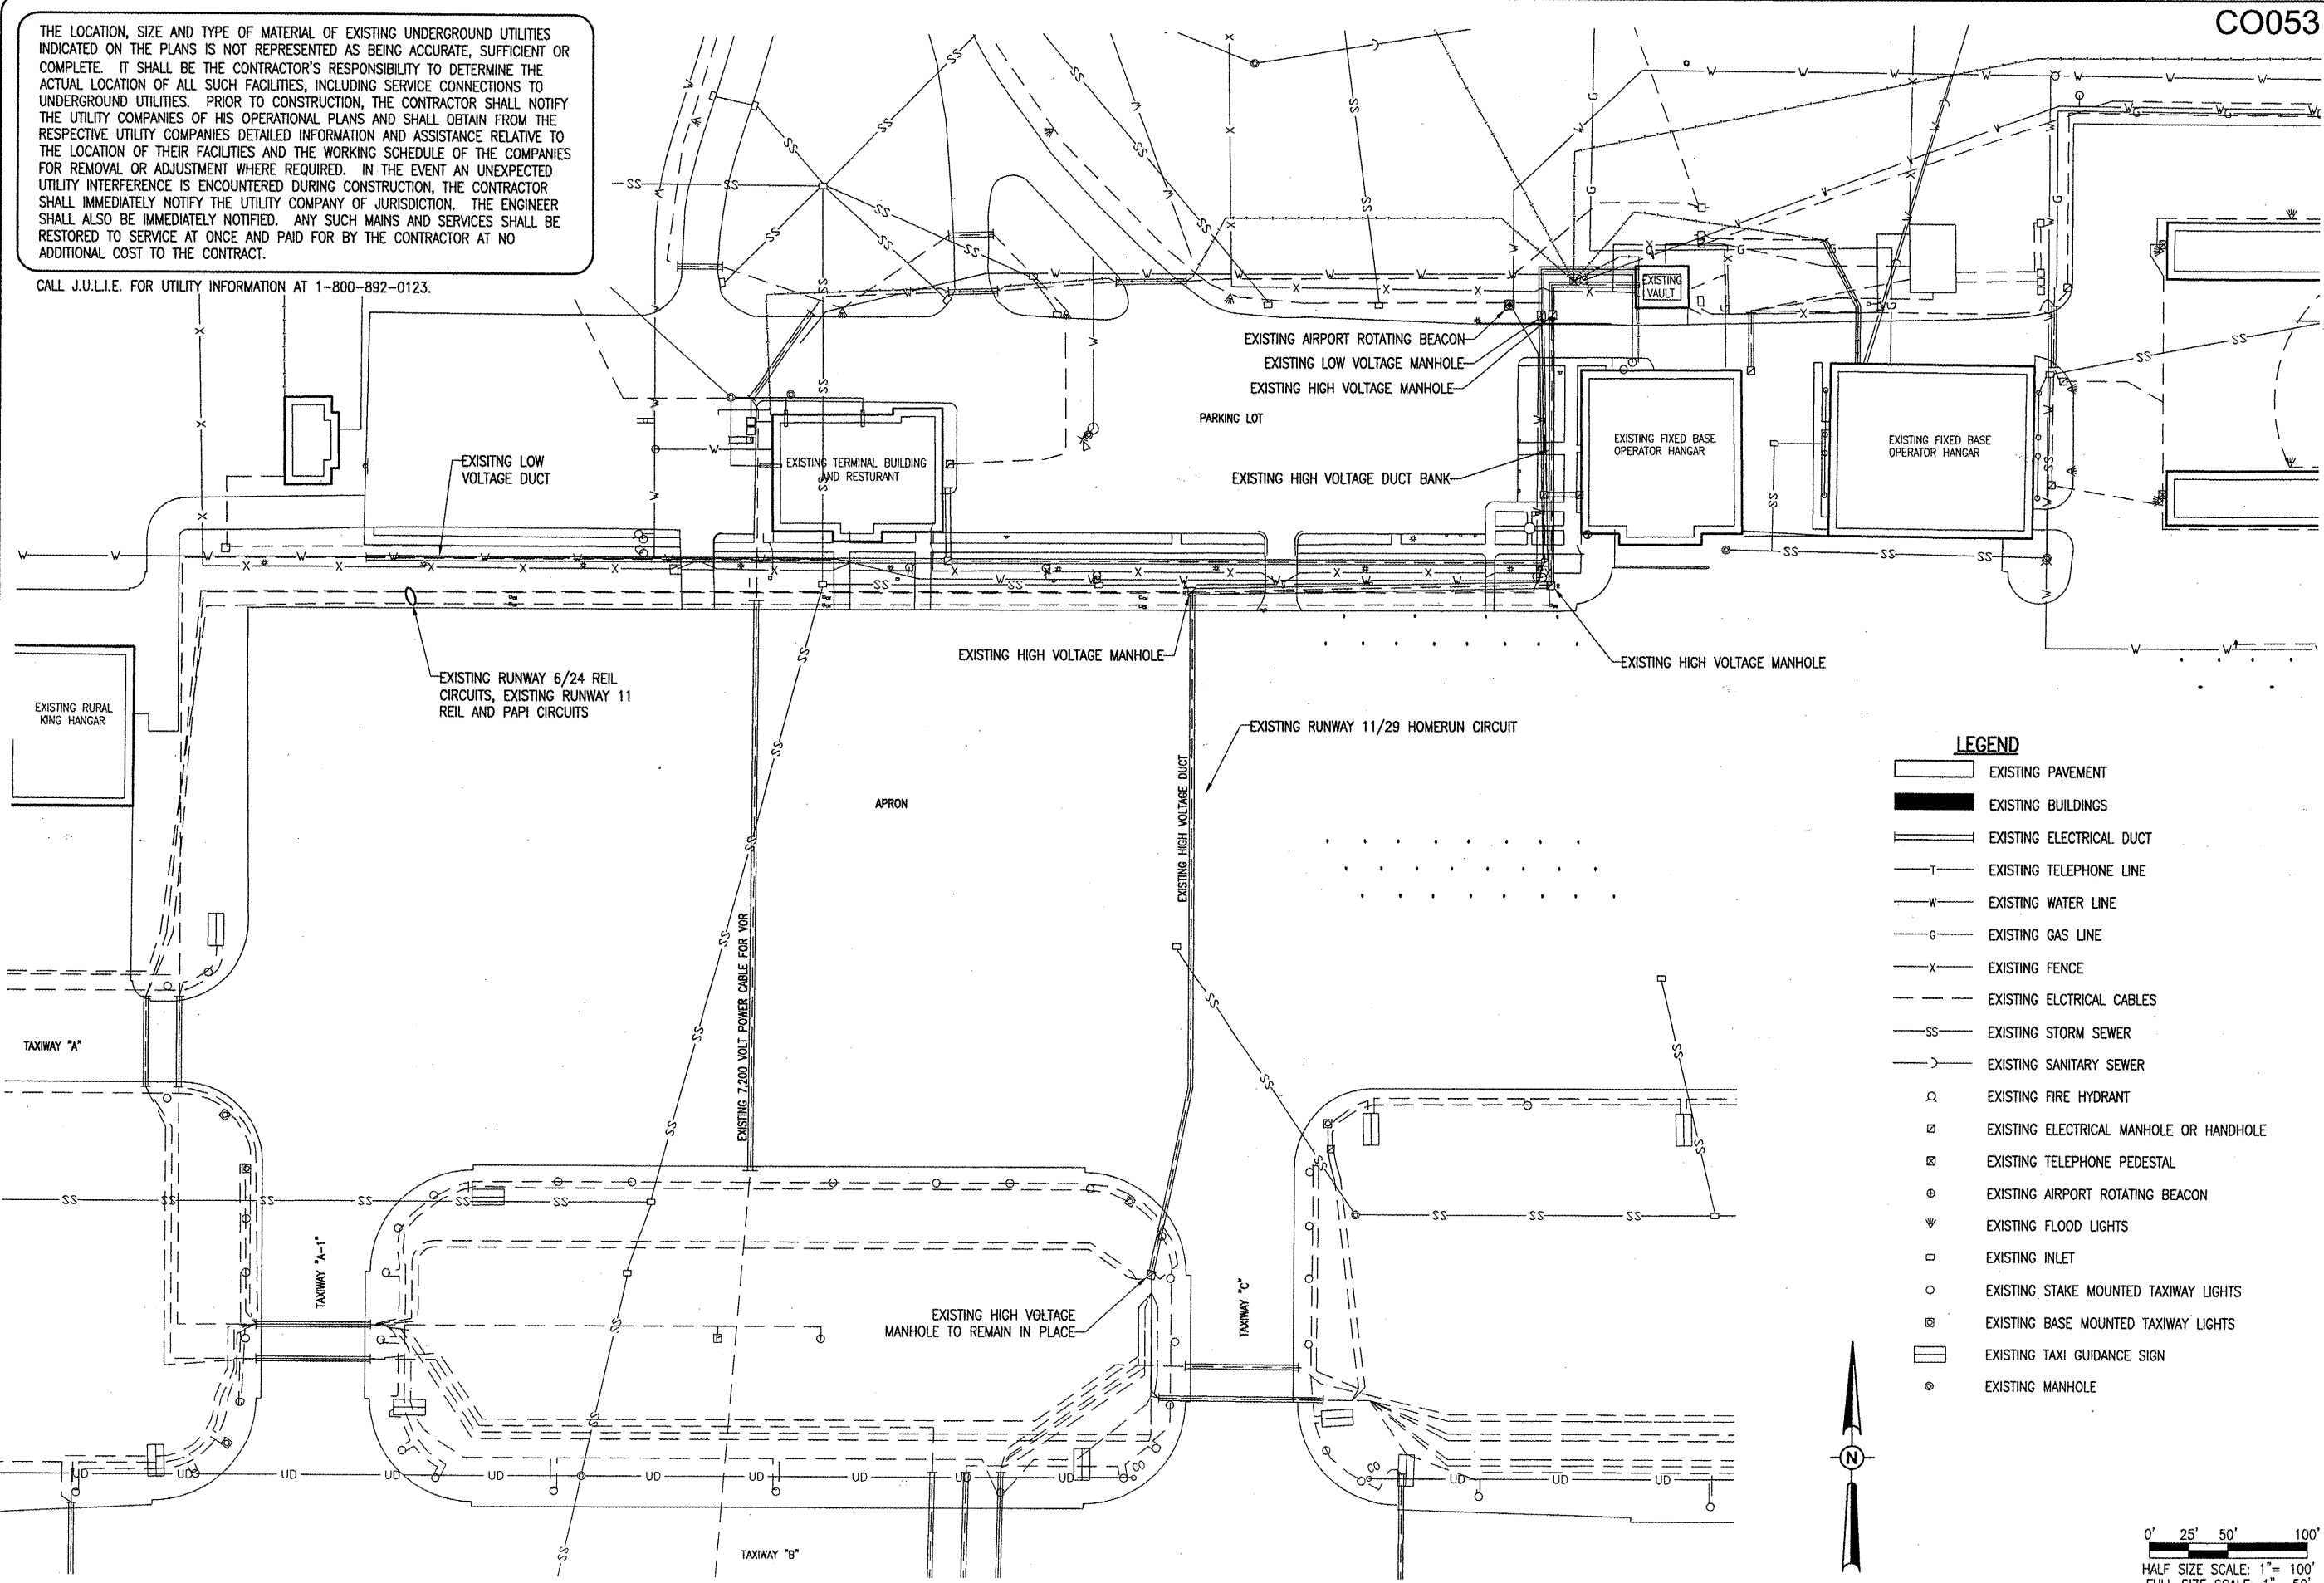

 - LEGEND**
- EXISTING PAVEMENT
 - EXISTING BUILDINGS
 - EXISTING ELECTRICAL DUCT
 - EXISTING TELEPHONE LINE
 - EXISTING WATER LINE
 - EXISTING GAS LINE
 - EXISTING FENCE
 - EXISTING ELECTRICAL CABLES
 - EXISTING STORM SEWER
 - EXISTING SANITARY SEWER
 - EXISTING FIRE HYDRANT
 - EXISTING ELECTRICAL MANHOLE OR HANDHOLE
 - EXISTING TELEPHONE PEDESTAL
 - EXISTING AIRPORT ROTATING BEACON
 - EXISTING FLOOD LIGHTS
 - EXISTING INLET
 - EXISTING STAKE MOUNTED TAXIWAY LIGHTS
 - EXISTING BASE MOUNTED TAXIWAY LIGHTS
 - EXISTING TAXI GUIDANCE SIGN
 - EXISTING MANHOLE



0' 25' 50' 100'
 HALF SIZE SCALE: 1" = 100'
 FULL SIZE SCALE: 1" = 50'

MAY 14, 2008 11:18 AM KINCA00394
 I:\AIRPORTS\COLES\07A0101\CAD\SHEETS\R-101SIT.DWG - Layout1

DATE	REVISION	BY

COLES COUNTY AIRPORT
 AUTHORITY
 COLES COUNTY MEMORIAL AIRPORT

IL PROJ.: MTO-3762 A.I.P. PROJ.: 3-17-0066-B20

HEI Project No.	07A0101D_0800
Filename	R-101SIT.DWG
Scale	SCALE
Date	04/04/08
LAYOUT	MDR 03/19/08
DRAWN	MDR 03/19/08
REVIEWED	CAH/RKL 04/04/08

HANSON
 Hanson Professional Services Inc.
 1525 South Sixth Street
 Springfield, Illinois 62703-2885
 Offices Nationwide

REPLACE ELECTRICAL DUCT IN FRONTAL AREA
 EXISTING UTILITY PLAN