



HANSON PROFESSIONAL SERVICES INC.

815 Commerce Drive, Suite 200
Oak Brook, Illinois 60523
Telephone: 630.990.3800
Fax: 630.990.3801

Illinois Professional Design Firm
Registration No. 184-001084

© Copyright Hanson Professional Service Inc. 2008




JOLIET REGIONAL PORT DISTRICT

1 George Michas Drive
Romeoville, Illinois 60446
Telephone: 815.838.9497
Fax: 815.838.9524

EXTEND RUNWAY 2-20; CONSTRUCT TAXIWAY TURNAROUND


AIP PROJECT NO. 3-17-0140-B42
IDA PROJECT NO. LOT-3792

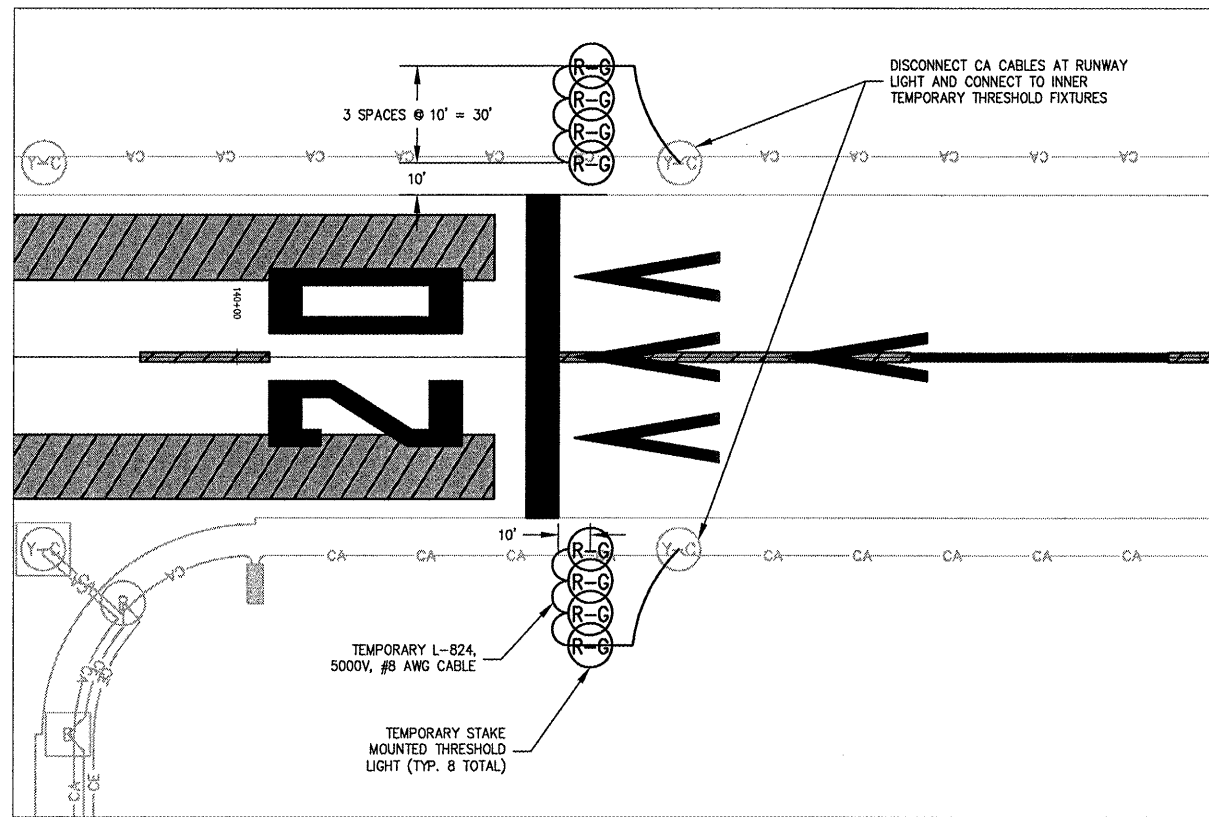

TEMPORARY RUNWAY 20 THRESHOLD - LIGHTING

NOTES

1. ALL WIRING, LENSES, LIGHT FIXTURES, ETC. ASSOCIATED WITH THE TEMPORARY RUNWAY THRESHOLD LIGHTING ARE TO BE INCLUDED IN ITEM AR150560. 10 Y-C LENSES AND 8 R-G LENSES WILL BE REQUIRED FOR THE TEMPORARY THRESHOLD.
2. THE TEMPORARY STAKE MOUNTED THRESHOLD LIGHTS AND LENSES MAY BE REUSED FOR SUBSEQUENT WORK WHERE APPLICABLE ONCE THE TEMPORARY FACILITIES ARE REMOVED.

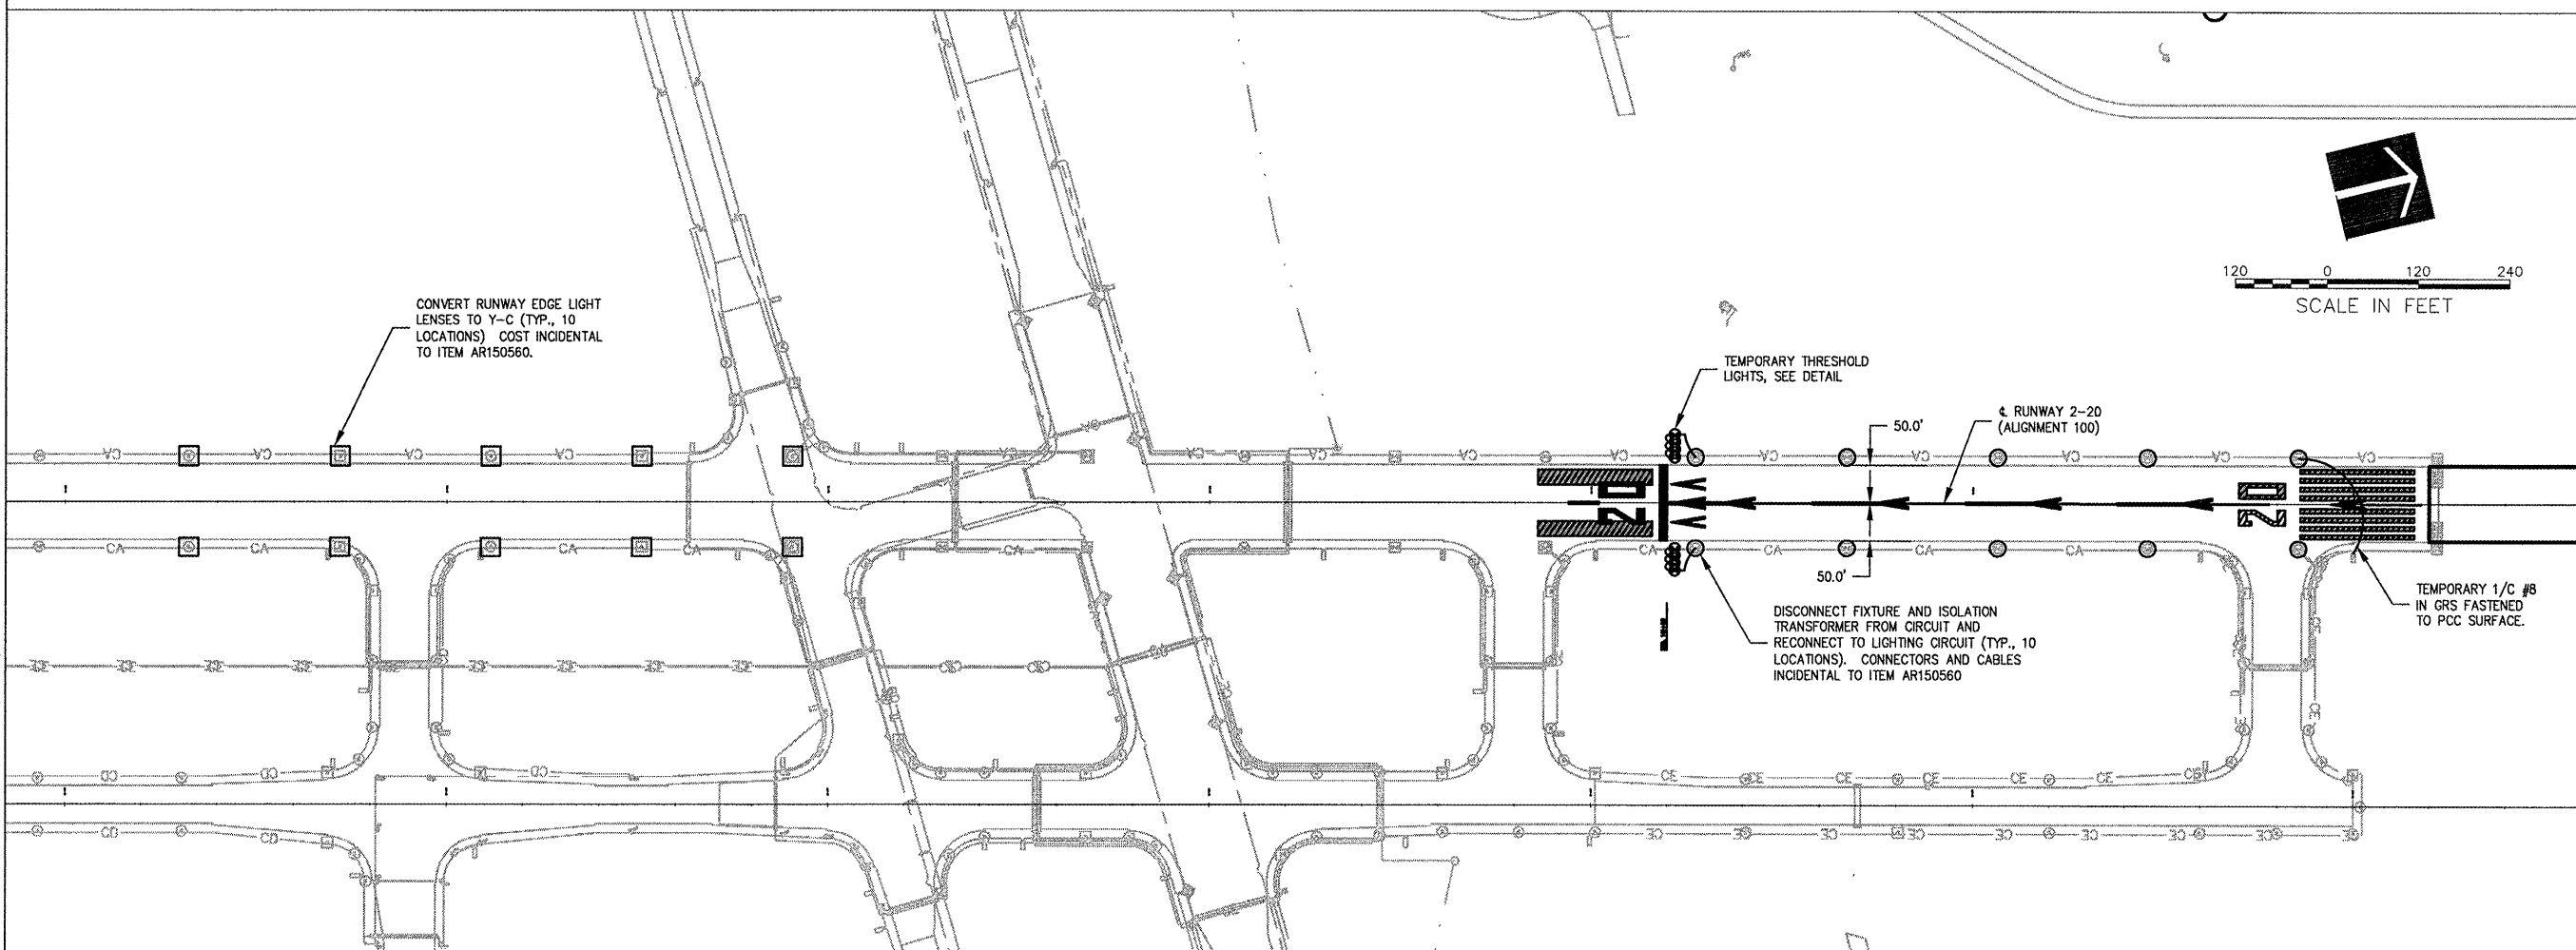

I:\02\0851\08840\07A0166\DRAWINGS\SHEETS\08-TEMPORARY THRESHOLD LIGHTING PLAN\18_APR_18_2008 10:13AM HAUSM0862

No.	Drawing Issue Description	Date	By

Date
APRIL 18, 2008
Sheet Title

TEMPORARY THRESHOLD RUNWAY LIGHTING MODIFICATION PLAN

07A0166
Project Number
LDH 03/14/08
Layout By Date
LDH 03/14/08
Designed By Date
RMH 03/20/08
Reviewed By Date
LDH
Drawn By Sheet No.