



HANSON PROFESSIONAL SERVICES INC.

815 Commerce Drive, Suite 200
Oak Brook, Illinois 60523
Telephone: 630.990.3800
Fax: 630.990.3801

Illinois Professional Design Firm
Registration No. 184-001084

© Copyright Hanson Professional Service Inc. 2008




JOLIET REGIONAL PORT DISTRICT

1 George Michas Drive
Romeoville, Illinois 60446
Telephone: 815.838.9497
Fax: 815.838.9524

EXTEND RUNWAY 2-20: CONSTRUCT
TAXIWAY TURNAROUND

AIP PROJECT NO. 3-17-0140-B42
IDA PROJECT NO. LOT-3792

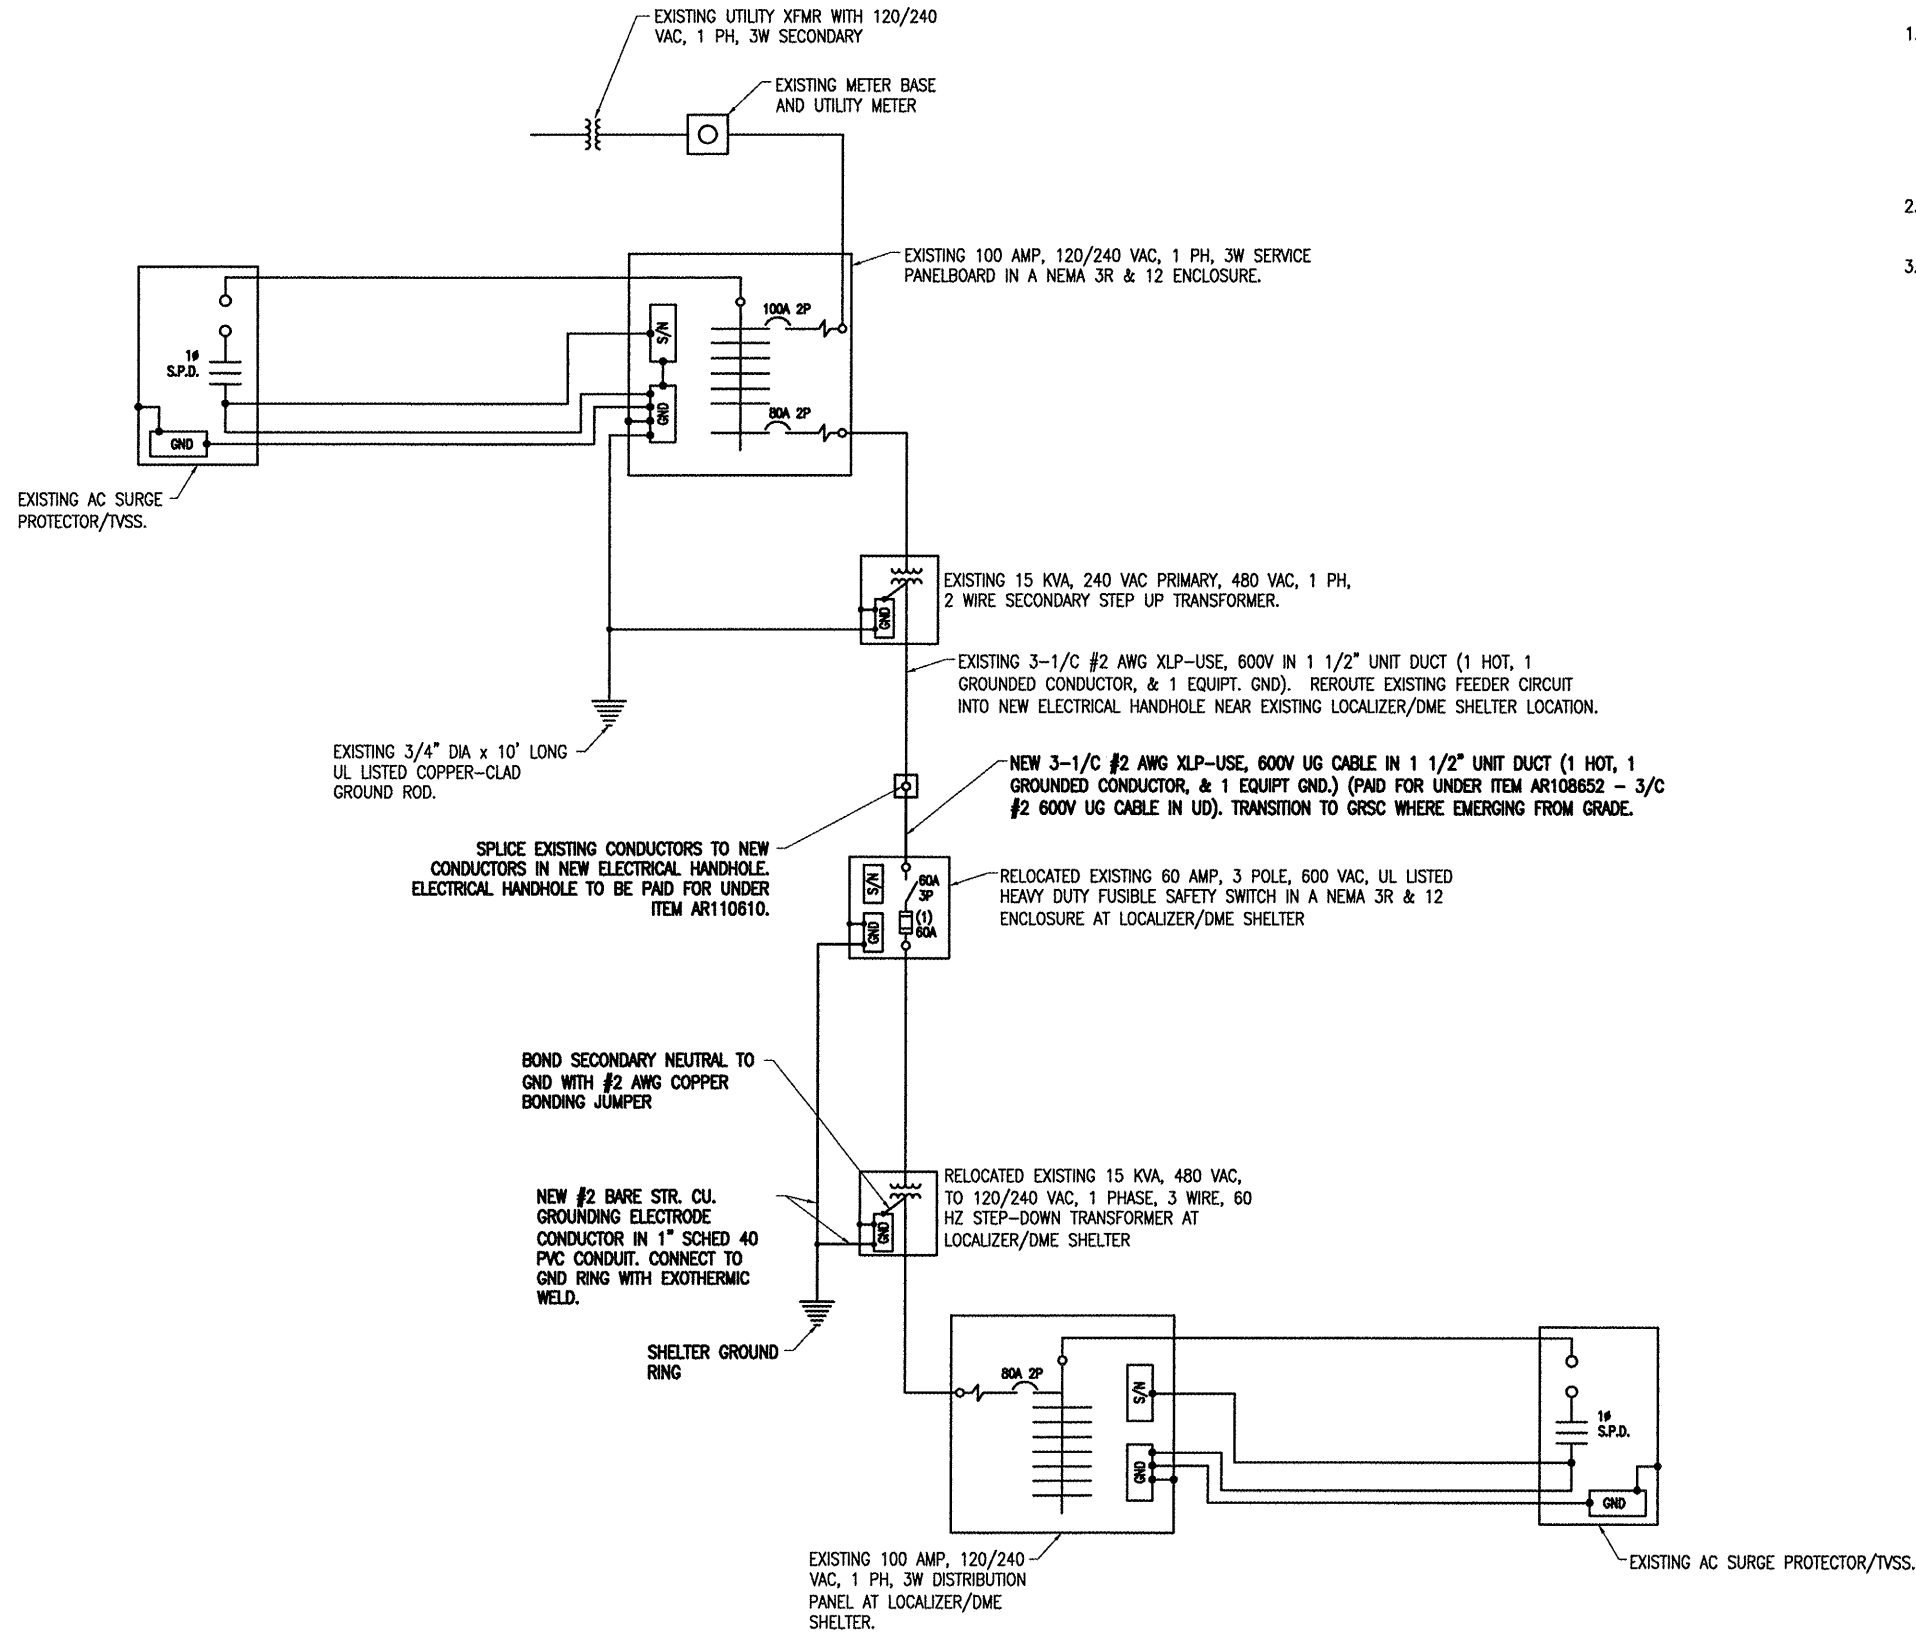

NOTES

- ALL ELECTRICAL EQUIPMENT SHALL BE INSTALLED IN CONFORMANCE WITH NFPA 70 - NATIONAL ELECTRICAL CODE (NEC) MOST CURRENT ISSUE IN FORCE, THE RESPECTIVE EQUIPMENT MANUFACTURER'S DIRECTIONS AND ALL OTHER APPLICABLE LOCAL CODES, LAWS, ORDINANCES AND REQUIREMENTS IN FORCE. ANY INSTALLATIONS WHICH VOID THE U.L. LISTING, ETL LISTING, (OR OTHER THIRD PARTY LISTING) AND/OR THE MANUFACTURER'S WARRANTY OF A DEVICE WILL NOT BE PERMITTED.
- RELOCATION OF LOCALIZER, DME, & LOCALIZER/DME SHELTER WILL BE PAID FOR UNDER ITEM AR127961 RELOACTE LOCALIZER PER LUMP SUM.
- COORDINATE ALL REMOVAL AND RELOCATION WORK WITH THE AIRPORT MANAGER AND THE RESIDENT ENGINEER.

F:\PROJECTS\100840\107A0166\DRAWINGS\SHEETS\75-LOCALIZER ONE-LINE.DWG APR 18, 2008 10:21AM HAUSKOVDBZ

RELOCATE RWY 2 LOCALIZER/DME SHELTER
ELECTRICAL ONE-LINE DIAGRAM

No.	Drawing Issue Description	Date	By

Date
APRIL 18, 2008
Sheet Title

RELOCATE RUNWAY 2
LOCALIZER/DME
ELECTRICAL ONE-LINE

07A0166
Project Number
KNL 03/15/08
Layout By Date
KNL 03/15/08
Designed By Date
RMH 03/20/08
Reviewed By Date
LDH --- ---
Drawn By Sheet No.