
 


MATCHLINE STA. 751+00

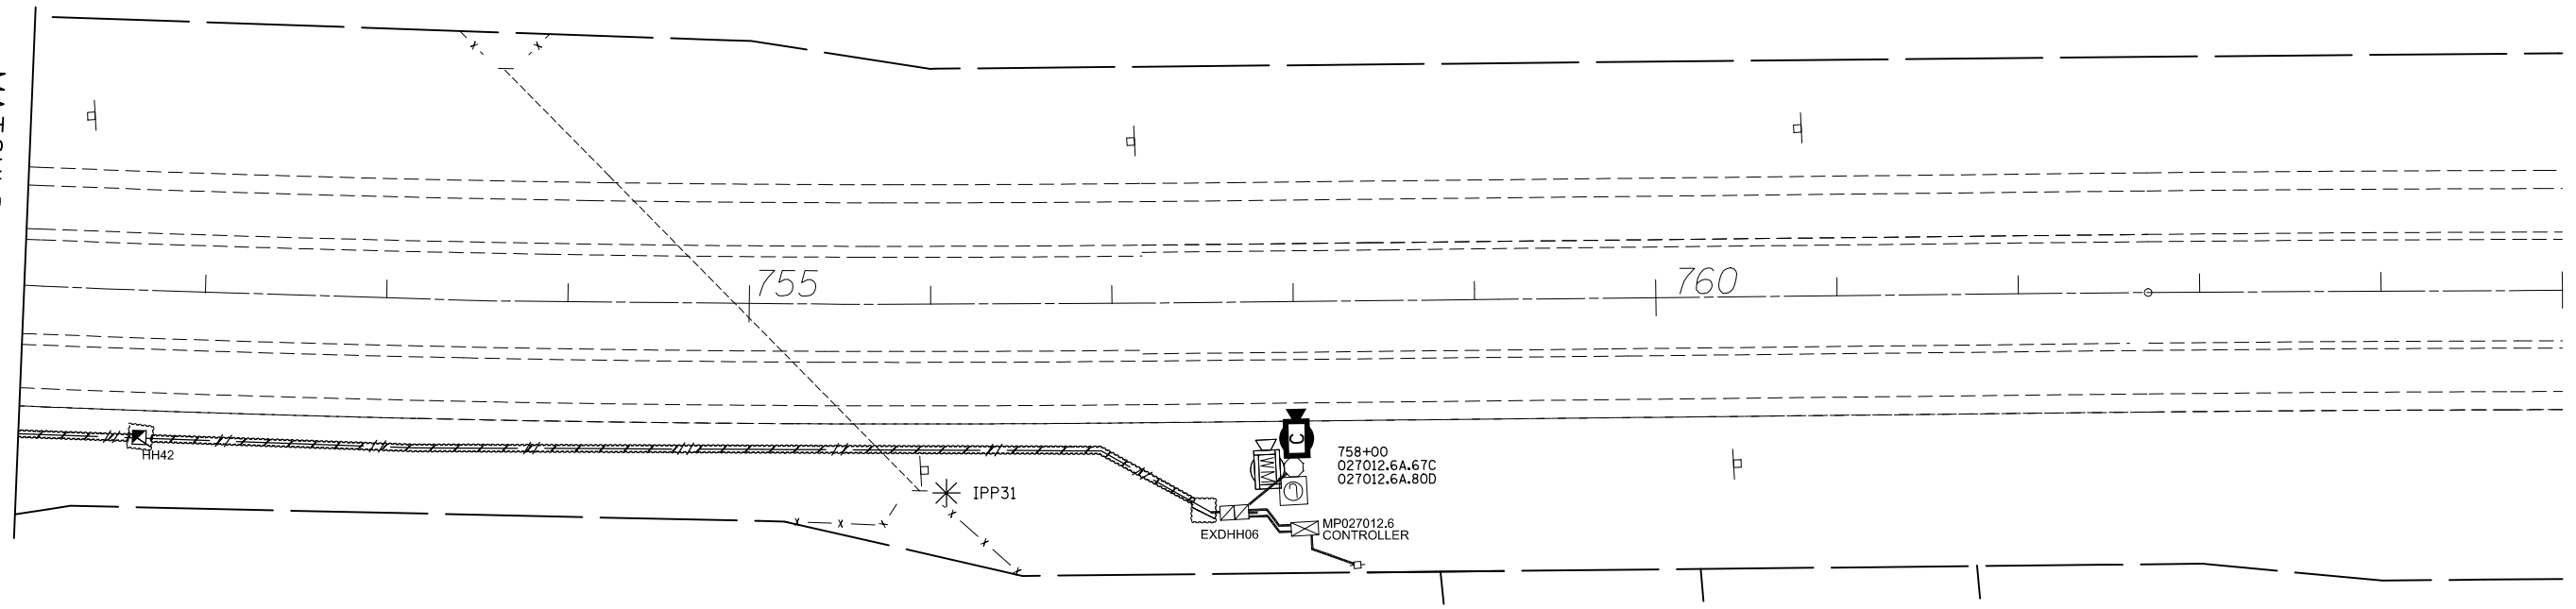

* SEE INLET AND PIPE PROTECTION INSTALLATION GENERAL NOTE

WB I-270
 STA. 751+00 TO
 STA. 765+00
 SHEET 11A OF 11



FILE NAME =	USER NAME = prestonme	DESIGNED -	REVISED -
et:\pwork\pwork\prestonme\d0355968\d076995-sht-ITS.dgn		DRAWN -	REVISED -
	PLOT SCALE = 100.0000' / 1in.	CHECKED -	REVISED -
	PLOT DATE = 3/20/2014	DATE -	REVISED -

**STATE OF ILLINOIS
 DEPARTMENT OF TRANSPORTATION**

EROSION CONTROL PLAN 11A OF 11

SCALE:	SHEET NO.	OF	SHEETS	STA.	TO STA.
--------	-----------	----	--------	------	---------

F.A.I. RTE.	SECTION	COUNTY	TOTAL SHEETS	SHEET NO.
270	DIST 8 ITS 2014-2	MADISON	37	32
CONTRACT NO. 76C95				
FED. ROAD DIST. NO. ILLINOIS FED. AID PROJECT				