


**PLAN
EXISTING**

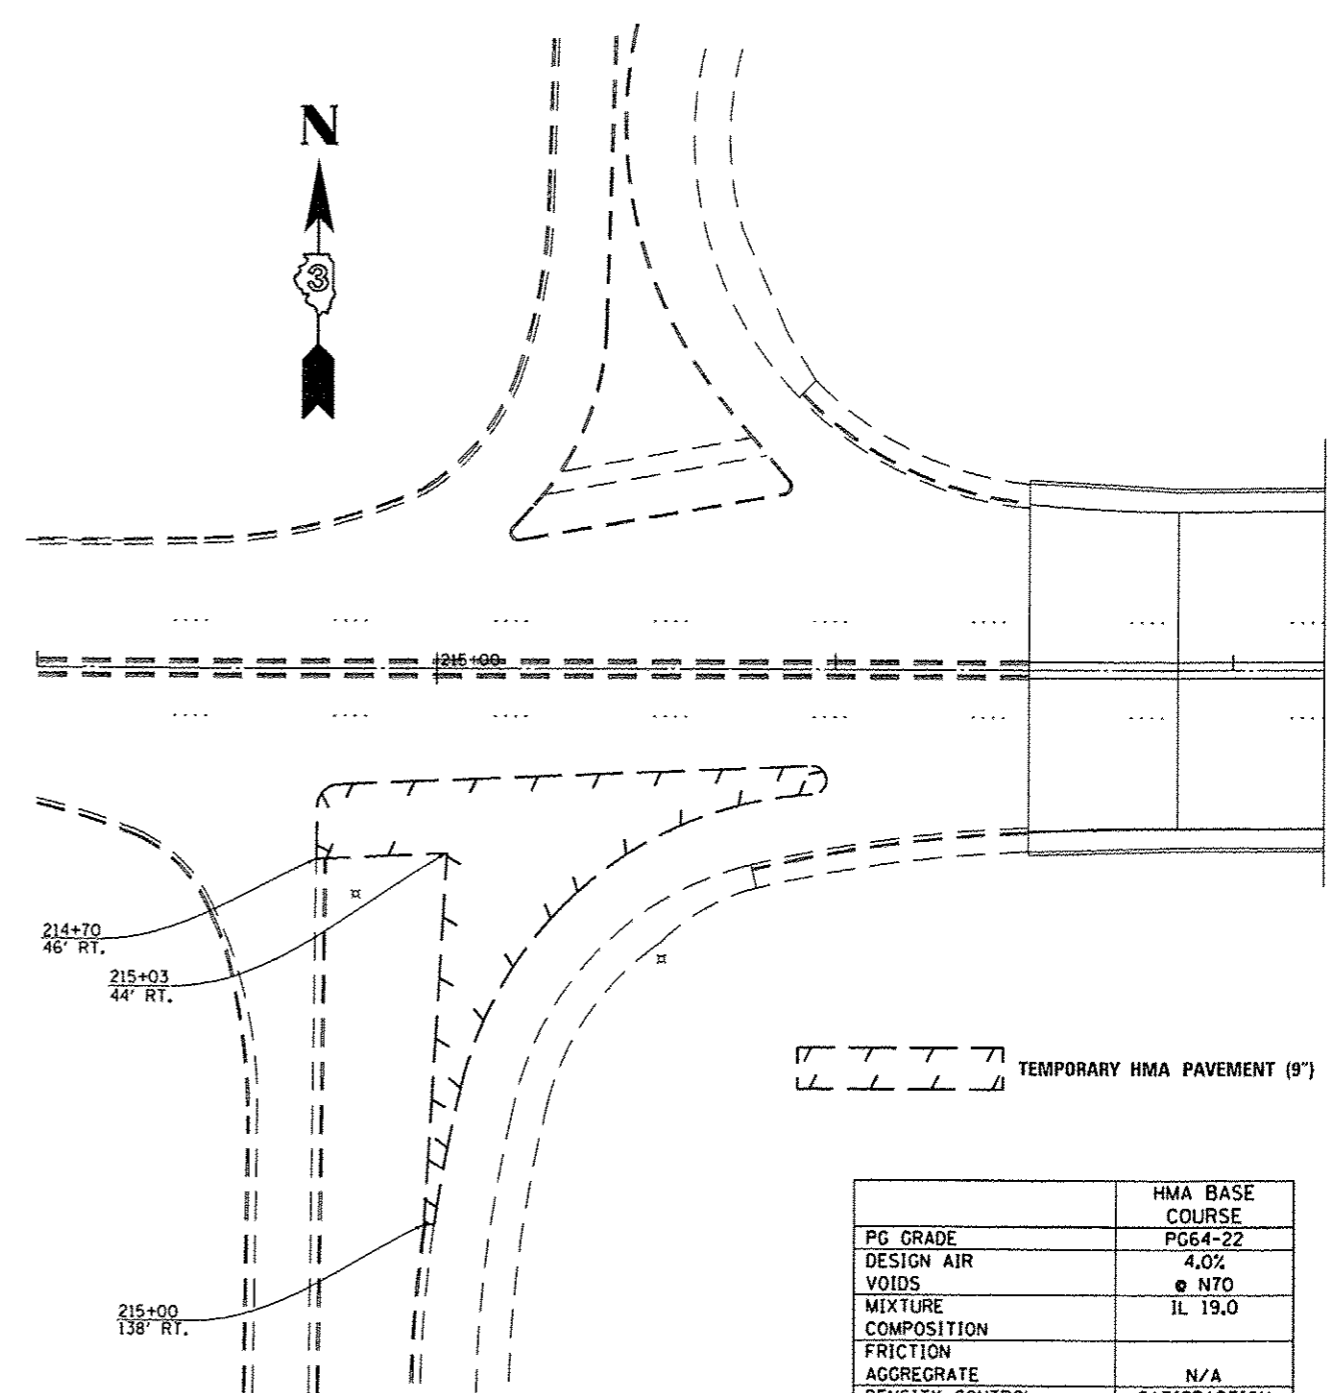

**PLAN
PROPOSED**

SEQUENCE OF OPERATIONS

STAGE I CONSTRUCTION

1. REMOVE EXISTING COMBINATION CONCRETE CURB AND GUTTER TYPE B9.24
2. REMOVE EXISTING PCC SIDEWALK, 5' WIDTH, 4" DEPTH
3. REMOVE EXISTING SOILS TO AN ELEVATION 9" BELOW EXISTING PAVEMENT ELEVATION
4. PLACE TEMPORARY HOT-MIX ASPHALT PAVEMENT 9"

HMA BASE COURSE	
PG GRADE	PG64-22
DESIGN AIR VOIDS	4.0%
MIXTURE COMPOSITION	IL 19.0
FRICTION AGGREGATE	N/A
DENSITY CONTROL METHOD	SATISFACTION OF ENGINEER

GENERAL NOTES

WHENEVER ANY VEHICLE, EQUIPMENT, WORKERS OR THEIR ACTIVITIES ENCROACH ON THE MAINLINE PAVEMENT REQUIRING THE CLOSURE OF ONE OR MORE TRAFFIC LANES IN AN URBAN AREA TRAFFIC CONTROL AND PROTECTION SHALL BE ACCORDING TO TRAFFIC CONTROL AND PROTECTION STANDARD 701601.

WHENEVER ANY VEHICLE, EQUIPMENT, WORKERS OR THEIR ACTIVITIES ENCROACH ON THE RAMP PAVEMENT REQUIRING THE RESTRICTION OF THE RAMP LANE IN AN URBAN AREA TRAFFIC CONTROL AND PROTECTION SHALL BE ACCORDING TO TRAFFIC CONTROL AND PROTECTION STANDARD 701456.

FILE NAME *	USER NAME = petelyj	DESIGNED - RW	REVISED -
o:\pwork\pedit\petelyj\0332461\0366008-shd-details.dgn		DRAWN - RW	REVISED -
	PLOT SCALE * 1/8"=1'-0"	CHECKED -	REVISED -
	PLOT DATE * 4/3/2013	DATE -	REVISED -

**STATE OF ILLINOIS
DEPARTMENT OF TRANSPORTATION**

STAGE I CONSTRUCTION DETAILS	
SCALE: 1/8"=1'-0"	SHEET NO. 1 OF 1 SHEETS
STA.	TO STA.

F.A.P. RTE.	SECTION	COUNTY	TOTAL SHEETS	SHEET NO.
623	(IHR)I-2	LASALLE	11	5
CONTRACT NO. 66C80				
ILLINOIS FED. AID PROJECT				