


**PLAN
PROPOSED**


SEQUENCE OF OPERATIONS

STAGE IV CONSTRUCTION


1. REMOVE TEMPORARY HOT-MIX ASPHALT PAVEMENT
2. CONSTRUCT COMBINATION CONCRETE CURB AND GUTTER TYPE B9.24
3. CONSTRUCT PORTLAND CEMENT CONCRETE SIDEWALK, 4"
4. PLACE SUITABLE EXCAVATED MATERIALS
5. PLACE FERTILIZER AND SOD.

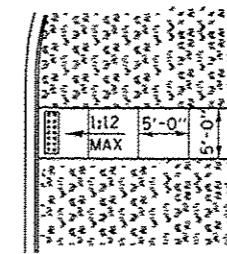


DETAIL A

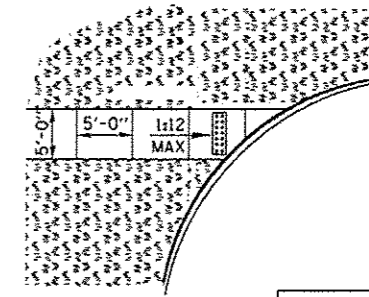


LEGEND	
	PLANTING OR OTHER NON-WALKING SURFACE
	DETECTABLE WARNING

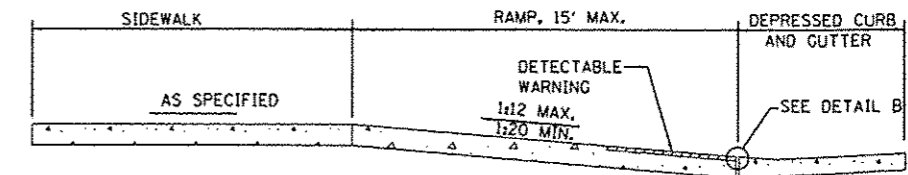

SECTION B-B

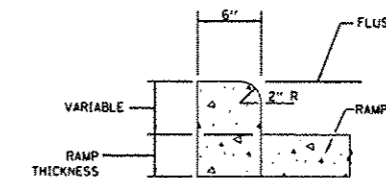

SIDE CURB DETAIL

 

DETAIL B

GENERAL NOTES

THIS STANDARD IS USED WHERE AT ANY TIME, DAY OR NIGHT, ANY VEHICLE, EQUIPMENT, WORKERS OR THEIR ACTIVITIES ENCR OACH ON THE PAVEMENT REQUIRING THE CLOSURE OF ONE OR MORE TRAFFIC LANES IN AN URBAN AREA.

TRAFFIC CONTROL AND PROTECTION FOR STAGE I CONSTRUCTION OPERATIONS SHALL BE ACCORDING TO TRAFFIC CONTROL AND PROTECTION, STANDARD 701201 AND AS DIRECTED BY THE ENGINEER.

FILE NAME =	USER NAME = petelyj	DESIGNED - RW	REVISED -	STATE OF ILLINOIS DEPARTMENT OF TRANSPORTATION	STAGE IV CONSTRUCTION DETAILS	F.A.P. RTE.	SECTION	COUNTY	TOTAL SHEETS	SHEET NO.
c:\pwwork\pedit\petelyj\0332461\036608-shd-detail.dgn	DRAWN - RW	REVISED -	623			(1HBR)1-2	LASALLE	11	8	
PLOT SCALE = 1/8" = 1'-0"	CHECKED -	REVISED -	CONTRACT NO. 66C80							
PLOT DATE = 4/3/2013	DATE -	REVISED -	ILLINOIS FED. AID PROJECT							
				SCALE:	SHEET NO. 1 OF 1 SHEETS	STA.	TO STA.			