


GENERAL NOTE

SEE STANDARD 606301 FOR DETAILS OF TYPE SM MEDIAN NOT SHOWN.

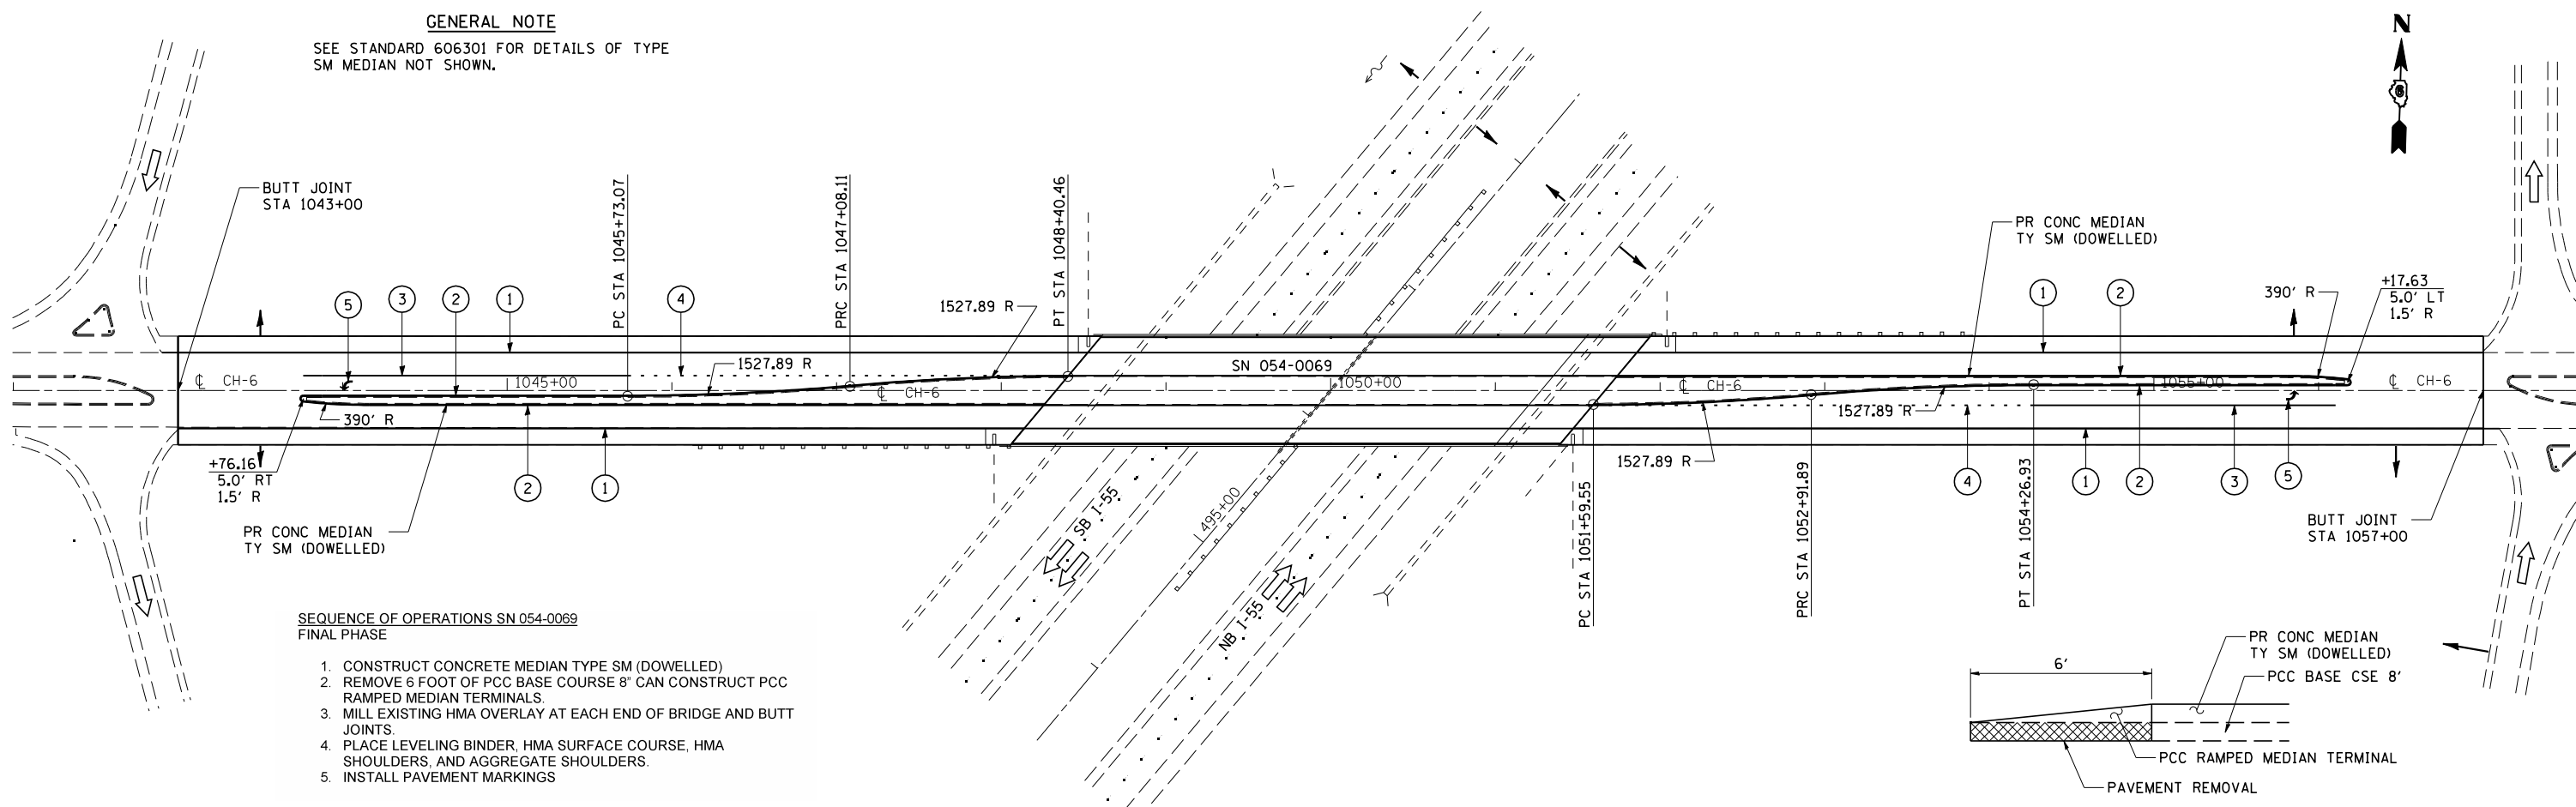

SEQUENCE OF OPERATIONS SN 054-0069
FINAL PHASE



1. CONSTRUCT CONCRETE MEDIAN TYPE SM (DOWELLED)
2. REMOVE 6 FOOT OF PCC BASE COURSE 8" CAN CONSTRUCT PCC RAMPED MEDIAN TERMINALS
3. MILL EXISTING HMA OVERLAY AT EACH END OF BRIDGE AND BUTT JOINTS
4. PLACE LEVELING BINDER, HMA SURFACE COURSE, HMA SHOULDERS, AND AGGREGATE SHOULDERS
5. INSTALL PAVEMENT MARKINGS

LEGEND




- ① PAINT PAVEMENT MARKING - LINE 5" (SOLID WHITE)
- ② PAINT PAVEMENT MARKING - LINE 5" (SOLID YELLOW)
- ③ PAINT PAVEMENT MARKING - LINE 6" (SOLID WHITE)
- ④ PAINT PAVEMENT MARKING - LINE 6" (WHITE 2' DASH, 6' SKIP)
- ⑤ PAINT PAVEMENT MARKING - LINE LETTERS AND SYMBOLS

OFFSETS TO FACE OF MEDIAN		
STA	LEFT	RIGHT
1044+00	3.50	8.50
+16.07	3.50	8.50
+25	3.50	8.50
+50	3.50	8.50
+75	3.50	8.50
1045+00	3.50	8.50
+25	3.50	8.50
+50	3.50	8.50
+73.07	3.50	8.50
+75	3.49	8.50
1046+00	3.26	8.50
+25	2.61	8.50
+50	1.55	8.50
+75	0.08	8.50
1047+00	-1.80	8.50
+08.11	-2.50	8.50
+25	-3.91	8.50
+50	-5.65	8.50
+75	-6.97	8.50
1048+00	-7.88	8.50
+25	-8.39	8.50
+40.46	-8.50	8.50

OFFSETS TO FACE OF MEDIAN		
STA	LEFT	RIGHT
+59.55		8.50
+75	-8.50	8.39
1052+00	-8.50	7.88
+25	-8.50	6.97
+50	-8.50	5.64
+75	-8.50	3.91
+91.89	-8.50	2.50
1053+00	-8.50	1.80
+25	-8.50	-0.08
+50	-8.50	-1.55
+75	-8.50	-2.61
1054+00	-8.50	-3.26
+25	-8.50	-3.50
+26.93	-8.50	-3.50
+50	-8.50	-3.50
+75	-8.50	-3.50
1055+00	-8.50	-3.50
+25	-8.50	-3.50
+50	-8.50	-3.50
+75	-8.50	-3.50
+80.94	-8.50	-3.50
1056+00	-7.95	-3.50
+17.63	-6.50	-3.50

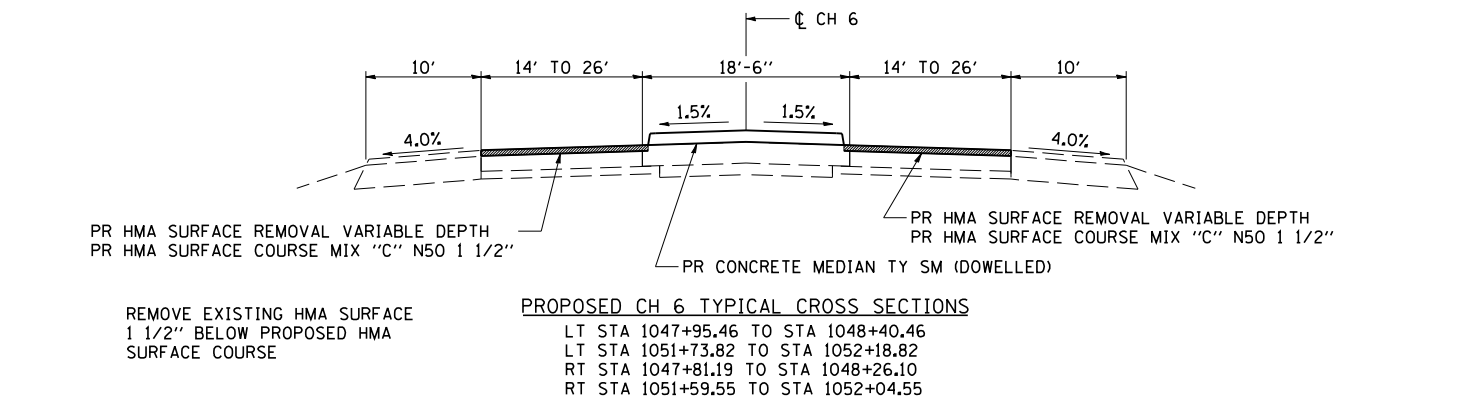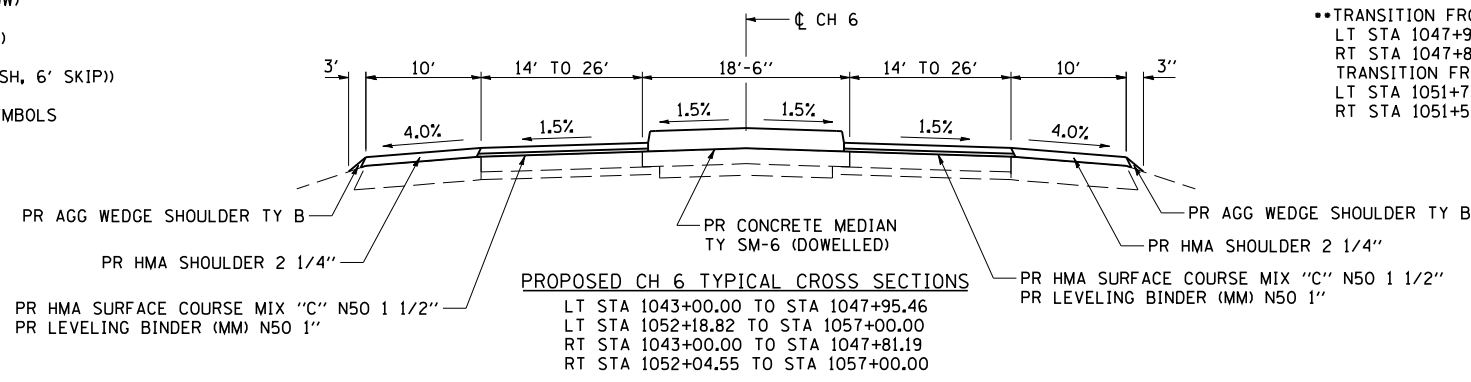

••TRANSITION FROM 2 1/4" TO 0" IN 45'
LT STA 1047+95.46 TO STA 1048+40.46
RT STA 1047+81.19 TO STA 1048+26.10
TRANSITION FROM 0" TO 2 1/4" IN 45'
LT STA 1051+73.82 TO STA 1052+18.82
RT STA 1051+59.55 TO STA 1052+04.55

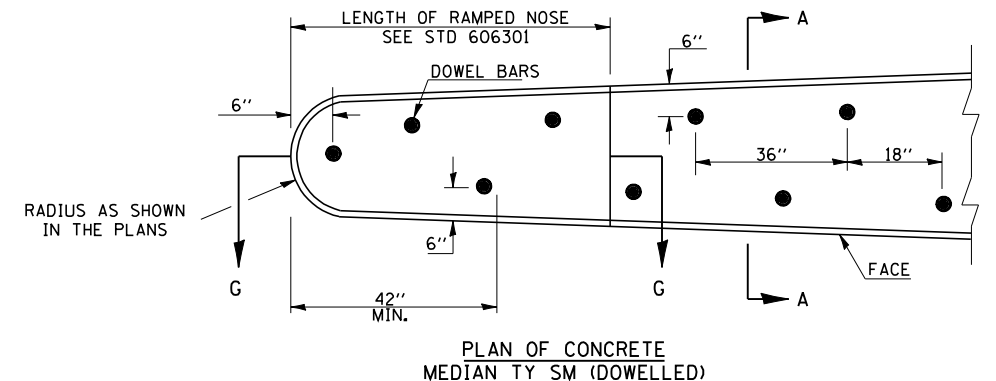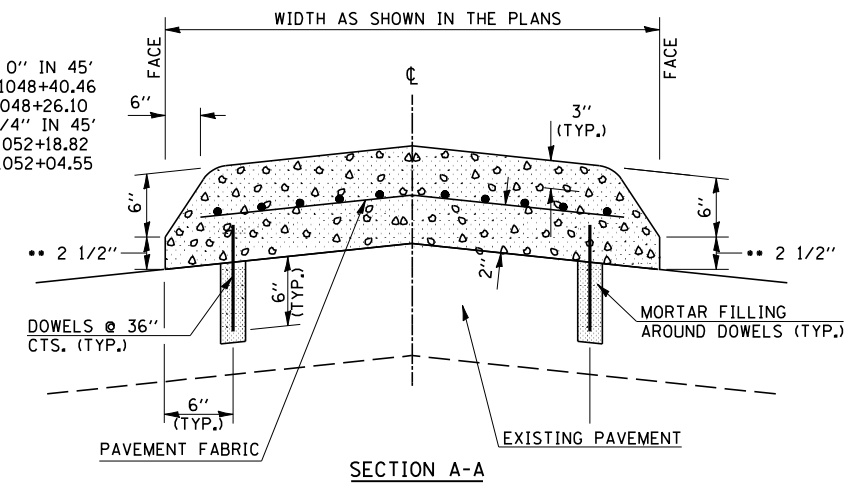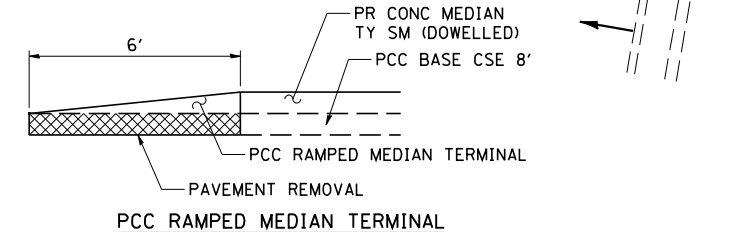

JOB = 2236.10
FILE NAME = D672E11-sh1-S3-0069.dgn
PLOT SCALE = 100.0000 ' / IN.
PLOT DATE = 3/18/2013

DESIGNED -
DRAWN -
CHECKED -
DATE -

REVISED -
REVISED -
REVISED -
REVISED -

STATE OF ILLINOIS
DEPARTMENT OF TRANSPORTATION

FINAL PHASE SN 054-0069

SCALE: SHEET NO. OF SHEETS STA. TO STA.

F.A.I. RTE.	SECTION	COUNTY	TOTAL SHEETS	SHEET NO.
55	D6 LOGAN CO BR 2011-1	LOGAN	429	177
CONTRACT NO. 72E11				
FED. ROAD DIST. NO. ILLINOIS FED. AID PROJECT				