


PLAN	SURVEYED	BY	DATE
	PLOTTED		
	ALIGNED		
	CHECKED		
	FILED		
	NO. _____		
	NO. _____		
	NO. _____		


PROFILE	SURVEYED	BY	DATE
	PLOTTED		
	GRADES		
	CHECKED		
	STRUCTURE		
	NOTATIONS		
	CHKD		
	NO. _____		
	NO. _____		
	NO. _____		

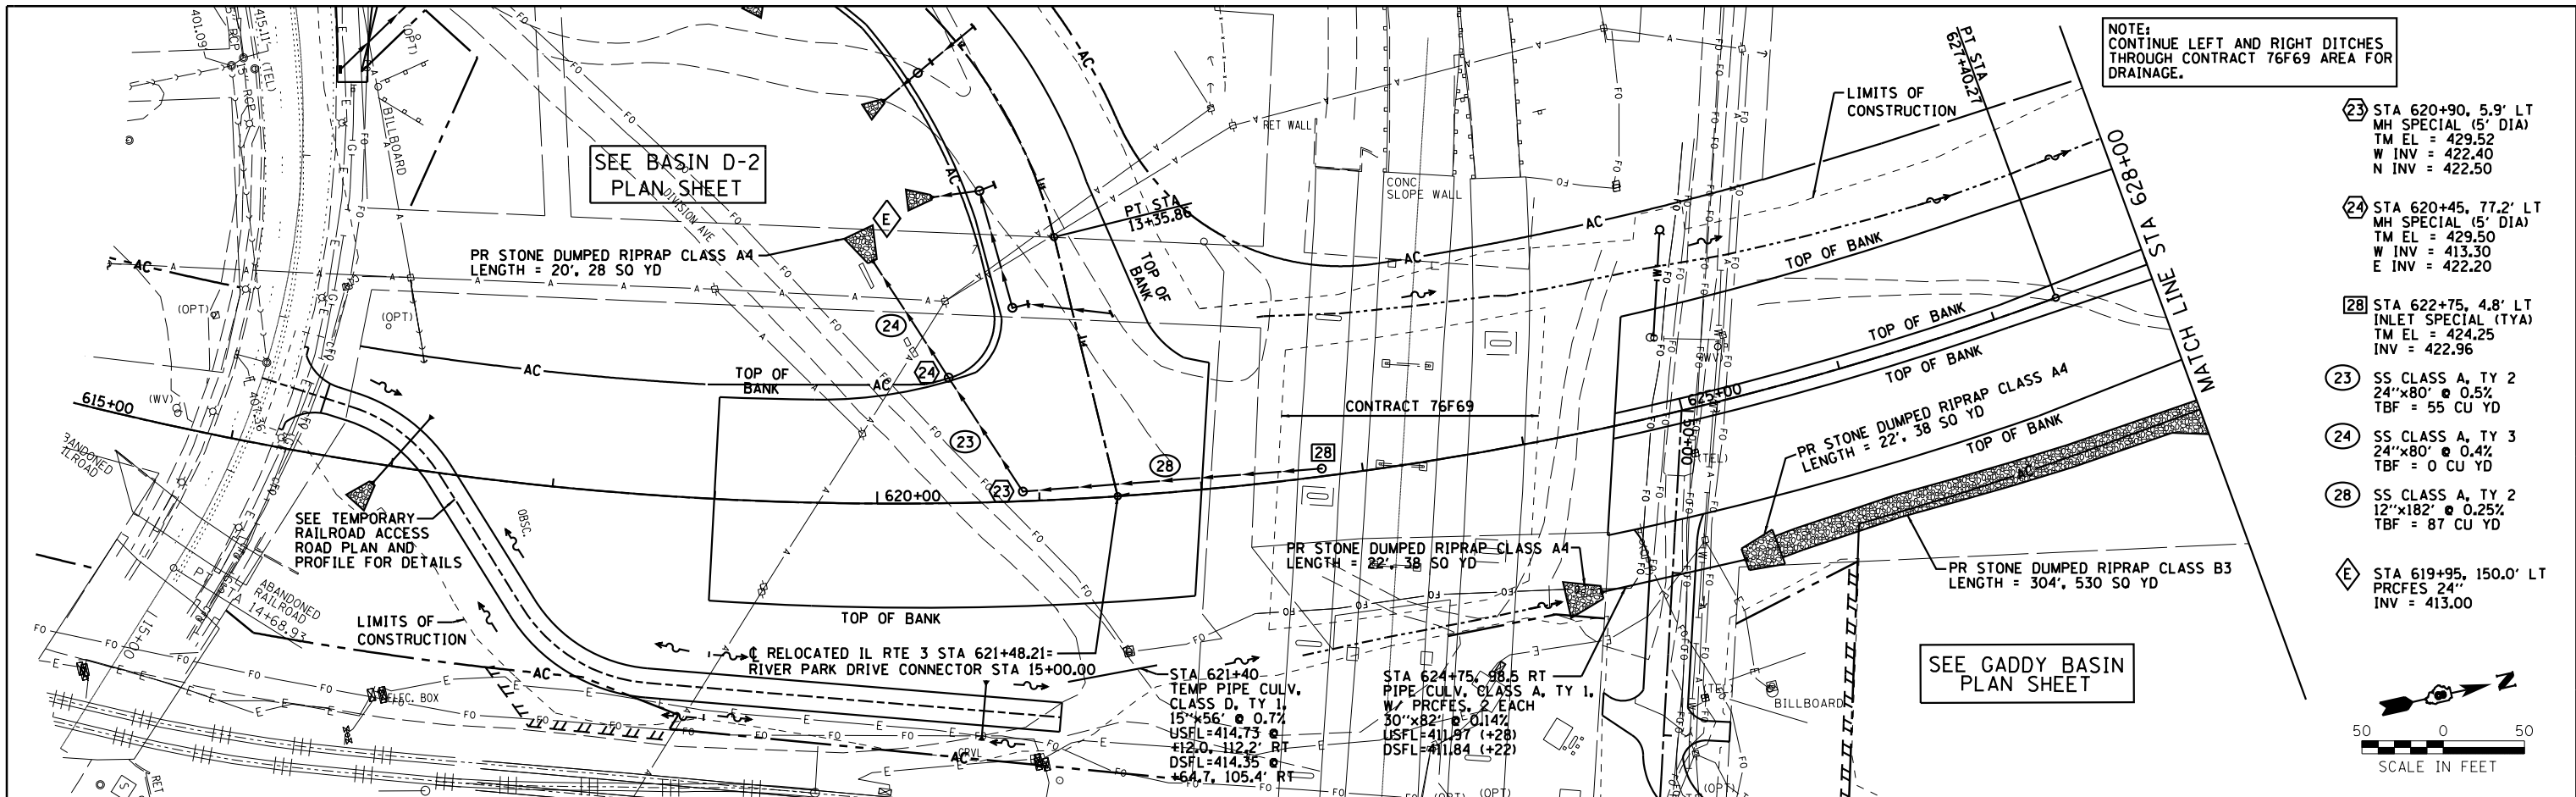

NOTE: CONTINUE LEFT AND RIGHT DITCHES THROUGH CONTRACT 76F69 AREA FOR DRAINAGE.

- 23 STA 620+90, 5.9' LT MH SPECIAL (5' DIA)  
TM EL = 429.52  
W INV = 422.40  
N INV = 422.50
- 24 STA 620+45, 77.2' LT MH SPECIAL (5' DIA)  
TM EL = 429.50  
W INV = 413.30  
E INV = 422.20
- 28 STA 622+75, 4.8' LT INLET SPECIAL (TYA)  
TM EL = 424.25  
INV = 422.96
- 23 SS CLASS A, TY 2  
24"x80" @ 0.5%  
TBF = 55 CU YD
- 24 SS CLASS A, TY 3  
24"x80" @ 0.4%  
TBF = 0 CU YD
- 28 SS CLASS A, TY 2  
12"x182" @ 0.25%  
TBF = 87 CU YD
- E STA 619+95, 150.0' LT PRCFES 24"  
INV = 413.00

NOTE: CONTINUE LEFT AND RIGHT DITCHES THROUGH CONTRACT 76F69 AREA FOR DRAINAGE.  
FOR CLARITY NOT ALL STORM SEWER SYSTEM IS SHOWN IN PROFILE.

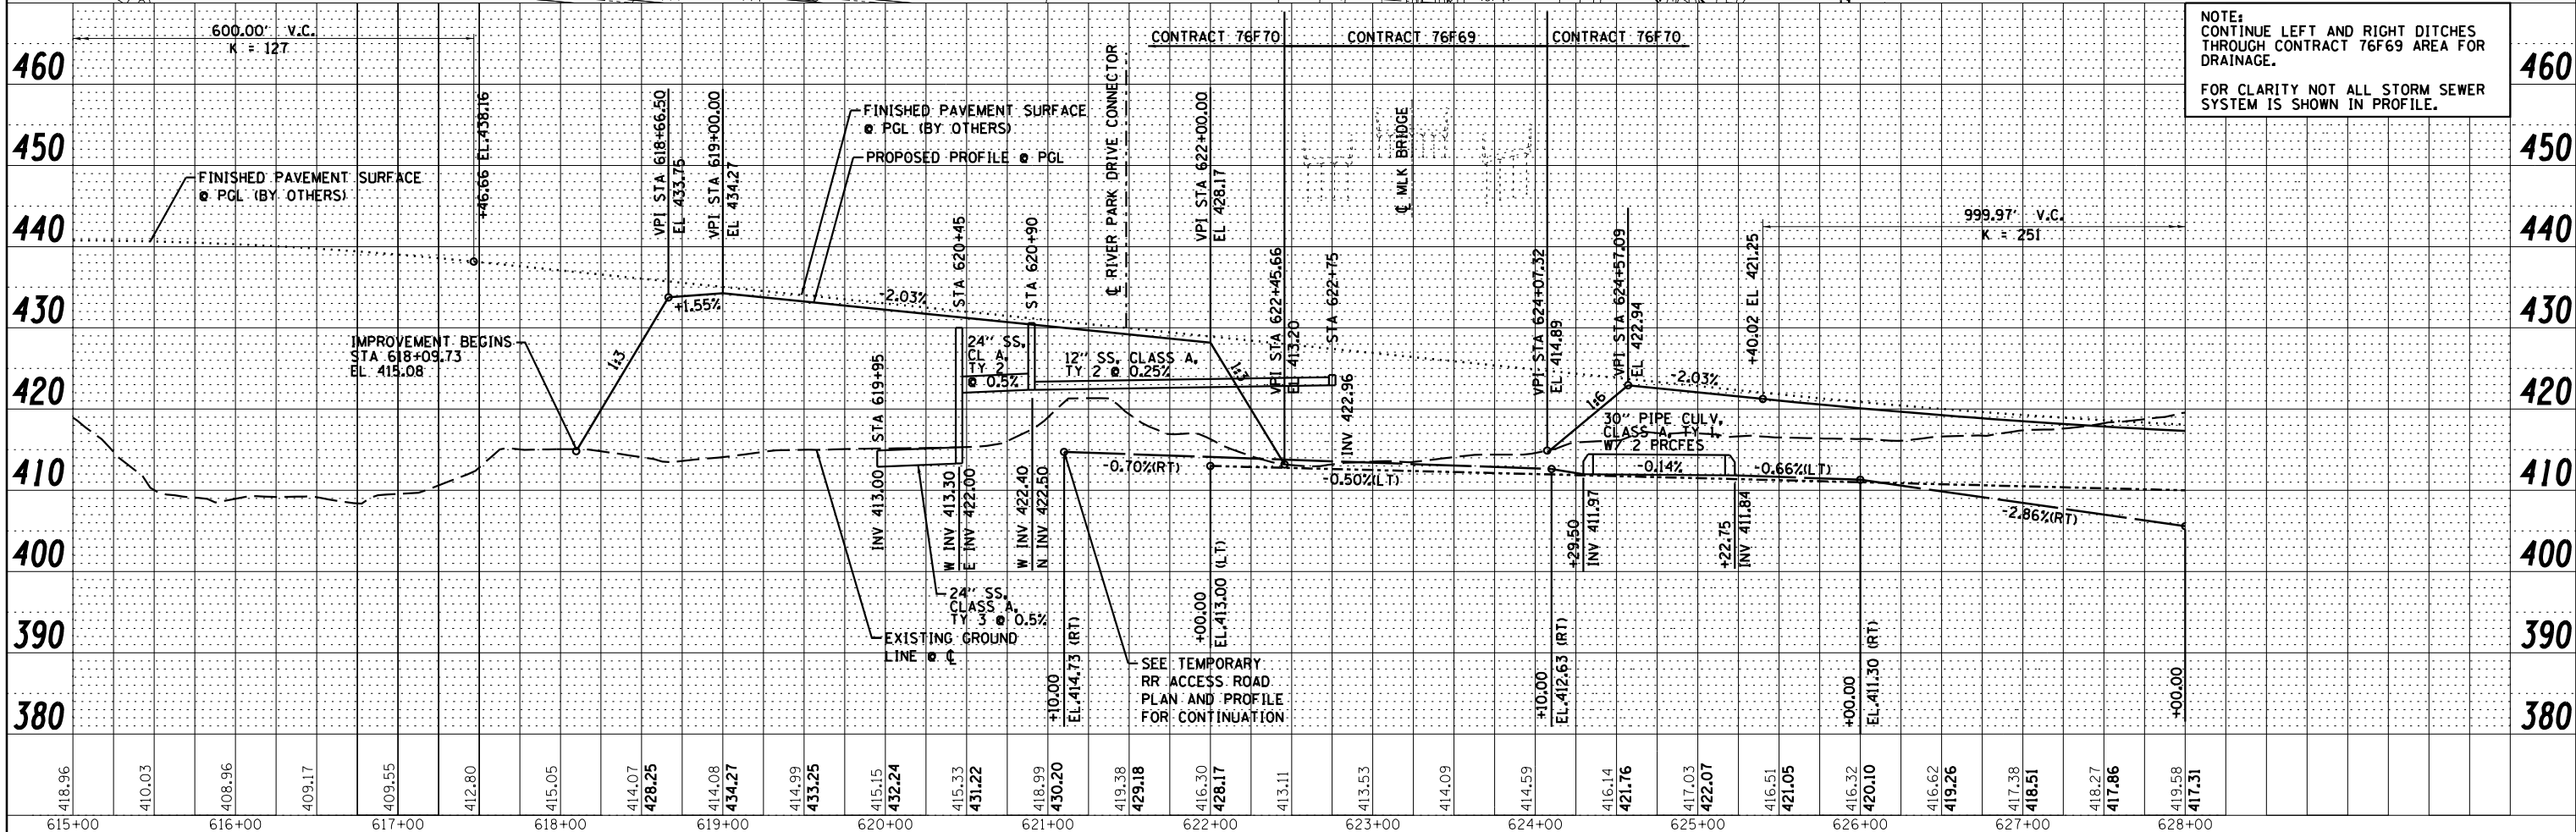

<p>Farnsworth GROUP, INC. 2705 McGraw Drive Bloomington, Illinois 61704 309/663-8435, 309/663-1571 fax</p>	USER NAME = dmeyer PLOT SCALE = 100.0000' / 1"	DESIGNED - JJO DRAWN - JJO CHECKED - PJM DATE - 10/18/12	REVISED - 02/06/13 REVISED - 03/18/13 REVISED - REVISED -	<b>STATE OF ILLINOIS DEPARTMENT OF TRANSPORTATION</b>	<b>RELOCATED IL RTE 3 DRAINAGE PLAN &amp; PROFILE</b>	F.A.P. R.T.E. = 788 SECTION = 520-1-2-1 COUNTY = ST. CLAIR TOTAL SHEETS = 121 SHEET NO. = 26 CONTRACT NO. = 76F70	SCALE: _____ SHEET NO. _____ OF _____ SHEETS STA. _____ TO STA. _____	ILLINOIS FED. AID PROJECT
	PP-1							