
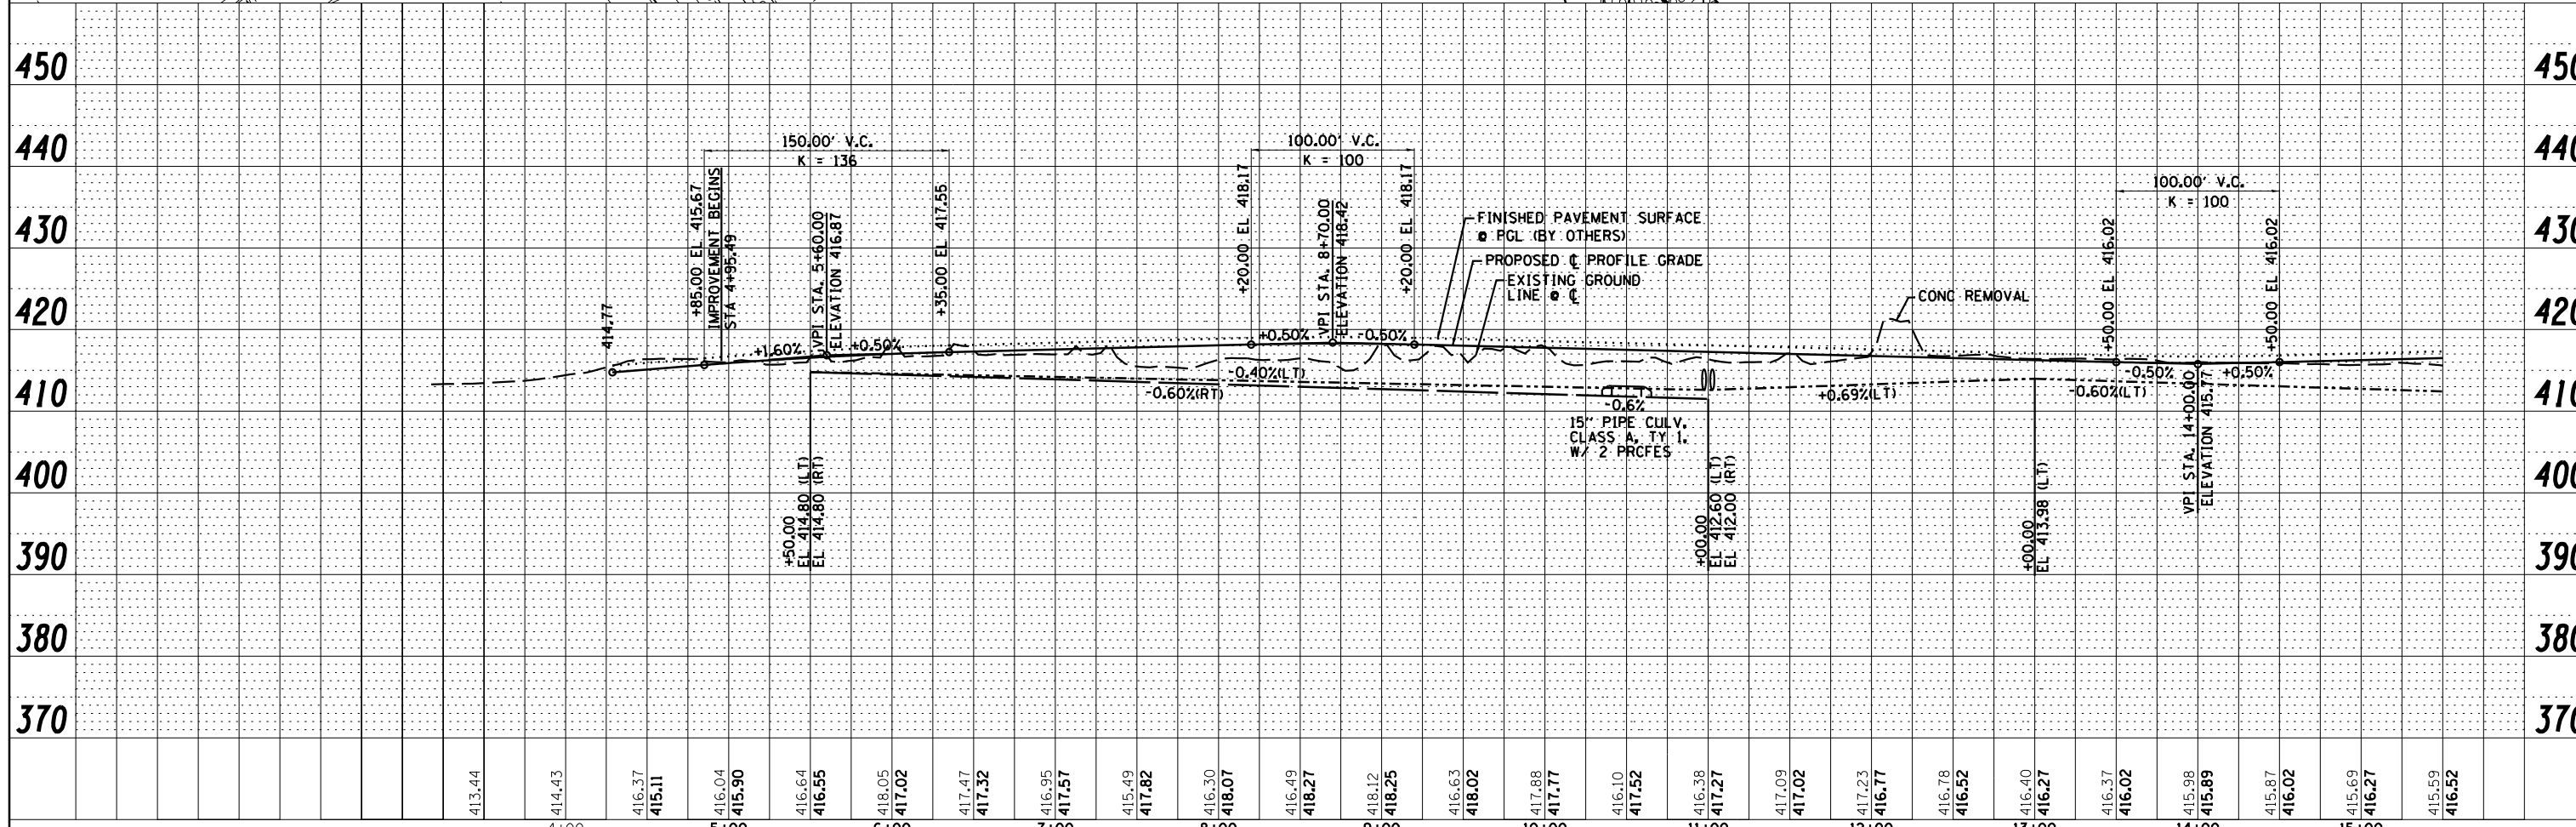
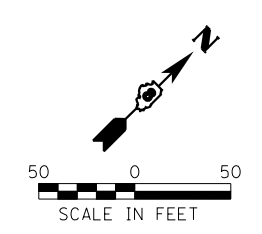


PLAN	SURVEYED	DATE
	PLOTTED	BY
	ALIGNED	CHECKED
	NOTE BOOK	NO.
	FILE NAME	

PROFILE	SURVEYED	DATE
	PLOTTED	BY
	GRADES CHECKED	CHECKED
	STRUCTURE	NOTATRS CHFD
	NO.	

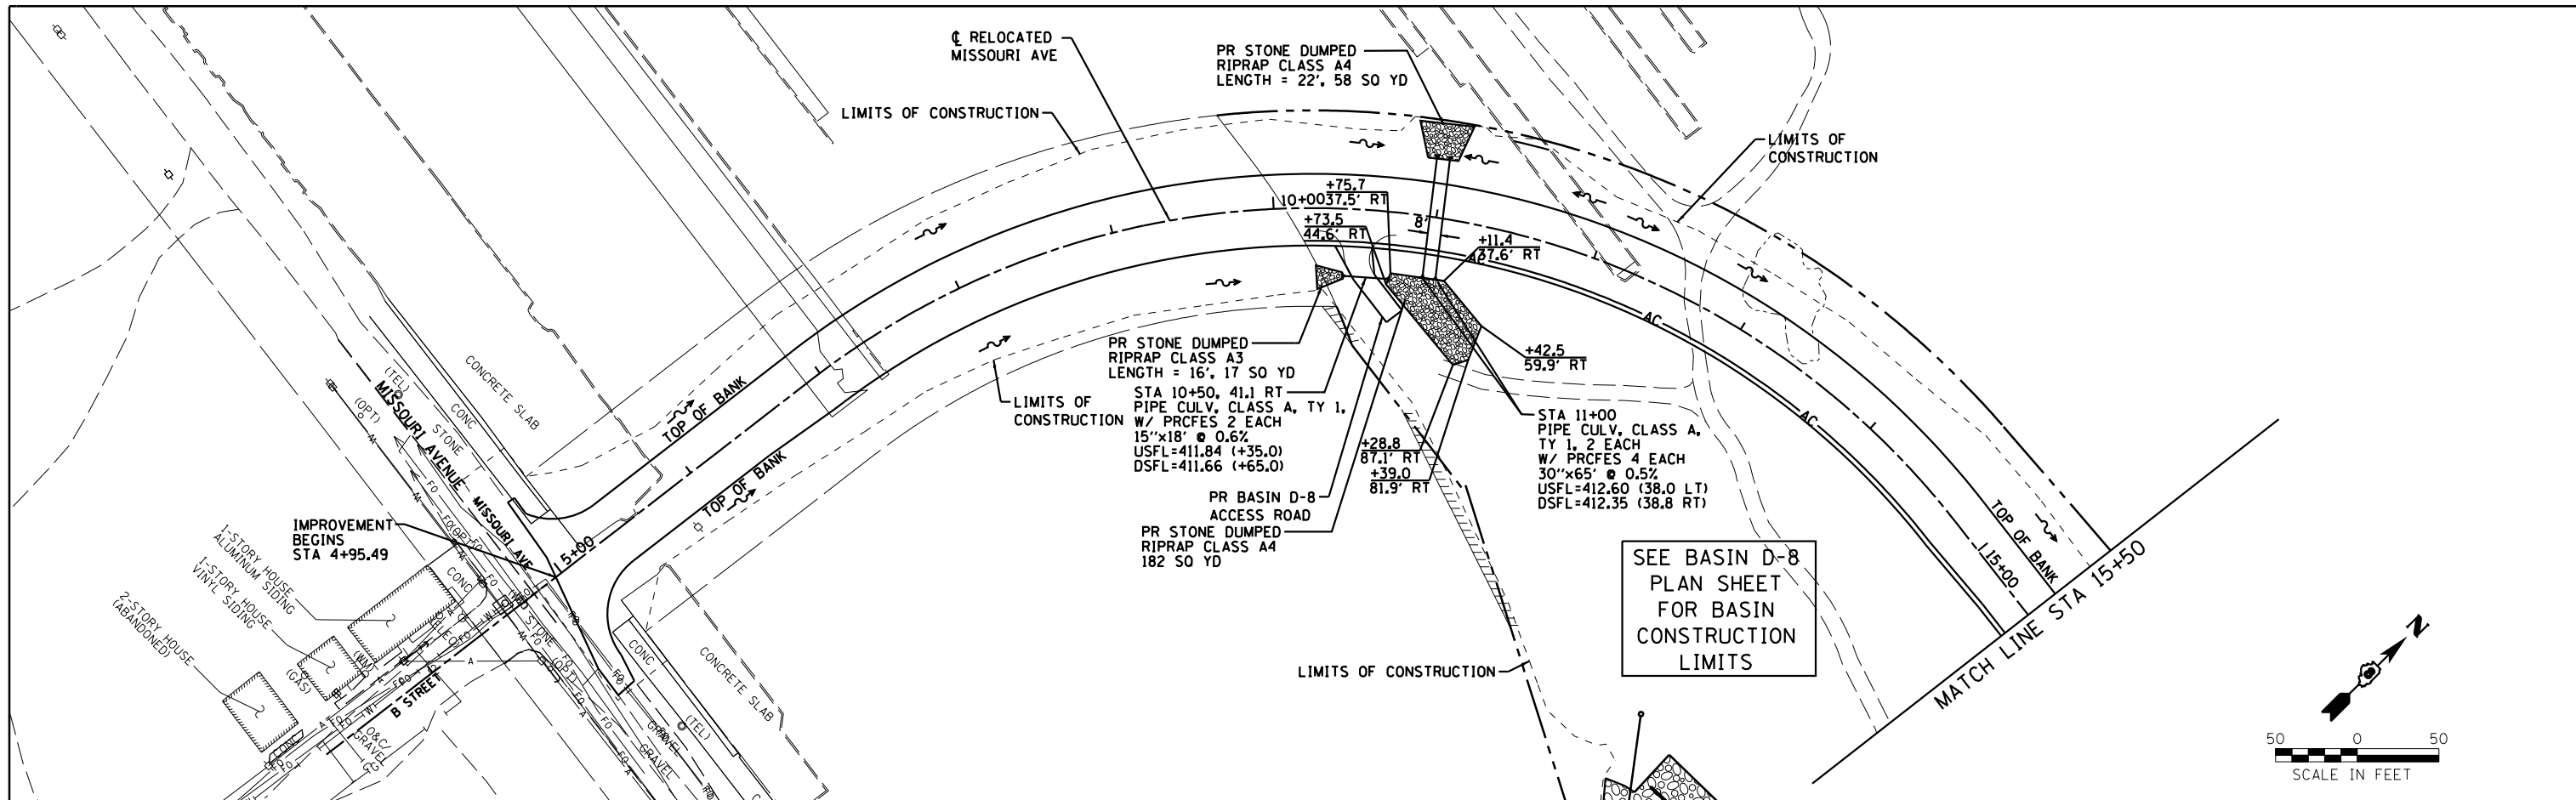

Farnsworth GROUP, INC.
 2709 McGraw Drive
 Bloomington, Illinois 61704
 309/663-8435, 309/663-1571 fax

USER NAME = dmeyer	DESIGNED - JJO	REVISED - 02/06/13
	DRAWN - JJO	REVISED - 03/18/13
PLOT SCALE = 100.000' / in.	CHECKED - PJM	REVISED -
PLOT DATE = 3/18/2013	DATE - 10/18/12	REVISED -

STATE OF ILLINOIS
DEPARTMENT OF TRANSPORTATION

RELOCATED MISSOURI AVENUE DRAINAGE PLAN & PROFILE			
SCALE:	SHEET NO.	OF SHEETS	STA. TO STA.

F.A.P. RTE. 788	SECTION 520-1-2-1	COUNTY ST. CLAIR	TOTAL SHEETS 121	SHEET NO. 30
CONTRACT NO. 76F70				ILLINOIS FED. AID PROJECT