
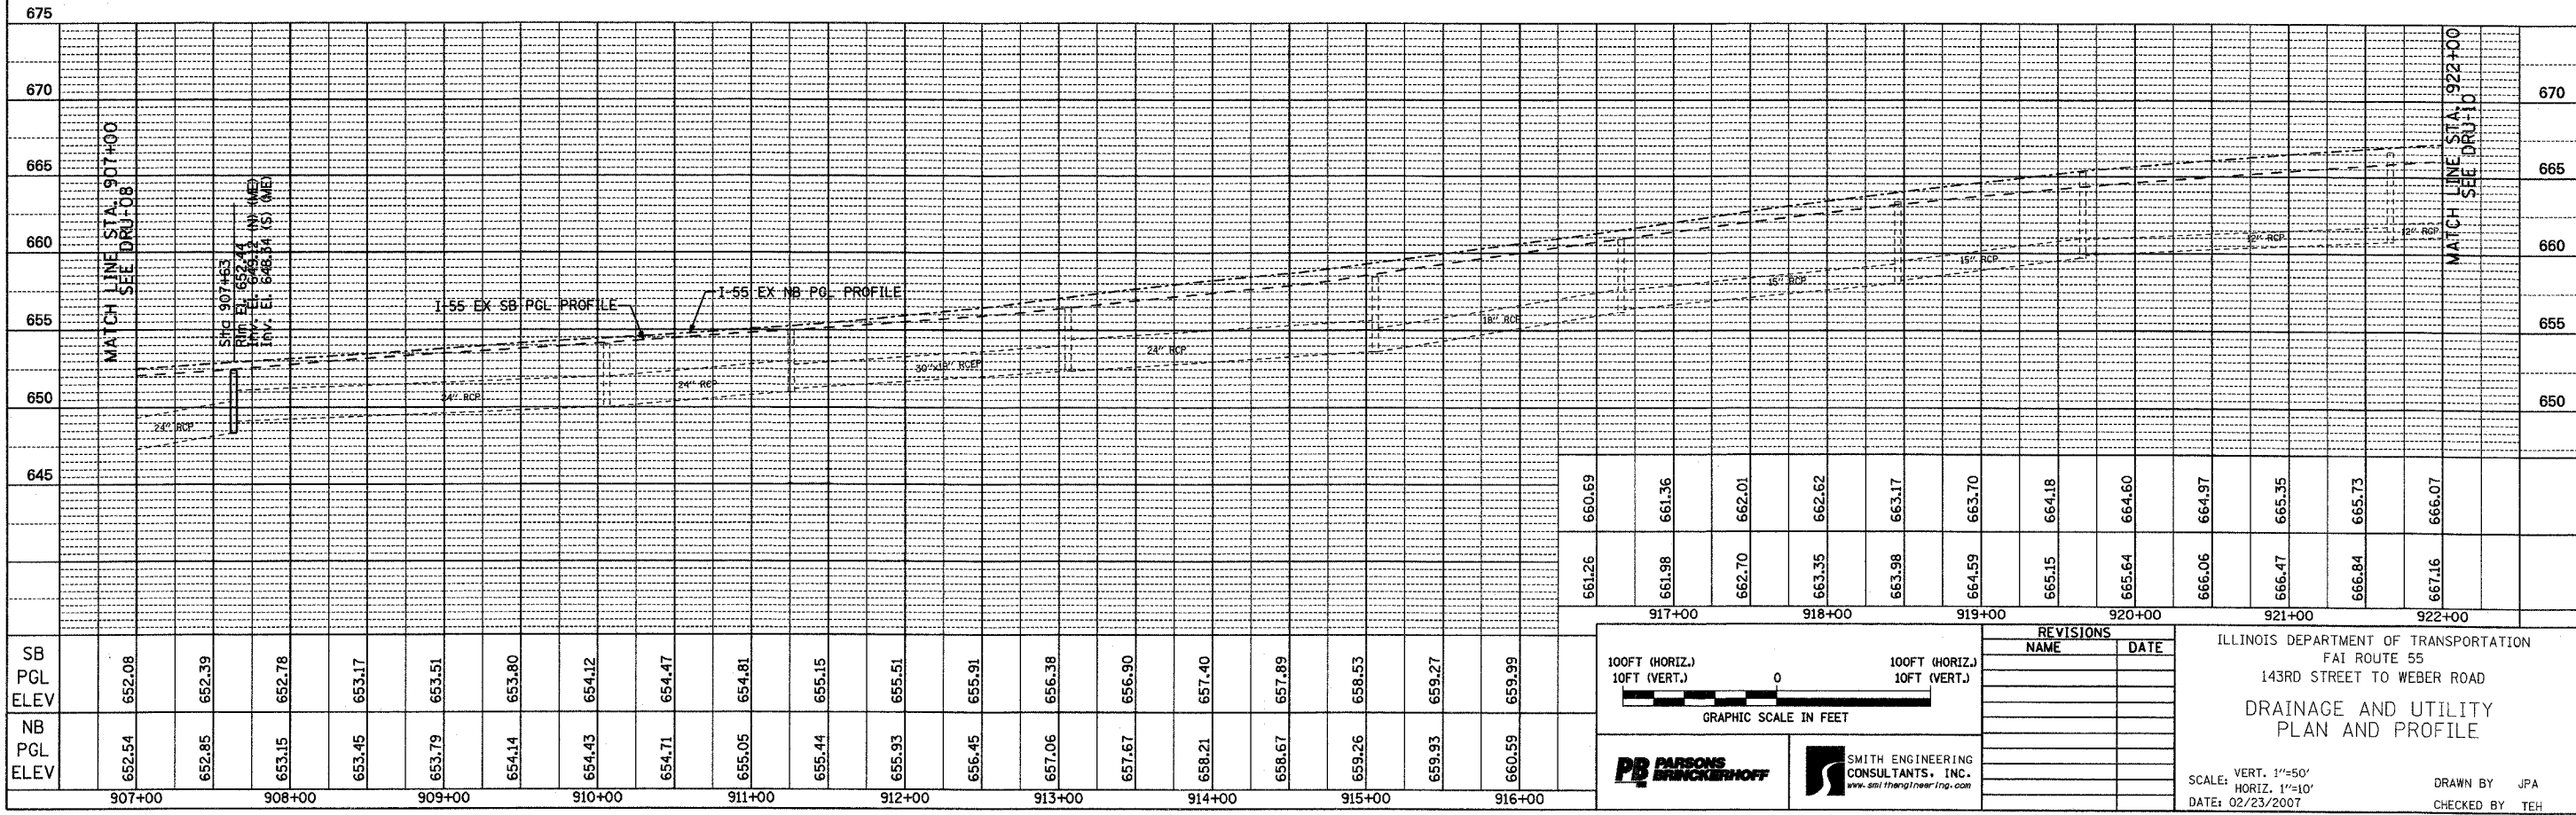


CONTRACT NO. 60B47				
F.A. RTE.	SECTION	COUNTY	TOTAL SHEETS	SHEET NO.
55	99 (I&2) WRS-3	WILL	305	114
STA. 907+00	TO STA. 922+00			
FED. ROAD DIST. NO.	ILLINOIS	FED. AID PROJECT		

DRU-09 OF 14

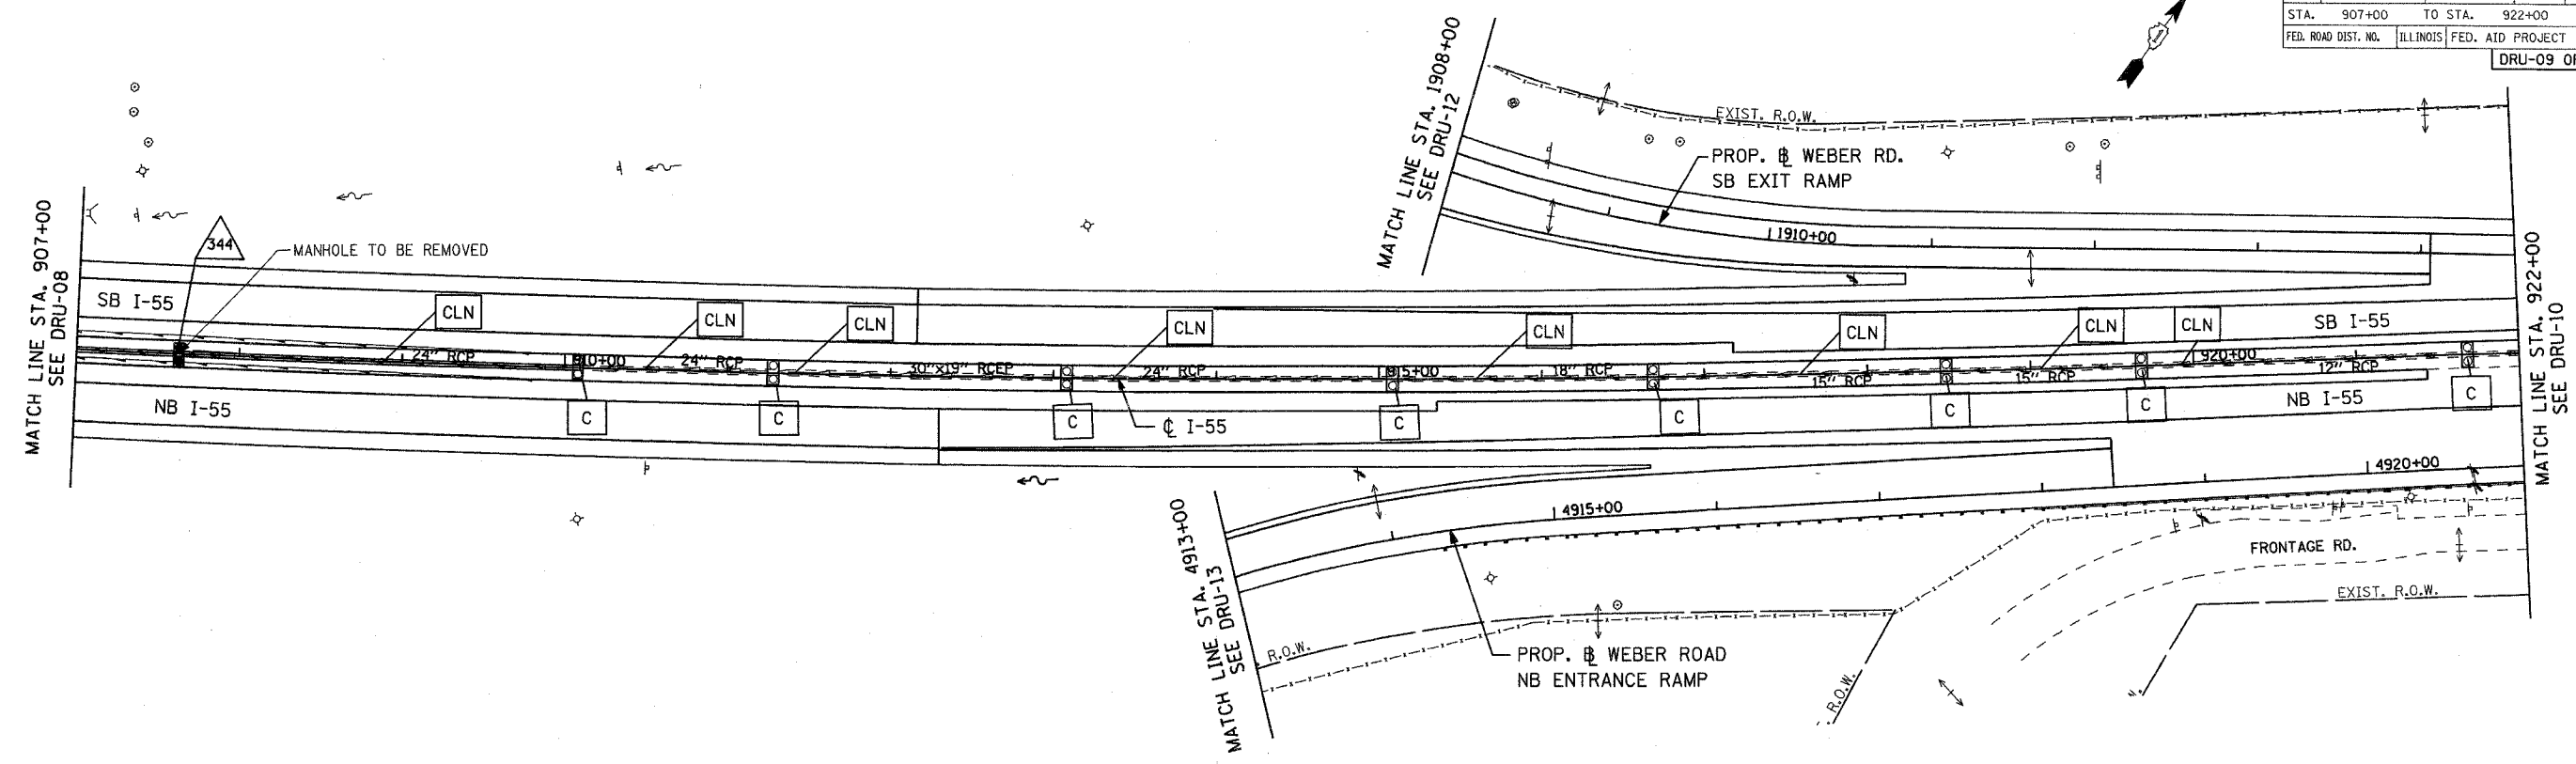

100FT (HORIZ.)
10FT (VERT.)

GRAPHIC SCALE IN FEET

PARSONS BRINCKERHOFF

SMITH ENGINEERING CONSULTANTS, INC.
www.smithenginc.com

REVISIONS	
NAME	DATE

ILLINOIS DEPARTMENT OF TRANSPORTATION
FAI ROUTE 55
143RD STREET TO WEBER ROAD
DRAINAGE AND UTILITY
PLAN AND PROFILE

SCALE: VERT. 1"=50'
HORIZ. 1"=10'
DATE: 02/23/2007

DRAWN BY JPA
CHECKED BY TEH

FINAL