 
 
 


 




 



 
F.A.I. RTE.	SECTION	COUNTY	TOTAL SHEETS	SHEET NO.
55	99 (I&I) WRS-3	WILL	305	170
STA. 922+00		TO STA. 937+00		
FED. ROAD DIST. NO. 1		ILLINOIS FED. AID PROJECT		
L-3 OF 13				

LEGEND

-  EXISTING LIGHTING UNIT
-  EXISTING LIGHTING UNIT TO BE REMOVED AND REINSTALLED
-  EXISTING HIGH MAST LIGHT TOWER
-  EXISTING DUCT
-  IDOT FIBER OPTIC CABLE
-  SIGN STRUCTURE
-  CIRCUIT DESIGNATION SCHEME
-  M CD 1
-  POLE NO ON GIVEN CKT (S)
-  CIRCUIT OR CIRCUITS
-  LIGHTING CONTROLLER DESIGNATION

NOTES:

- CONTRACTOR TO USE EXTREME CAUTION EXCAVATING IN AREAS OF EXISTING OR PROPOSED UNIT DUCT AND EXISTING FIBER OPTIC CABLE. CONTRACTOR SHALL PROTECT EXISTING CABLE DUCT AS NEEDED DURING EXCAVATION, TRENCHING, PLOWING, GUARDRAIL INSTALLATION, FOUNDATION INSTALLATION, AND PAVING ACTIVITIES.
- SIGN LUMINAIRE REMOVAL IS TO BE PAID FOR UNDER "REMOVAL OF EXISTING LIGHTING UNIT, SALVAGE".

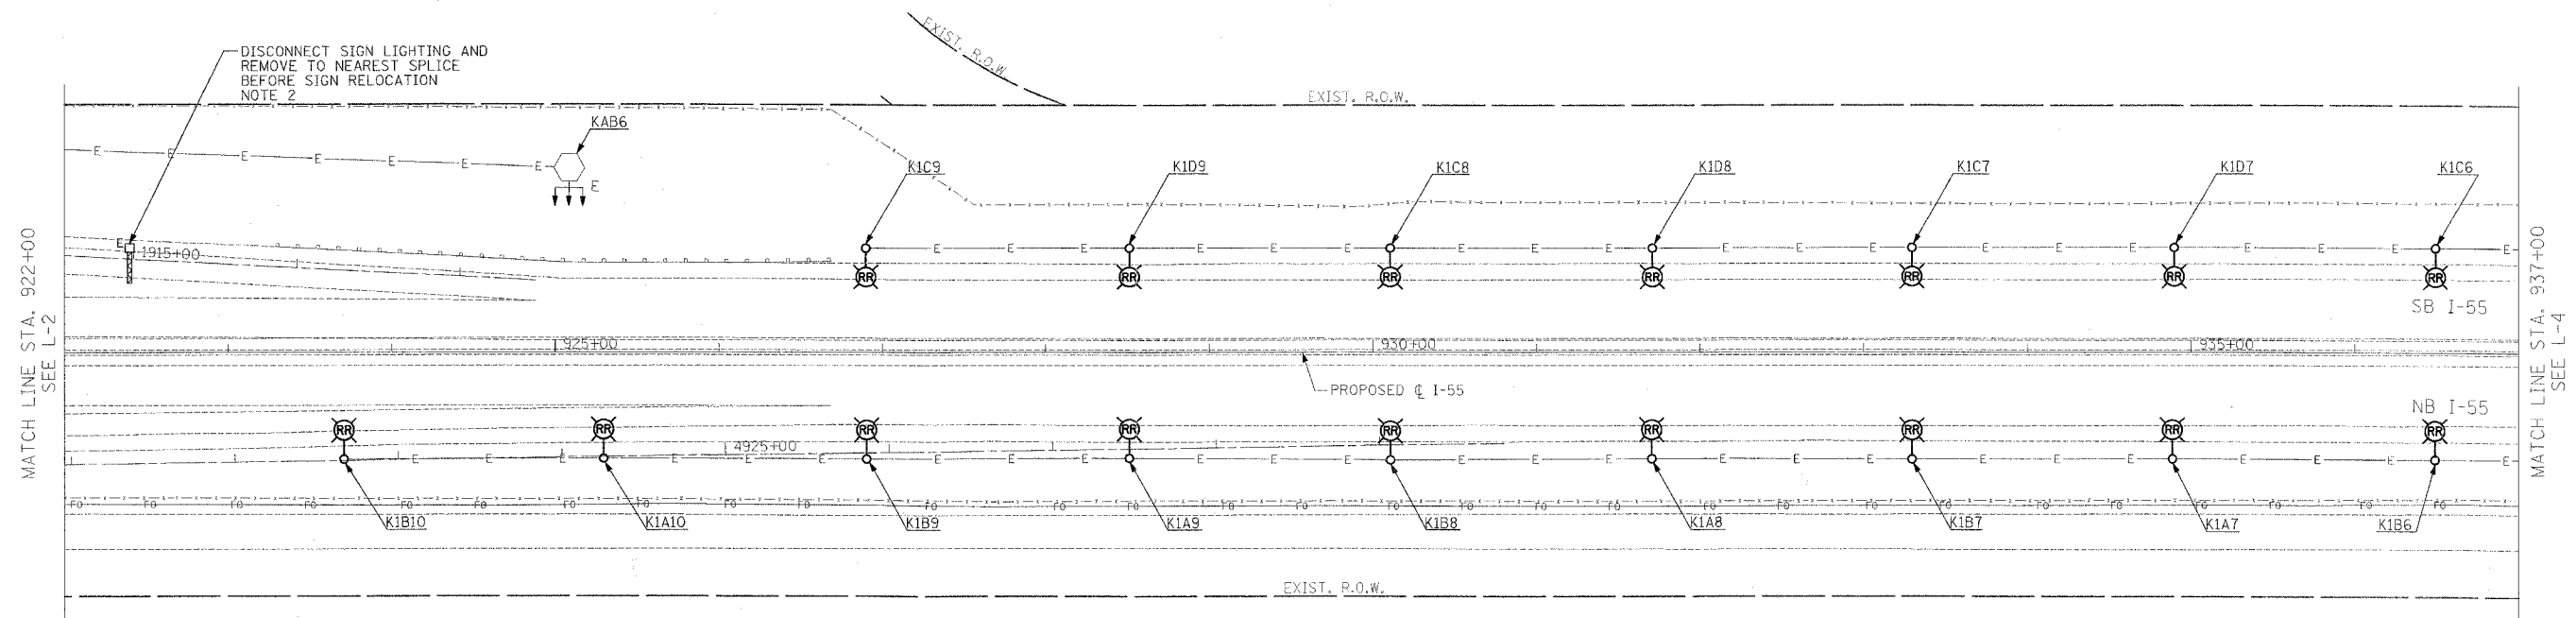

REVISIONS	
NAME	DATE

L-3

ILLINOIS DEPARTMENT OF TRANSPORTATION
F.A.I. I-55
143rd STREET TO WEBER ROAD

EXISTING LIGHTING PLAN

SCALE: 1" = 50'
DATE: 02-23-07

DRAWN BY: VG
CHECKED BY: PV

SINGH
SINGH & ASSOCIATES, INC.
CONSULTING ENGINEERS

350 N. ADAMS ST.
CHICAGO, IL 60604
TEL: (312) 629-0240
FAX: (312) 629-8449

PB PARSONS BRINCKERHOFF

FINAL