

F.A.I. RITE	SECTION	COUNTY	TOTAL SHEETS	SHEET NO.
F.A.I. D4 I-74	74 Landscaping 2007	PEORIA	21	1

INDEX OF SHEETS:

SHEET NO.	DESCRIPTION
1.	COVER SHEET AND INDEX OF SHEETS
2.	GENERAL NOTES, STANDARDS AND COMMITMENTS
3 - 6.	SUMMARY OF QUANTITIES
7.	SCHEDULE OF LANDSCAPE ITEMS
8.	TEMPORARY EROSION CONTROL NOTES AND SCHEDULES
9.	SCHEDULE OF QUANTITIES
10.	CALENDER OF CONSTRUCTION
11.	OVERALL SCHEMATIC PLAN
12.	LANDSCAPE LOCATION PLAN 1
13.	LANDSCAPE LOCATION PLAN 2
14.	LANDSCAPE - LAYOUT 1
15.	LANDSCAPE - LAYOUT 2
16.	LANDSCAPE - LAYOUT 3
17.	LANDSCAPE - LAYOUT 4
18.	LANDSCAPE - LAYOUT 5
19.	LANDSCAPE - LAYOUT 6
20.	PIPING FOR LANDSCAPE WATER SERVICE
21.	BACKFLOW PREVENTER ENCLOSURE DETAIL


**STATE OF ILLINOIS
DEPARTMENT OF TRANSPORTATION
DIVISION OF HIGHWAYS**

**PLANS FOR PROPOSED
FEDERAL AID INTERSTATE**

**F.A.I. ROUTE 74 (I-74)
SECTION D4 I-74 LANDSCAPING 2007**

**LANDSCAPING ALONG I-74 FROM ARMSTRONG AVENUE
TO ILLINOIS RIVER IN PEORIA
PEORIA COUNTY**


**C-94-001-04
RANGE 8 EAST - 4TH P.M.**

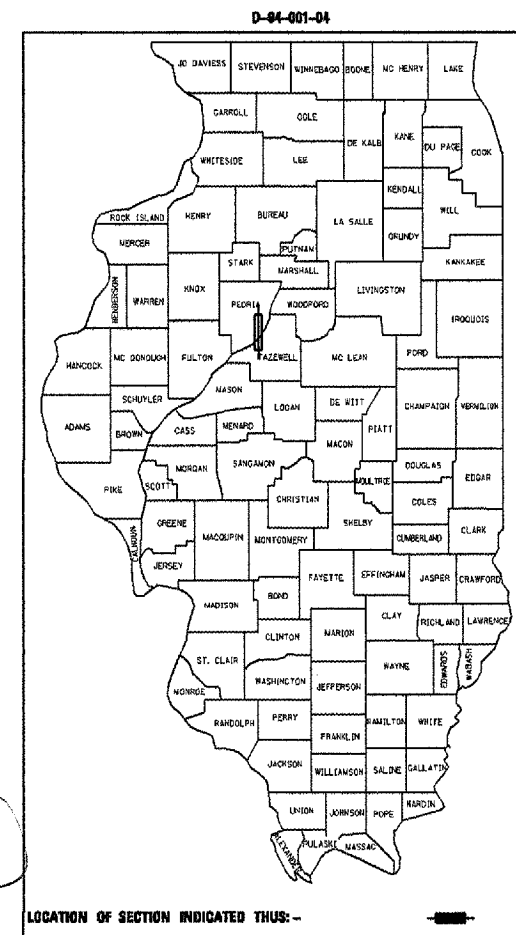

LIST OF STANDARDS

SEE SHEET NO. 2


METRIC RATIOS

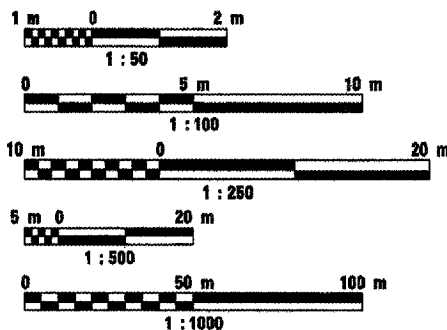

FULL SIZE PLANS HAVE BEEN PREPARED USING STANDARD ENGINEERING SCALES. REDUCED SIZED PLANS WILL NOT CONFORM TO STANDARD SCALES. IN MAKING MEASUREMENTS ON REDUCED PLANS, THE ABOVE SCALES MAY BE USED.

J.U.L.I.E.
JOINT UTILITY LOCATION INFORMATION FOR EXCAVATION
1-800-892-0123

**CONTRACT NO. 68367
CATALOG NO. 031087-54D**

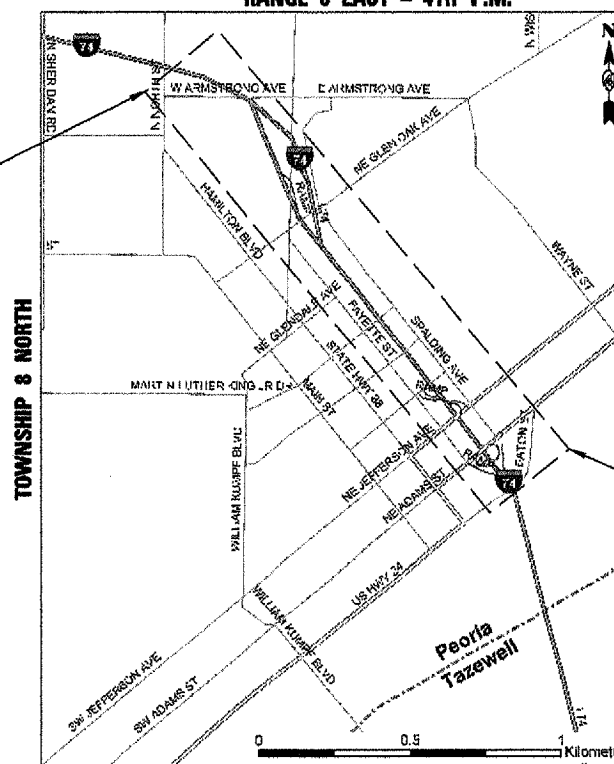

**LOCATION MAP
MAP SCALE : N.T.S.**

**GROSS LENGTH PROJECT=2,250 m=2.25 km
NET LENGTH PROJECT=2,140 m=2.14 km**

JAMIL BOU-SAAB
062-047537
REGISTERED
PROFESSIONAL
ENGINEER
OF
ILLINOIS
[Signature]
3/19/07

**PROJECT END
STA. 150+400**

DESCRIPTION OF WORK

THIS PROJECT INCLUDES INSTALLATION OF LANDSCAPING MATERIALS AND ALL OTHER COLLATERAL WORK.

STATE OF ILLINOIS
DEPARTMENT OF TRANSPORTATION
DIVISION OF HIGHWAYS

SUBMITTED March 20, 2007

[Signature]
DEPUTY DIRECTOR OF HIGHWAYS, REGION ENGINEER

May 11, 2007
[Signature]
ENGINEER OF DESIGN AND ENVIRONMENT

May 11, 2007
[Signature]
DIRECTOR OF HIGHWAYS, CHIEF ENGINEER

TERRA
ENGINEERING LTD.
505 N. LaSalle Street, Suite 250
Chicago, IL 60610
(312) 467-8123

DATE: July 16th, 2004

PRINTED BY THE AUTHORITY OF THE STATE OF ILLINOIS
TERRA ENGINEERING CONTACT: GEORGE GHAREEB PHONE #: 309-671-4214
ALFRED BENESCH & CO. CONTACT: DAVID MORELL PHONE #: 312-565-0450

PROJECT ENGINEER: RICHARD DOTSON 309-671-3455
CONSULTANT LIAISON ENGINEER: CHRISTOPHER MAUSHAARD 309-671-3464