
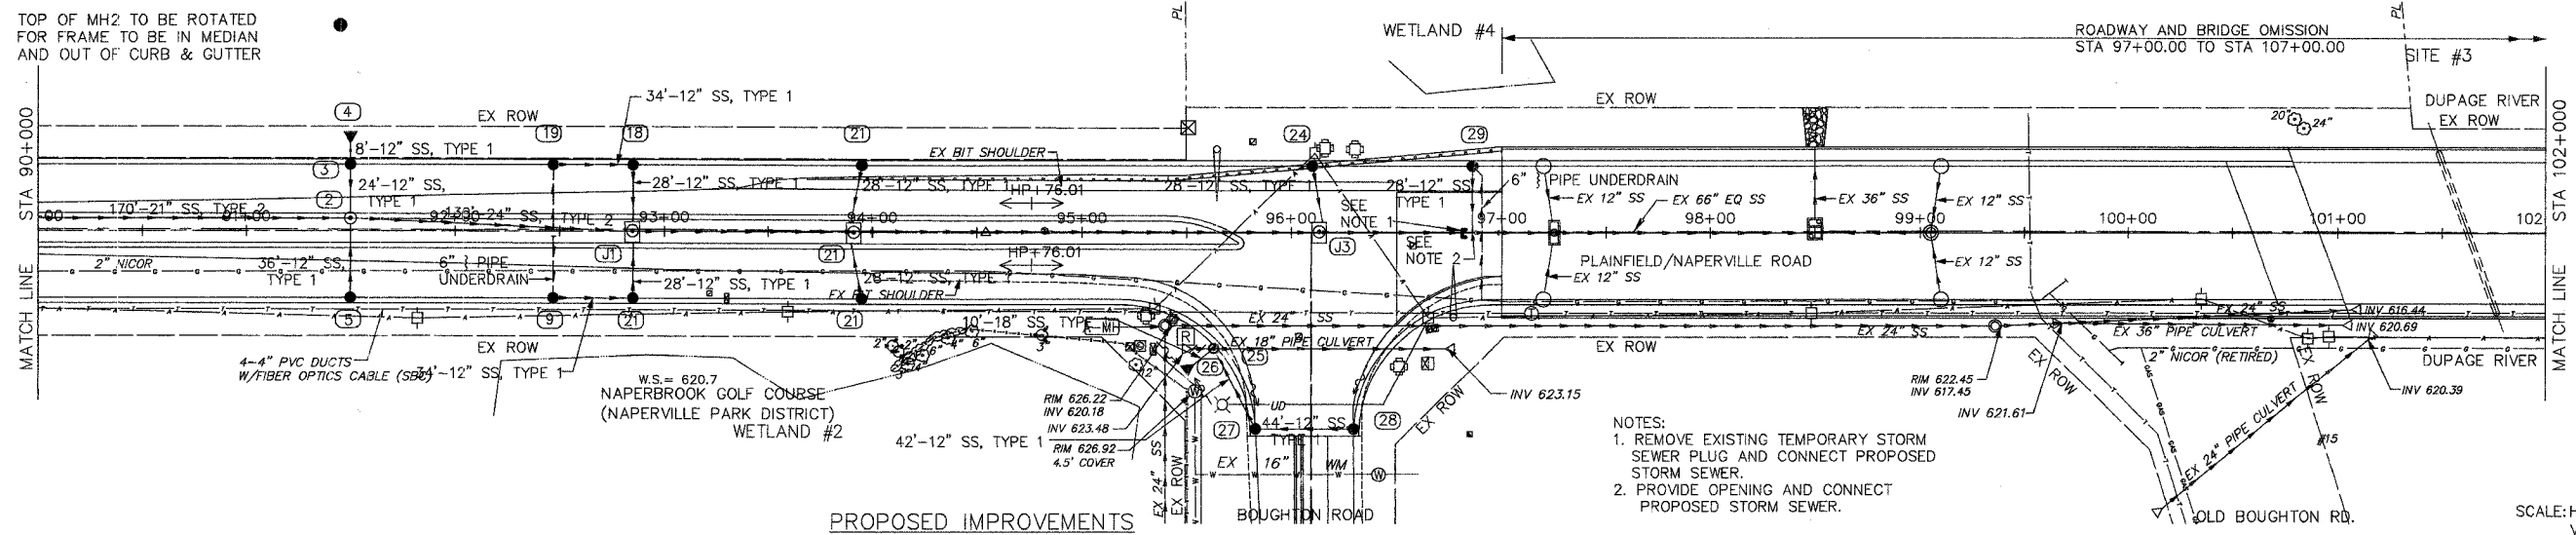



* 98-00036-19-FP

| ROUTE NO. | SECTION | COUNTY | TOTAL SHEETS | SHEET NO. |
|-----------------------|----------|------------------|--------------------|-----------|
| FAU 2545 | * | WILL | 147 | 52 |
| FED. ROAD DIST. NO. 7 | ILLINOIS | FED. AID PROJECT | CONTRACT NO. 83896 | |

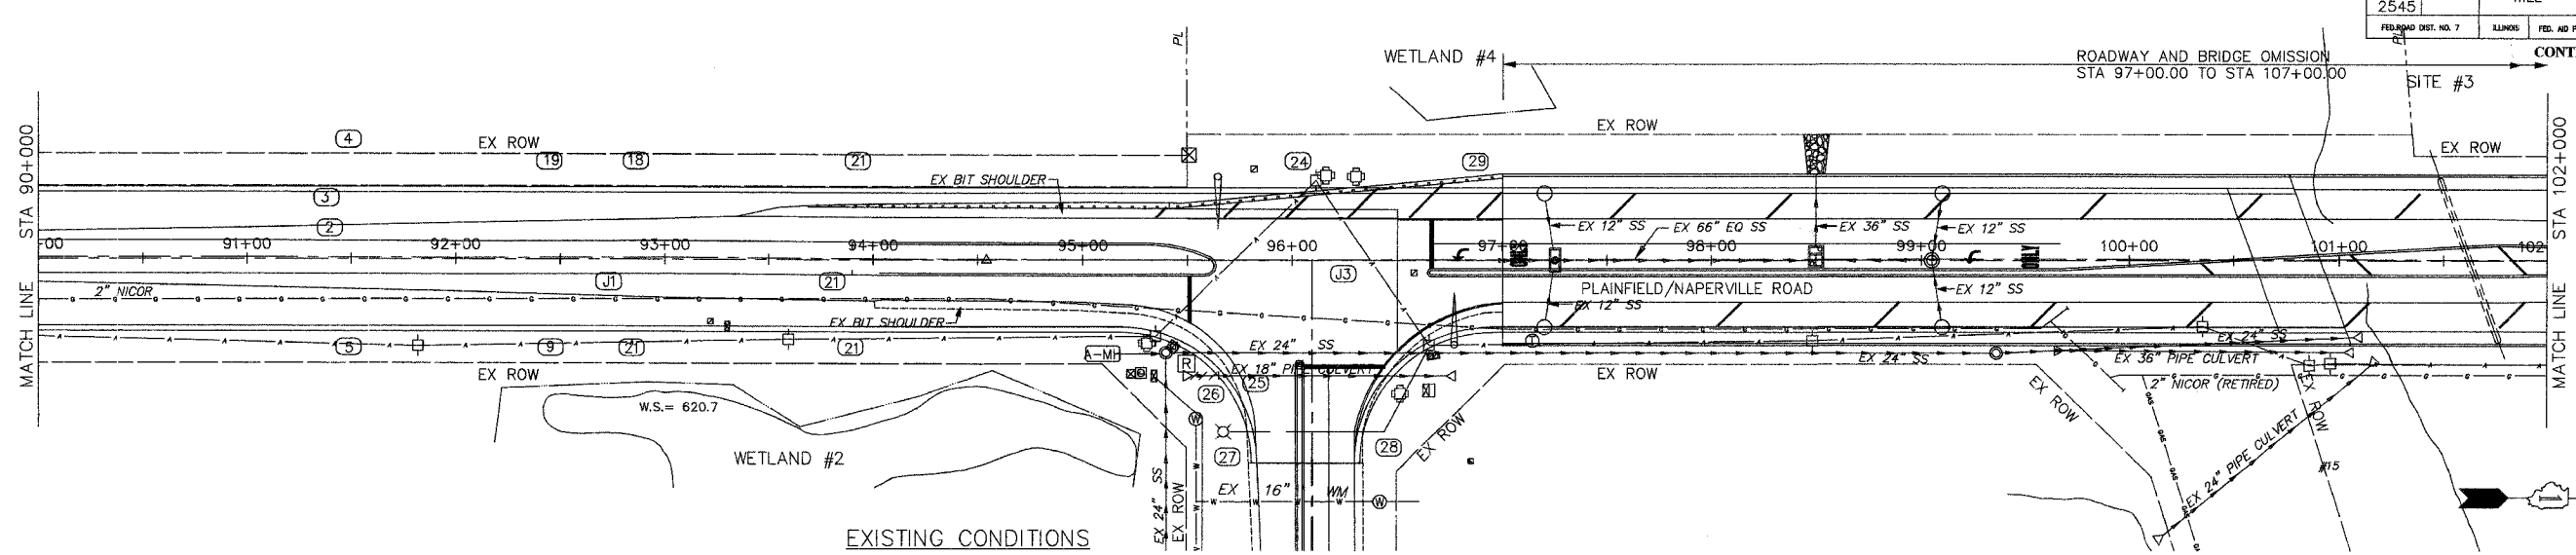

- NOTES:
1. REMOVE EXISTING TEMPORARY STORM SEWER PLUG AND CONNECT PROPOSED STORM SEWER.
 2. PROVIDE OPENING AND CONNECT PROPOSED STORM SEWER.

SCALE: HORIZ: 1"=40'
VERT: 1"=5'

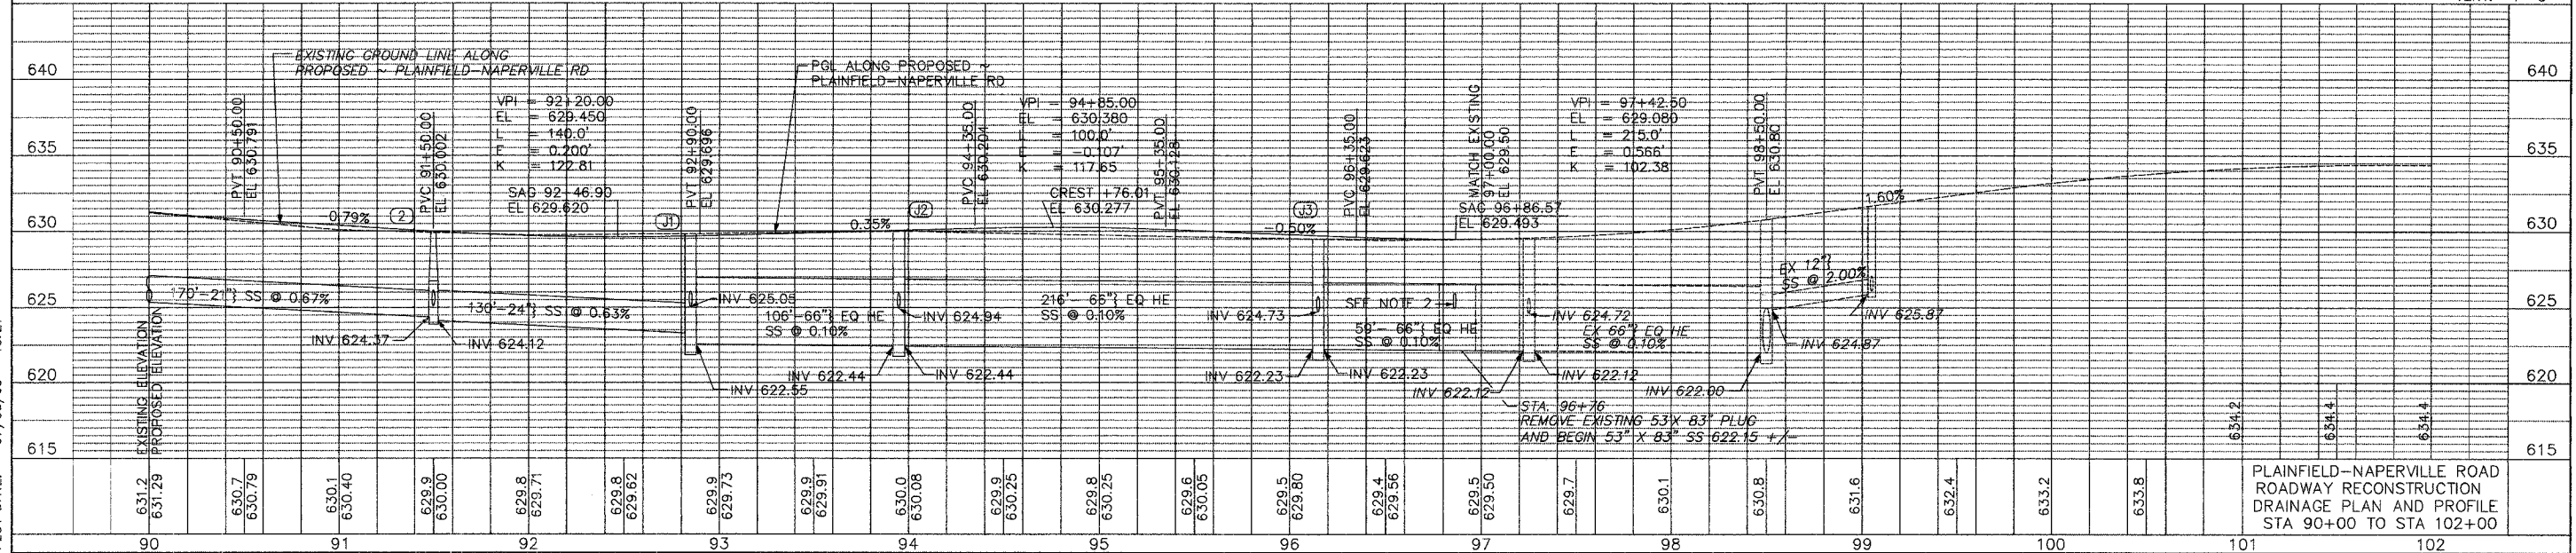

DRAWING ID: G:\20030023 - Plainfield-Naperville Road\dwg\DRN03.dwg
PLOT DATE: 07/08/05 - 15:21

PLAINFIELD-NAPERVILLE ROAD
ROADWAY RECONSTRUCTION
DRAINAGE PLAN AND PROFILE
STA 90+00 TO STA 102+00