



ROUTE NO.	SECTION	COUNTY	TOTAL SHEETS	SHEET NO.
FAU 2545	*	WILL	147	147
FED. ROAD DIST. NO. 7		ILLINOIS	FED. AID PROJECT	

\* 98-00036-19-FP


CONTRACT NO. 83896

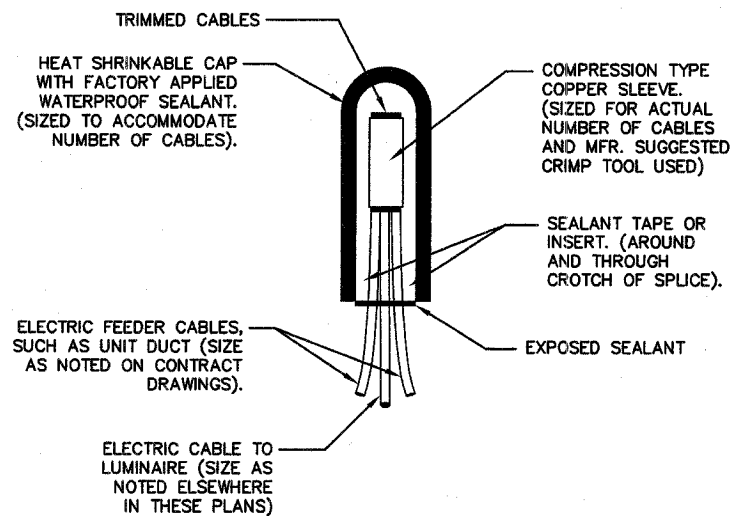

**SPLICING ELECTRIC CABLES**  
BASIC MATERIALS AND METHODS  
N.T.S.

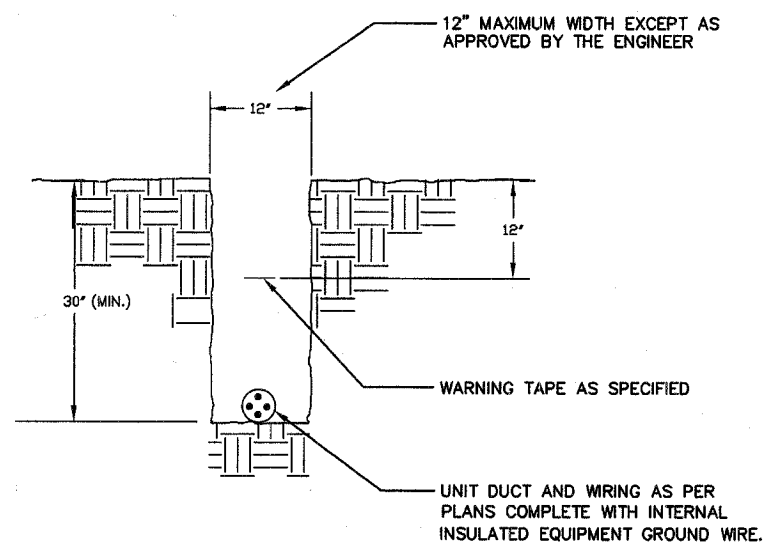

**TYPICAL WIRING IN TRENCH - DETAIL**  
N.T.S.

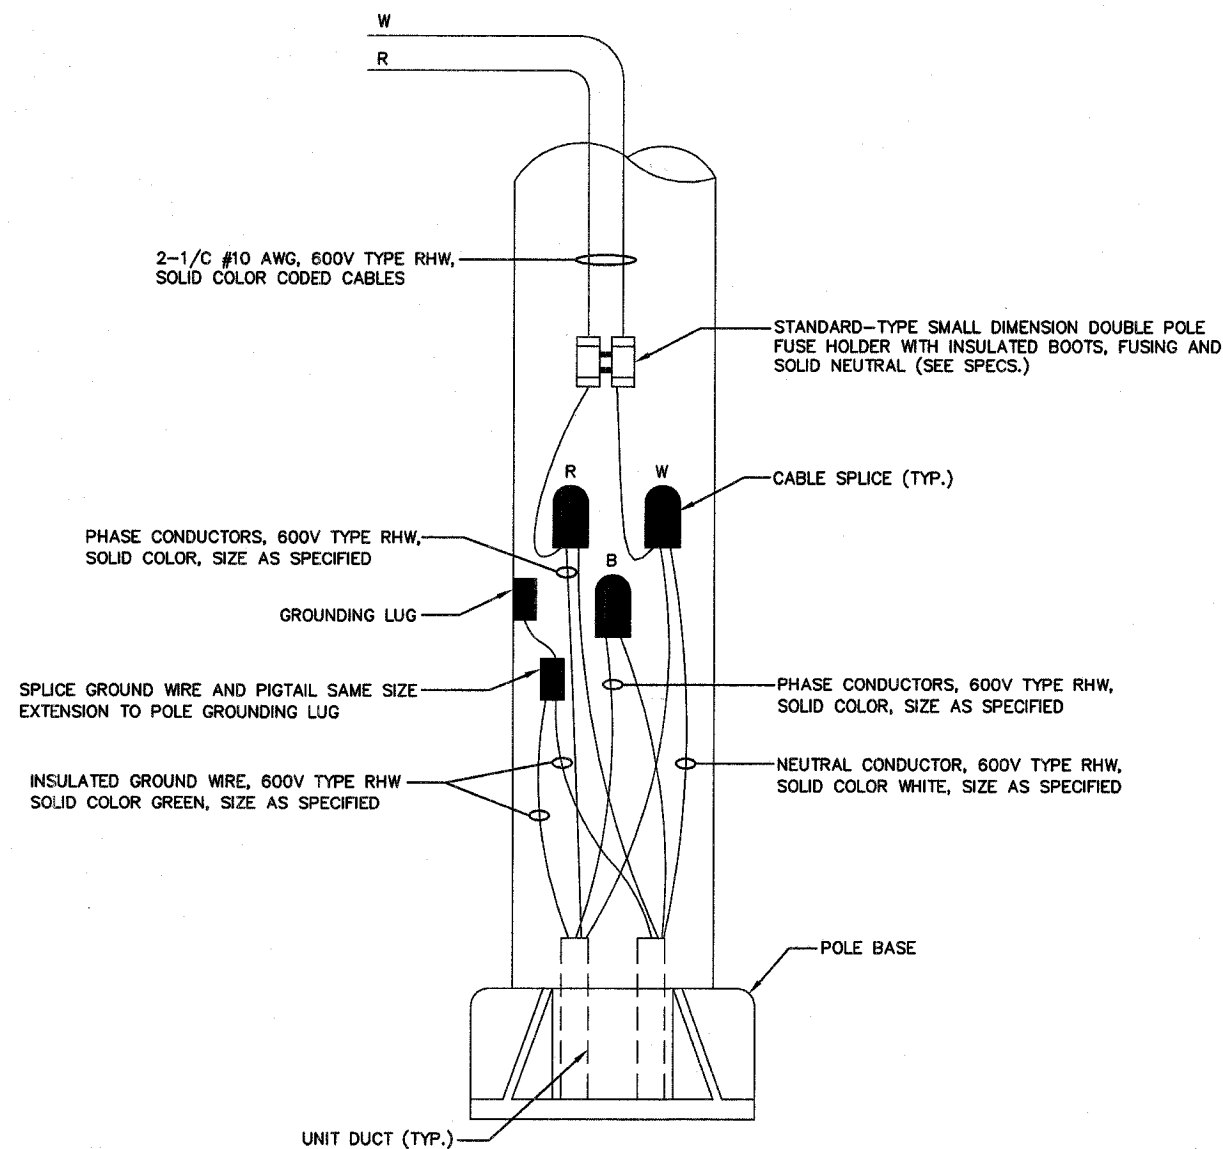

**POLE WIRING DETAIL**  
N.T.S.

DRAWING ID: 0  
PLOT DATE: 0

NO.	DATE	REVISION	BY

<b>WILL COUNTY DEPARTMENT OF HIGHWAYS</b>	
<b>PLAINFIELD-NAPERVILLE ROAD (C.H. 14)</b>	
<b>ROADWAY RECONSTRUCTION</b>	
<b>ELECTRICAL DETAILS</b>	
McDonough Associates Inc. Engineers/Architects	DESIGNED BY: JES CHECKED BY: KMY DRAWN BY: JES
SCALE: N.T.S.	