
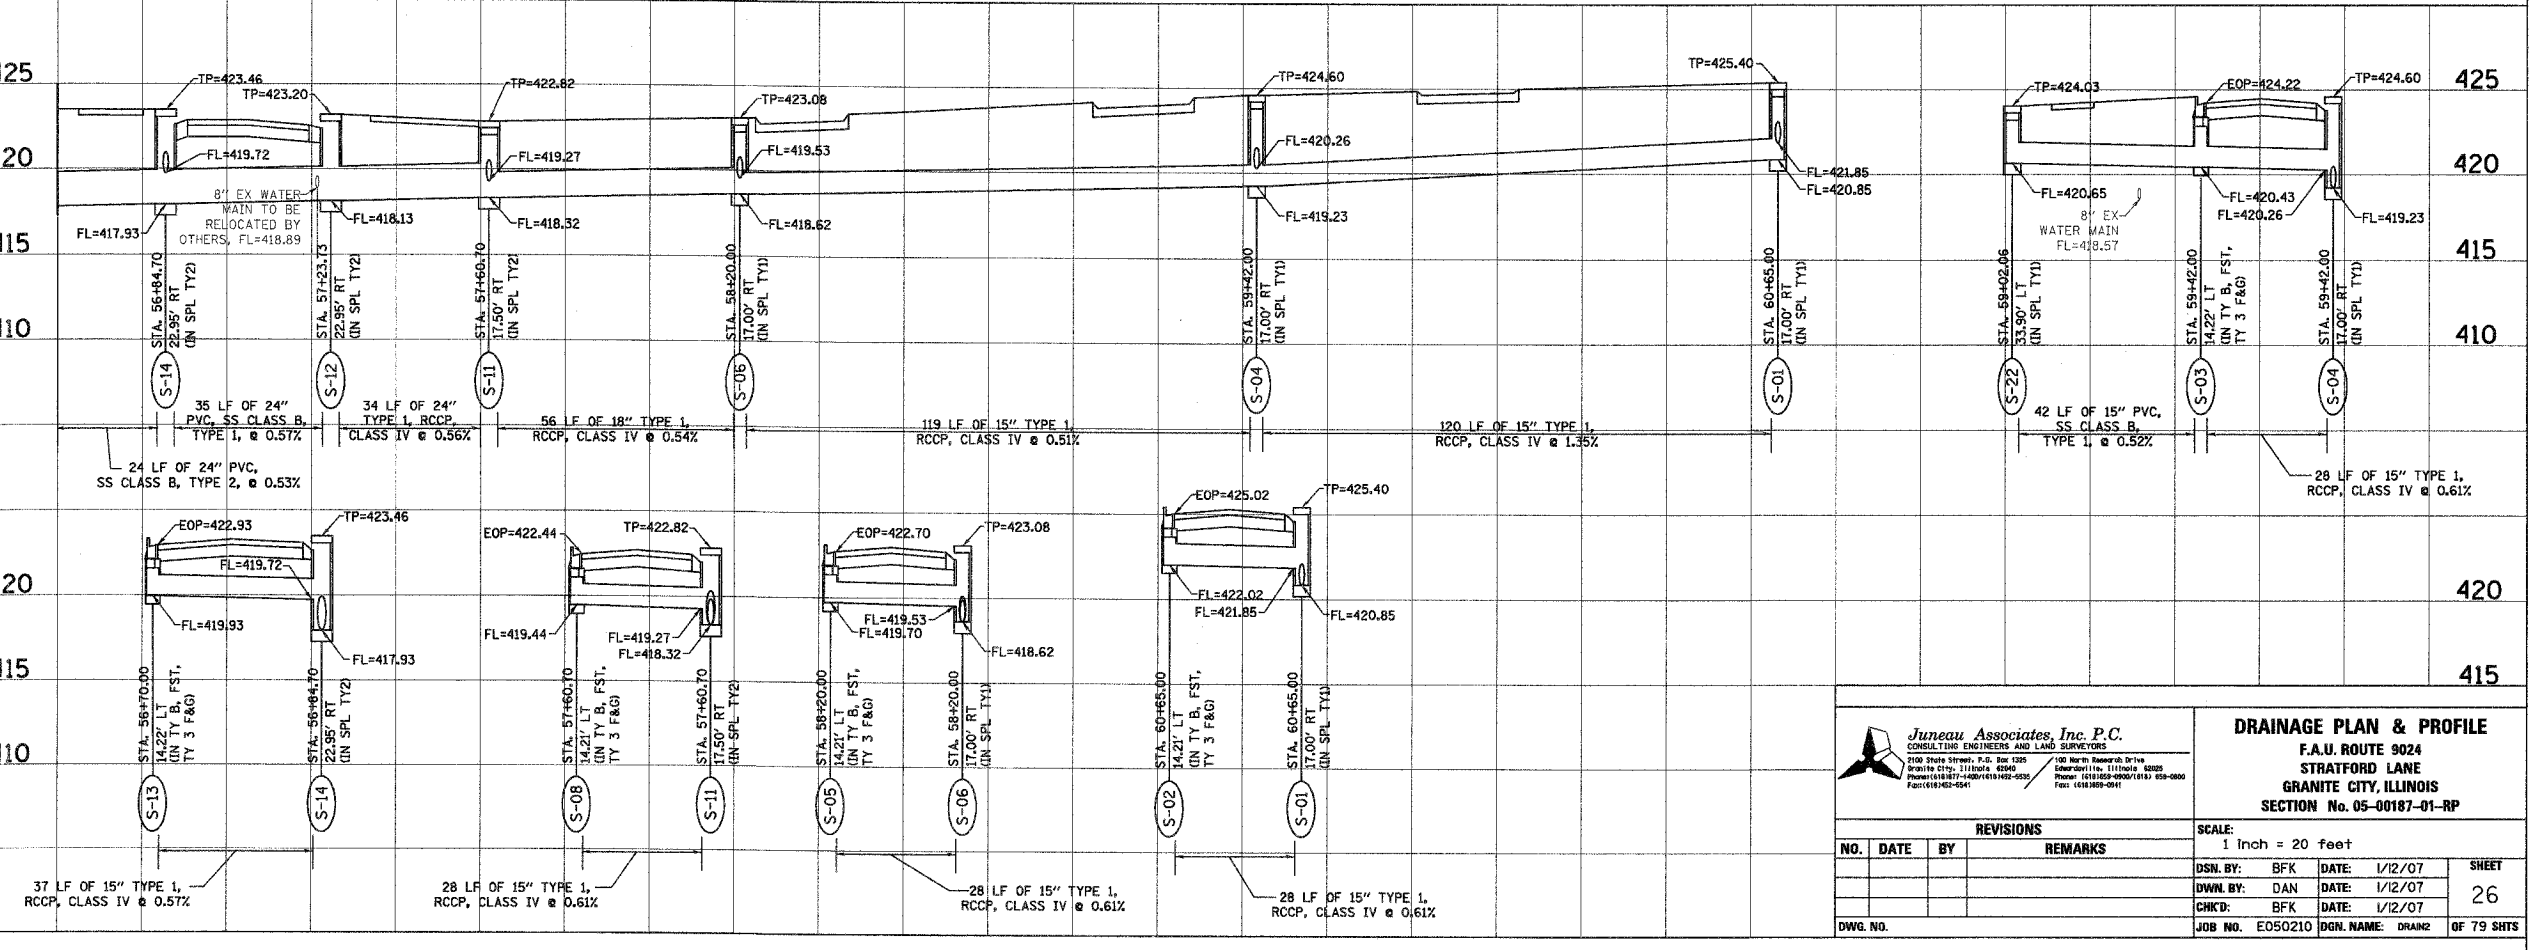


F.A.U. RTE.	SECTION	COUNTY	TOTAL SHEETS	SHEET NO.
9024	05-00187-01-RP	MADISON	79	26
FED. ROAD DIST. NO.	ILLINOIS	FED. AID PROJECT		

CONTRACT NO. 97288

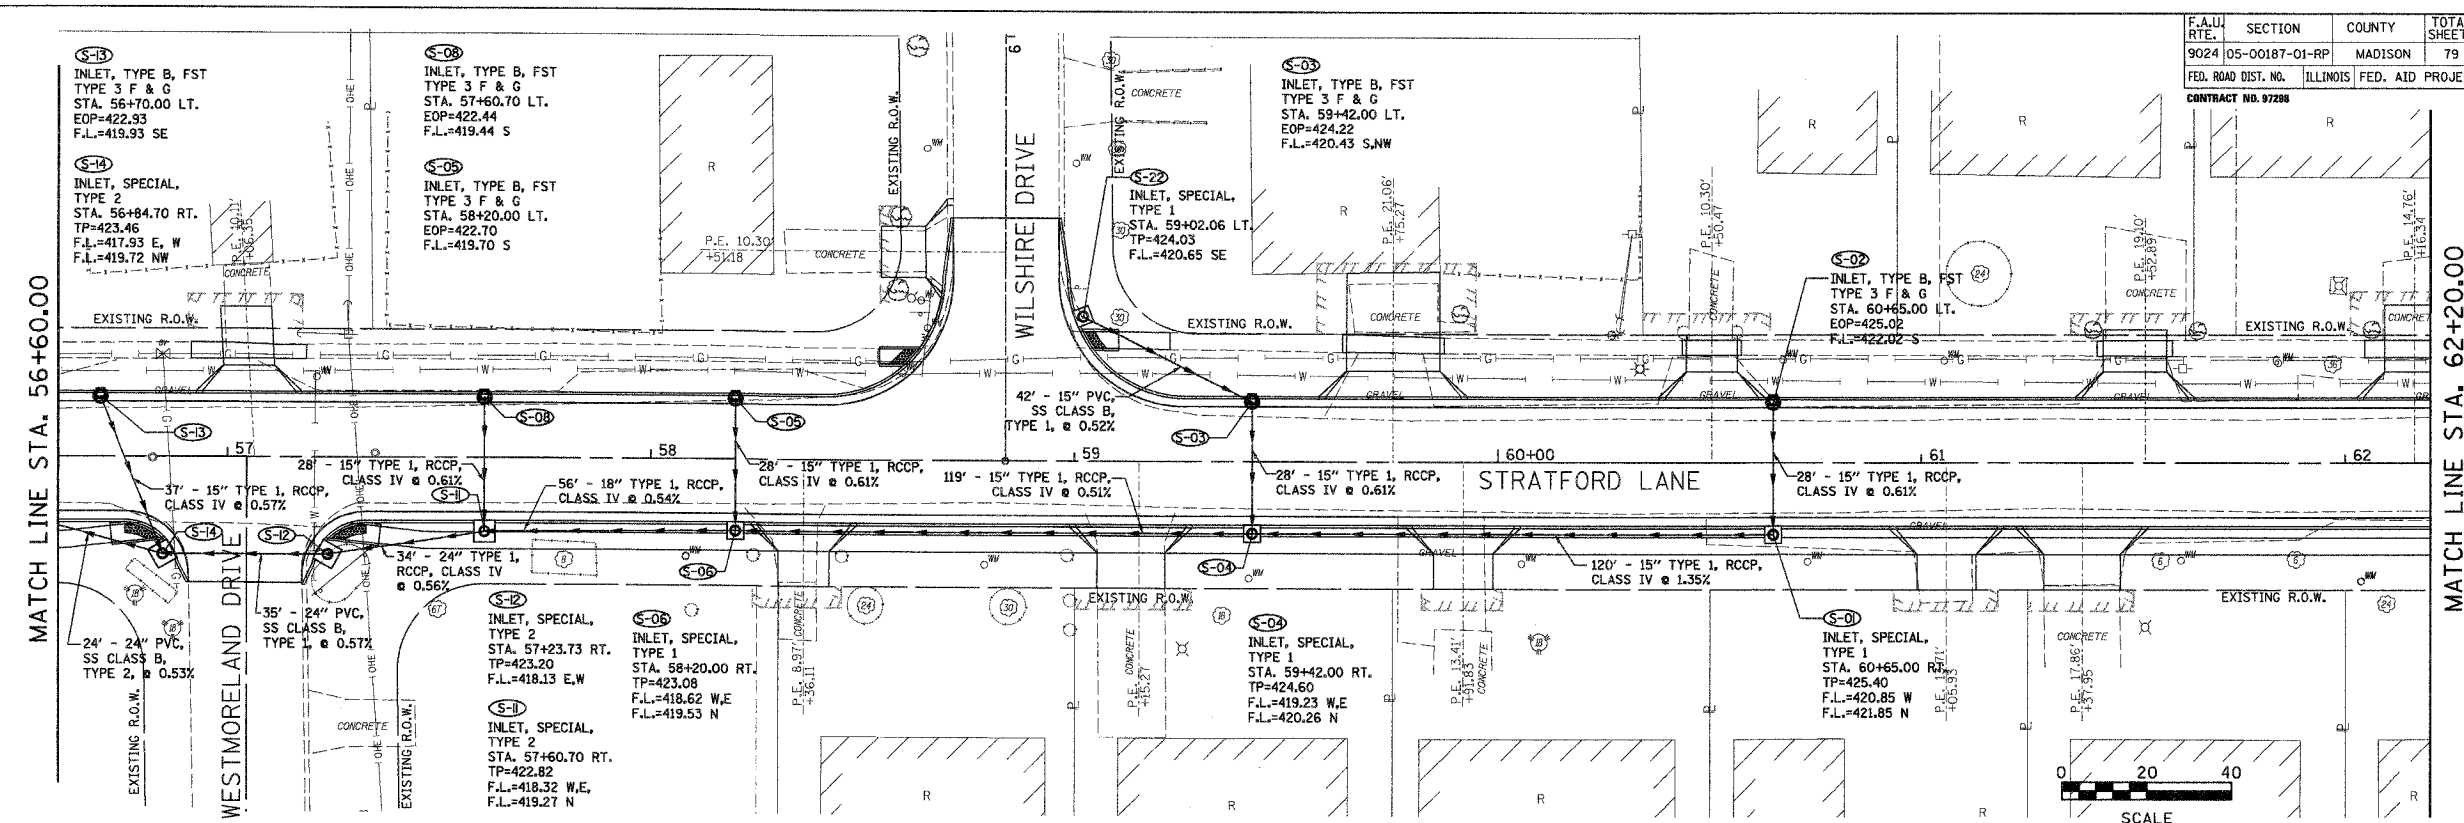

BY	DATE

BY	DATE

**Juneau Associates, Inc. P.C.**  
CONSULTING ENGINEERS AND LAND SURVEYORS  
2100 State Street, P.O. Box 1205  
Granite City, Illinois 62041  
Phone: (618) 651-1100  
Fax: (618) 651-1101

**DRAINAGE PLAN & PROFILE**  
F.A.U. ROUTE 9024  
STRATFORD LANE  
GRANITE CITY, ILLINOIS  
SECTION No. 05-00187-01-RP

REVISIONS			
NO.	DATE	BY	REMARKS

SCALE:	1 inch = 20 feet
DSN. BY:	BFK
DATE:	1/12/07
DRAWN BY:	DAN
DATE:	1/12/07
CHK'D:	BFK
DATE:	1/12/07
JOB NO.:	E050210
DGN. NAME:	DRAIN2
OF 79 SHTS	

26