
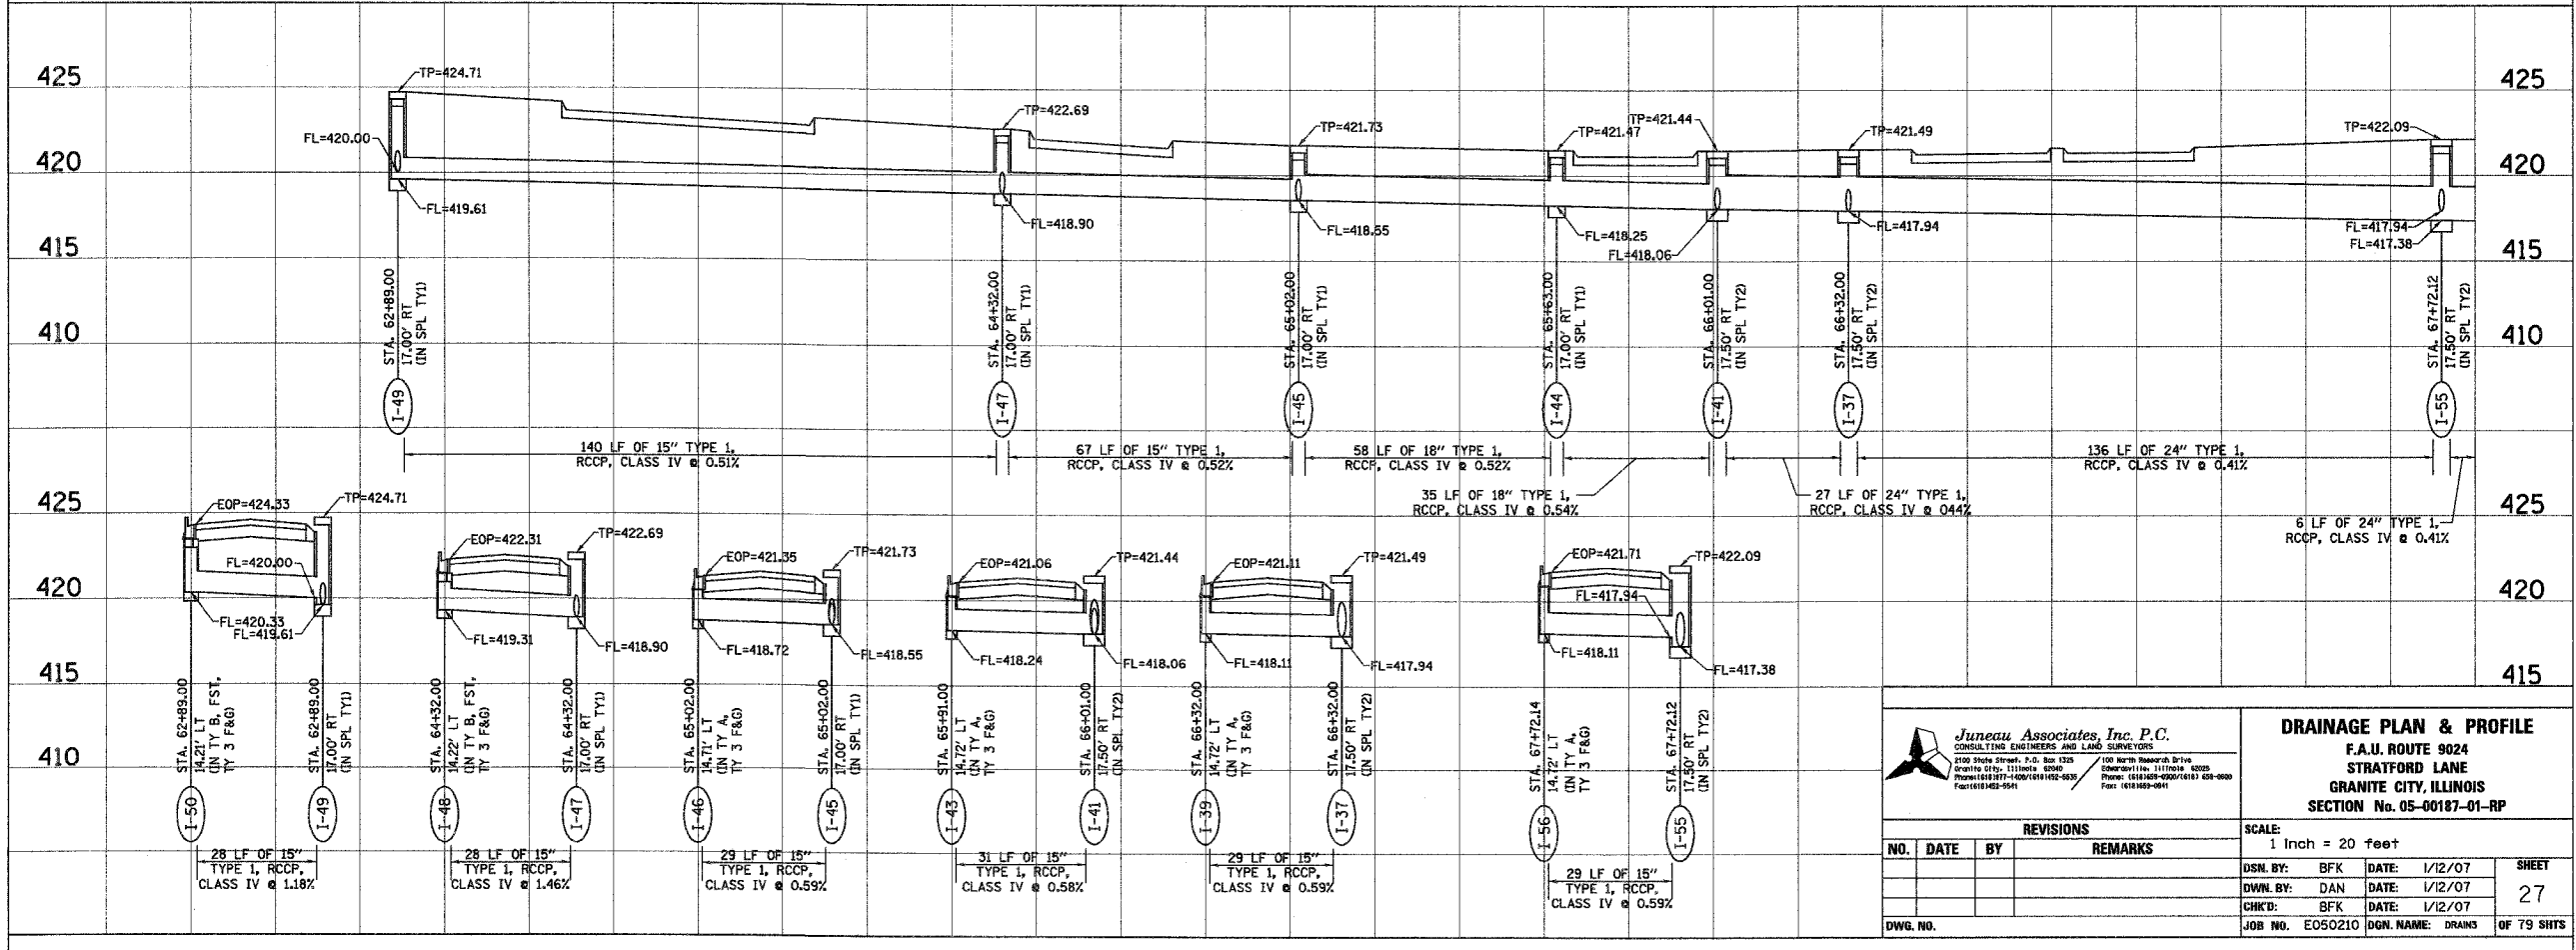


F.A.U. ROUTE	SECTION	COUNTY	TOTAL SHEETS	SHEET NO.
9024	05-00187-01-RP	MADISON	79	27
FED. ROAD DIST. NO.	ILLINOIS FED. AID PROJECT			

CONTRACT NO. 97288

BY	DATE

ORIGINAL SURVEY	SURVEYED	DATE

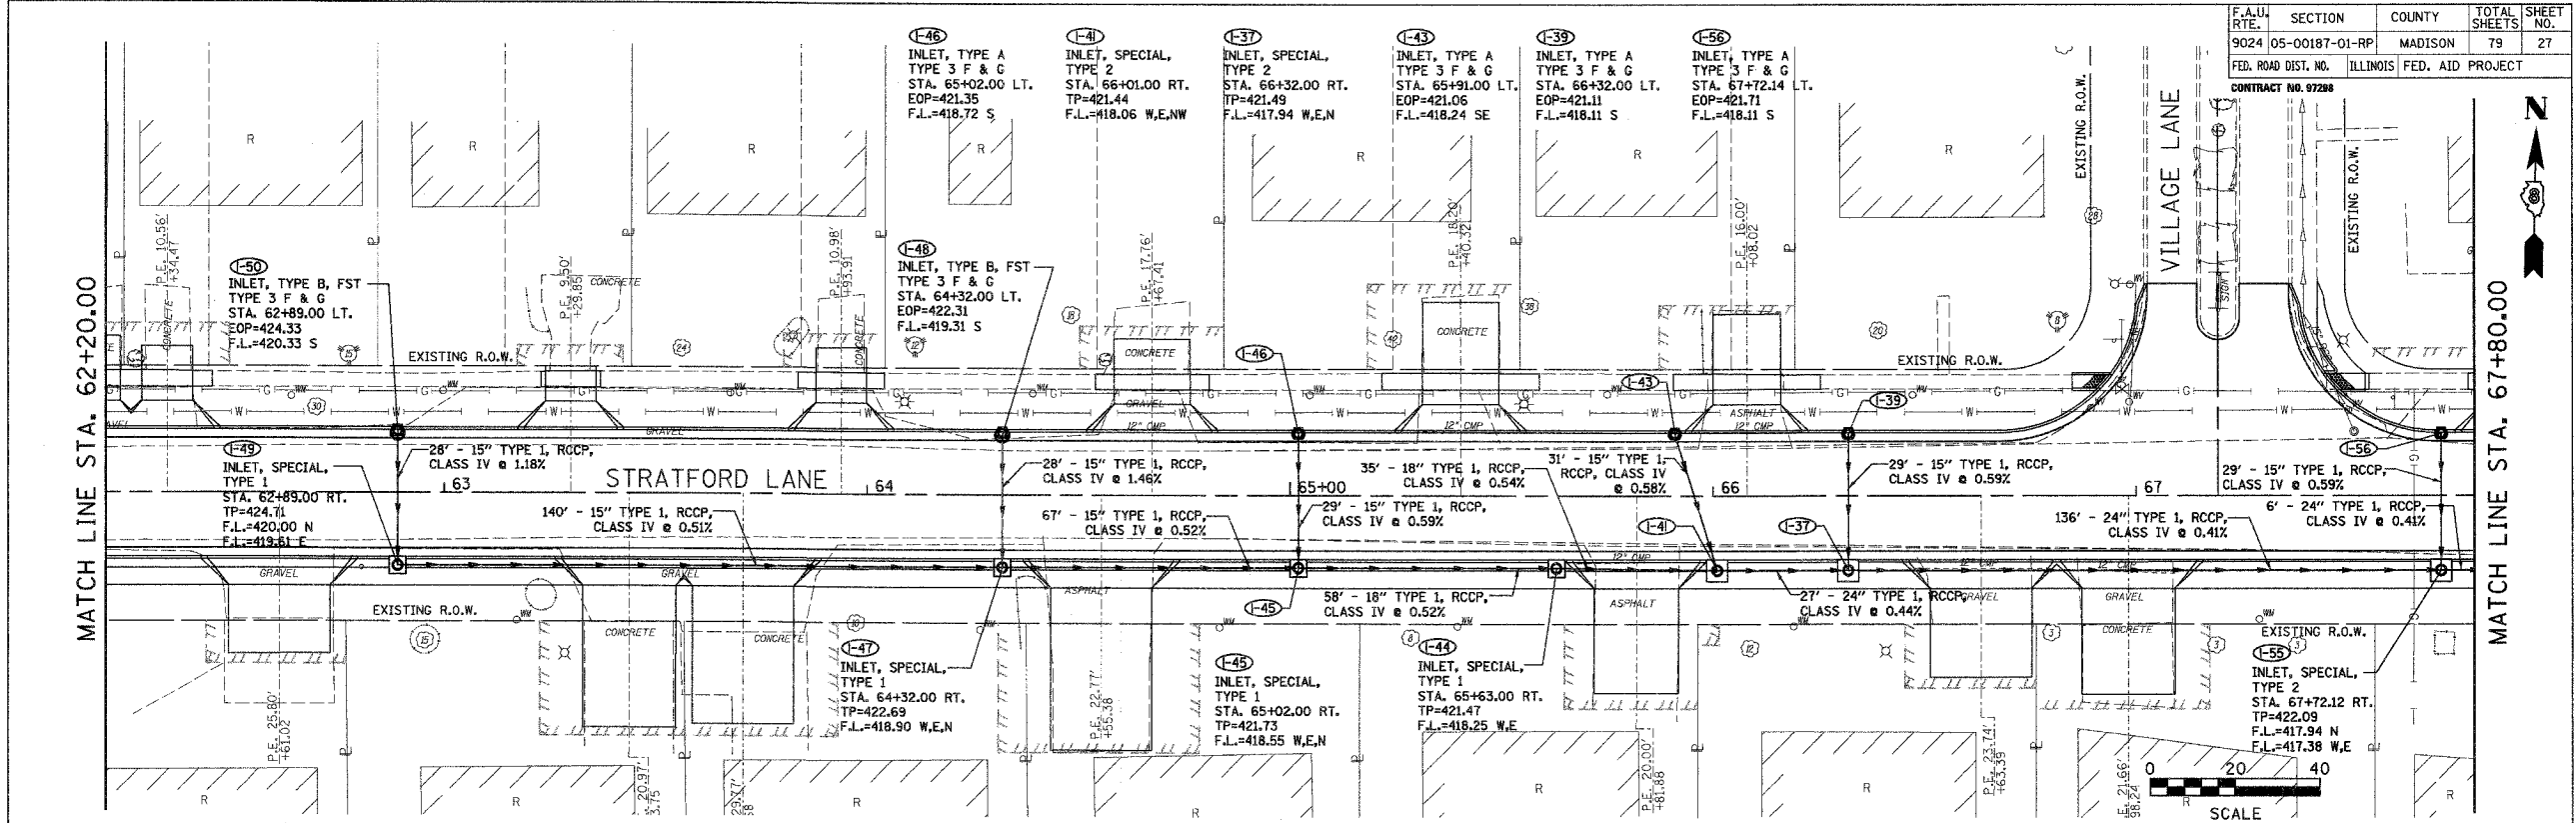

Juneau Associates, Inc. P.C.
 CONSULTING ENGINEERS AND LAND SURVEYORS
 110 North Research Drive
 Granite City, Illinois 62040
 Phone: (618) 937-4000 Fax: (618) 937-4001

DRAINAGE PLAN & PROFILE
 F.A.U. ROUTE 9024
 STRATFORD LANE
 GRANITE CITY, ILLINOIS
 SECTION No. 05-00187-01-RP

REVISIONS			
NO.	DATE	BY	REMARKS

SCALE: 1 Inch = 20 feet			
DSN. BY:	BFK	DATE:	1/12/07
DWN. BY:	DAN	DATE:	1/12/07
CHKD. BY:	BFK	DATE:	1/12/07
JOB NO.	E050210	DGN. NAME:	DRAINS
			SHEET 27 OF 79 SHITS