



F.A.U. RTE.	SECTION	COUNTY	TOTAL SHEETS	SHEET NO.
9024	05-00187-01-RP	MADISON	79	31
FED. ROAD DIST. NO.	ILLINOIS FED. AID PROJECT			
CONTRACT NO. 97298				

FINAL SURVEY PLOTTED	BY	DATE
NOTE BOOK		
AREAS CHECKED		
NO.		

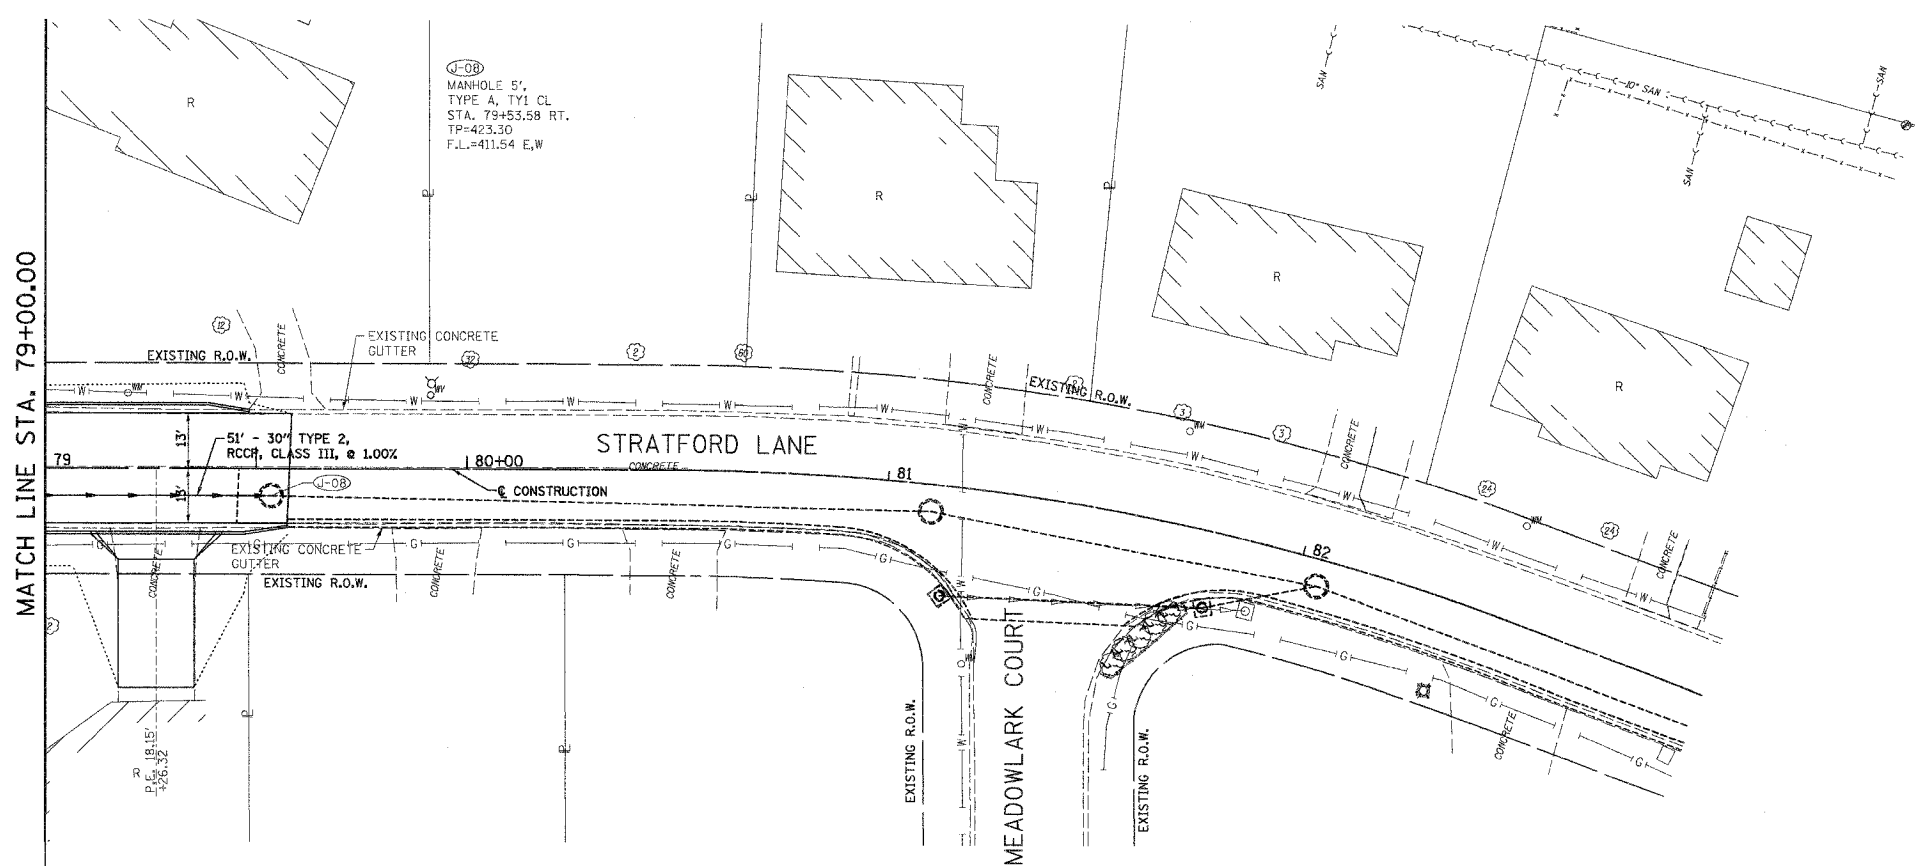

ORIGINAL SURVEY PLOTTED	BY	DATE
NOTE BOOK		
AREAS CHECKED		
NO.		

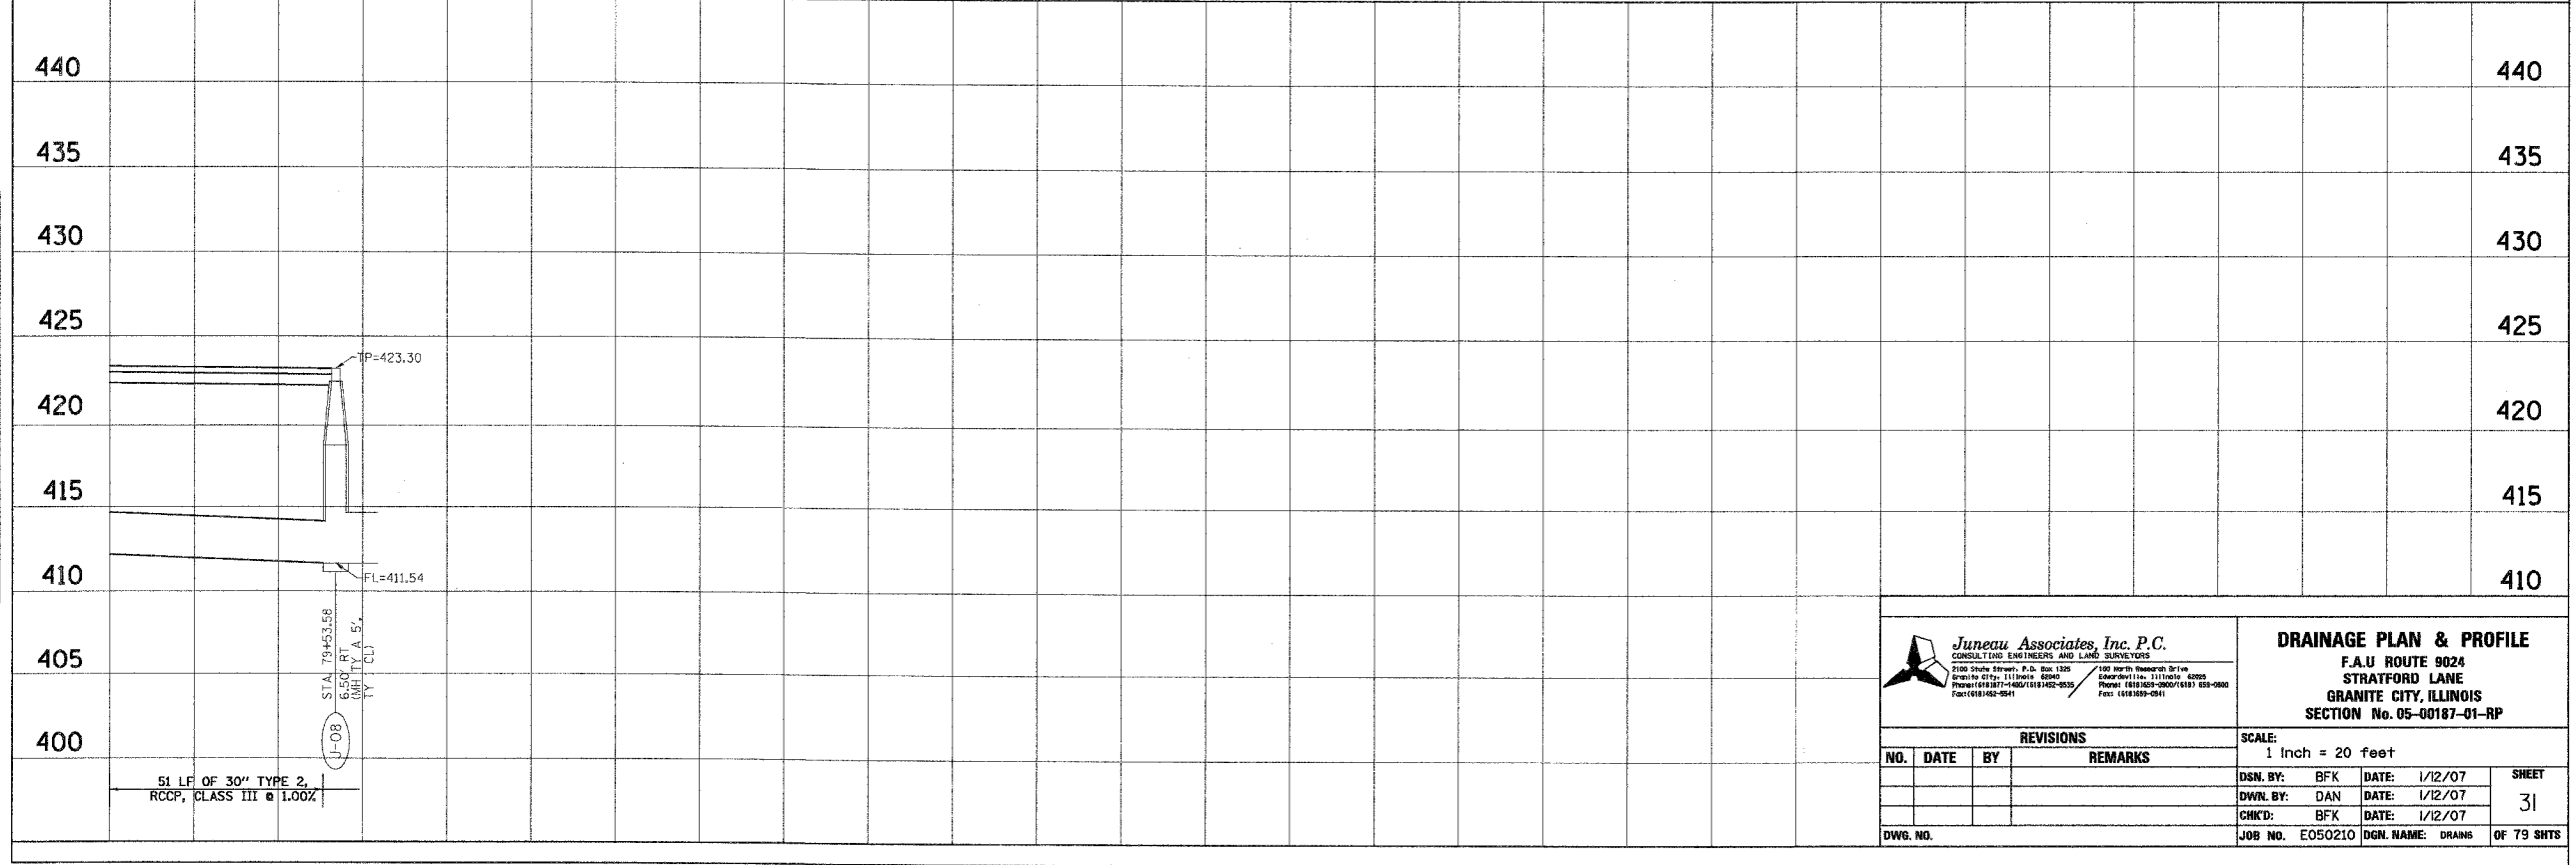

Juneau Associates, Inc. P.C.
CONSULTING ENGINEERS AND LAND SURVEYORS
2100 South Street, P.O. Box 1326
Granite City, Illinois 62040
Phone: (618) 207-1400 / (618) 242-8035
Fax: (618) 242-8541

150 North Research Drive
Granite City, Illinois 62040
Phone: (618) 209-2000 / (618) 628-0880
Fax: (618) 209-0541

DRAINAGE PLAN & PROFILE
F.A.U. ROUTE 9024
STRATFORD LANE
GRANITE CITY, ILLINOIS
SECTION No. 05-00187-01-RP

SCALE:
1 Inch = 20 feet

DSN. BY:	BFK	DATE:	1/12/07	SHEET
DWN. BY:	DAN	DATE:	1/12/07	31
CHK'D:	BFK	DATE:	1/12/07	

DWG. NO. E050210 DGN. NAME: DRAINS OF 79 SHTS