


AR125982 REFURBISH BASE MOUNTED LIGHT
NOT TO SCALE


NOTES:

1. TRANSFORMER HOLDER SHALL BE ANY COMMERCIALY AVAILABLE BRICK.
2. ISOLATION TRANSFORMERS COME WITH A FACTORY INSTALLED PLUG (TYPE 1, CLASS A, STYLE 2) AND RECEPTACLE (TYPE 1, CLASS A, STYLE 9) A TYPE 1, CLASS B, STYLE 3 PLUG AND TYPE 1, CLASS B, STYLE 10 RECEPTACLE SHALL BE INSTALLED ON THE 1/C NO. 8, 5000 V., L-824 TYPE C CABLES FOR CONNECTION TO EACH TRANSFORMER.

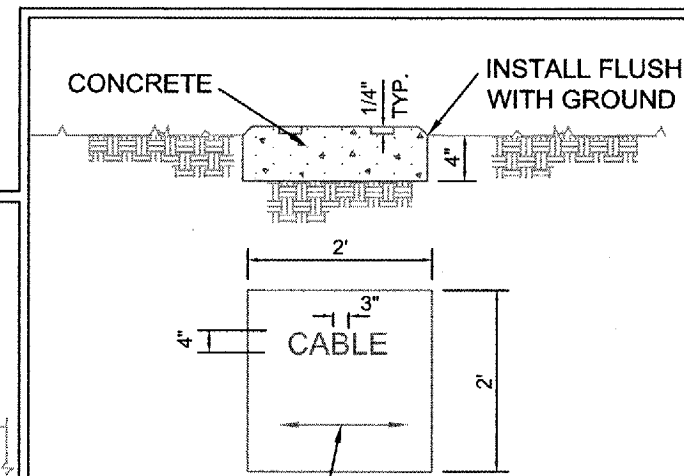

NOTES:

1. CABLE MARKERS SHALL BE INSTALLED AT ALL BENDS AND EVERY 200' ON HOMERUNS.
2. ITEM 610 CONCRETE SHALL BE USED.
3. ALL EXPOSED EDGES SHALL BE EDGED WITH A 1/4" RADIUS TOOL
4. THE COST OF FURNISHING AND INSTALLING NEW MARKERS SHALL BE INCIDENTAL TO THE ASSOCIATED CABLE ITEMS.
5. 0.049 CU. YD. CONCRETE PER MARKER.

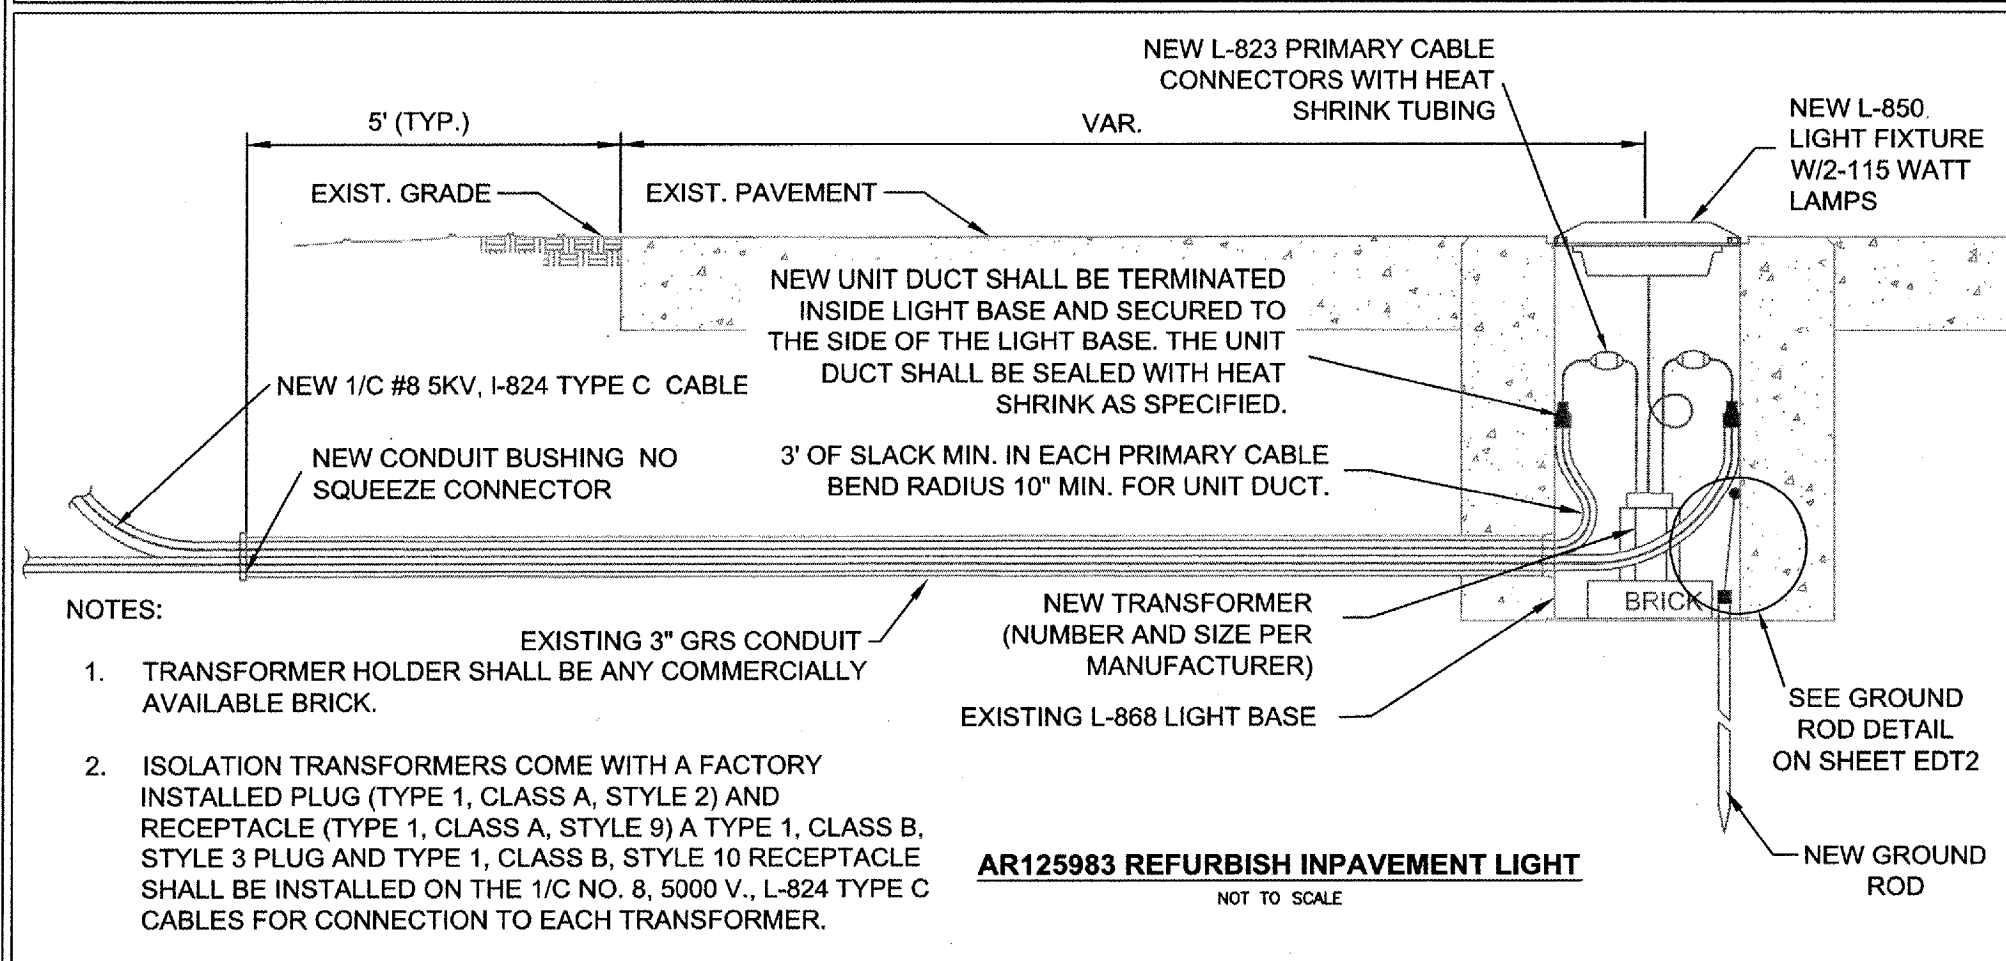

AR125983 REFURBISH INPAVEMENT LIGHT
NOT TO SCALE

NOTES:

1. TRANSFORMER HOLDER SHALL BE ANY COMMERCIALY AVAILABLE BRICK.
2. ISOLATION TRANSFORMERS COME WITH A FACTORY INSTALLED PLUG (TYPE 1, CLASS A, STYLE 2) AND RECEPTACLE (TYPE 1, CLASS A, STYLE 9) A TYPE 1, CLASS B, STYLE 3 PLUG AND TYPE 1, CLASS B, STYLE 10 RECEPTACLE SHALL BE INSTALLED ON THE 1/C NO. 8, 5000 V., L-824 TYPE C CABLES FOR CONNECTION TO EACH TRANSFORMER.

WH006



Whiteside County **AIRPORT**
JOSEPH H. BITTORF FIELD

Whiteside County
Airport

Sterling / Rock Falls,
Illinois

Whiteside County
Airport AIP:
3-17-0098-XX
SQI-3694

Recable Airfield

**FINAL
SUBMITTAL**

Revisions

Date	Description

0 1
THIS BAR IS EQUAL TO 1"
AT FULL SCALE (17 X 11).

DESIGN BY:	CMT- RFD
DRAWN BY:	CMT- RFD
CHECKED BY:	CMT- RFD
APPROVED BY:	JGP
DATE:	4.20.2007
JOB No:	06292-03-00

**ELECTRICAL
DETAILS 1
RUNWAY 7/25
(EDR1)**

**ELECTRICAL DETAILS 1
RUNWAY 7/25**

18