


IL. RTE. 50 (CICERO AVENUE)

CITY OF CHICAGO | VILLAGE OF STICKNEY
WEST SIDE OF CICERO AVE.

39TH STREET (PERSHING ROAD)

EDMIER ROAD

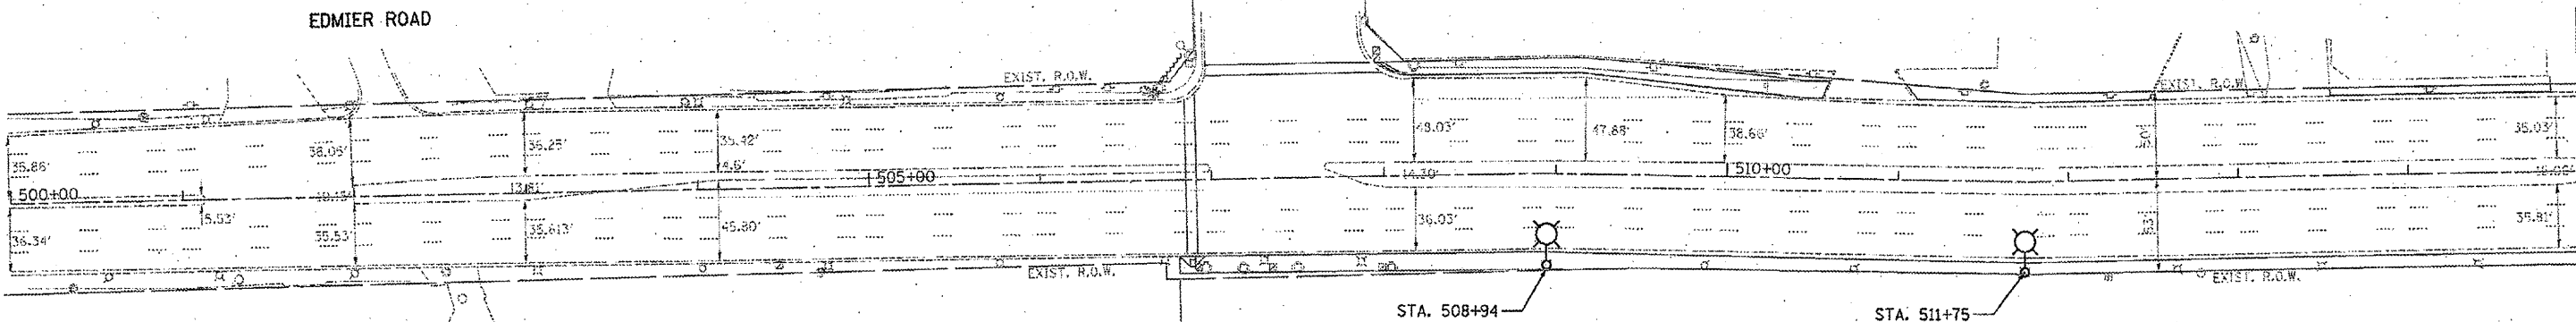


BEGIN PROJECT
STA. 506+80.60

CITY OF CHICAGO | TOWN OF CICERO
EAST SIDE OF CICERO AVE.

MATCHLINE STA. 515+00

IL. RTE. 50 (CICERO AVENUE)

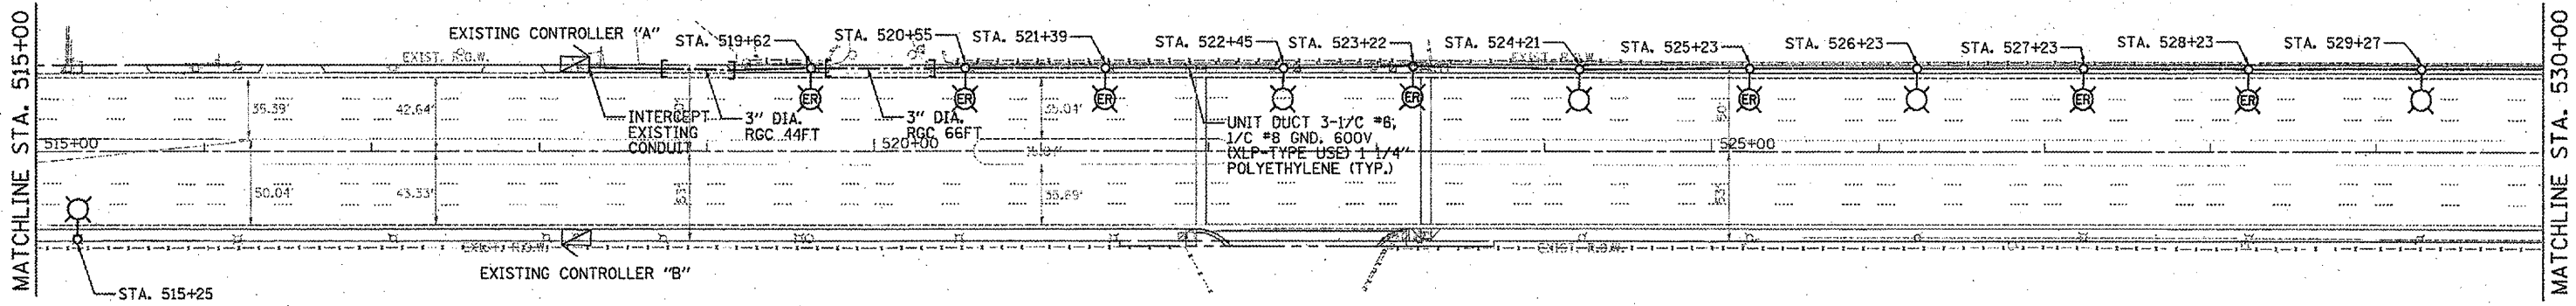

NOTE:

THE ENVIRONMENTAL FIRM IS REQUIRED TO CONTINUOUSLY MONITOR FOR WORKER PROTECTION AND SOIL CONTAMINATION AT SEVERAL AREAS. SEE SPECIAL PROVISION AND SUPPLEMENTAL SPECIFICATIONS FOR DETAILS.

FILE NAME #	USER NAME #	DESIGNED - MK	REVISED -	STATE OF ILLINOIS DEPARTMENT OF TRANSPORTATION	IL RTE. 50 (CICERO AVE.) - (34TH STREET TO PERSHING ROAD) PROPOSED LIGHTING PLAN	F.A.P. RTE. 350	SECTION 2010-050-1	COUNTY COOK	TOTAL SHEETS 44	SHEET NO. 19		
#FILES#		DRAWN - YJ	REVISED -			SCALE: 1"= 80'	SHEET NO. OF SHEETS	STA. 500+00.00 TO STA. 530+00.00	CONTRACT NO. 60L26			
		CHECKED - GR	REVISED -			ILLINOIS FED. AID PROJECT						
		DATE - 10/14/11	REVISED -									