

VILLAGE OF STICKNEY | TOWN OF CICERO
 WEST SIDE OF CICERO AVE.


NOTE:

THE ENVIRONMENTAL FIRM IS REQUIRED TO CONTINUOUSLY MONITOR FOR WORKER PROTECTION AND SOIL CONTAMINATION AT SEVERAL AREAS. SEE SPECIAL PROVISION AND SUPPLEMENTAL SPECIFICATIONS FOR DETAILS.

IL. RTE. 50 (CICERO AVENUE)



END PROJECT
 STA. 544+44.44

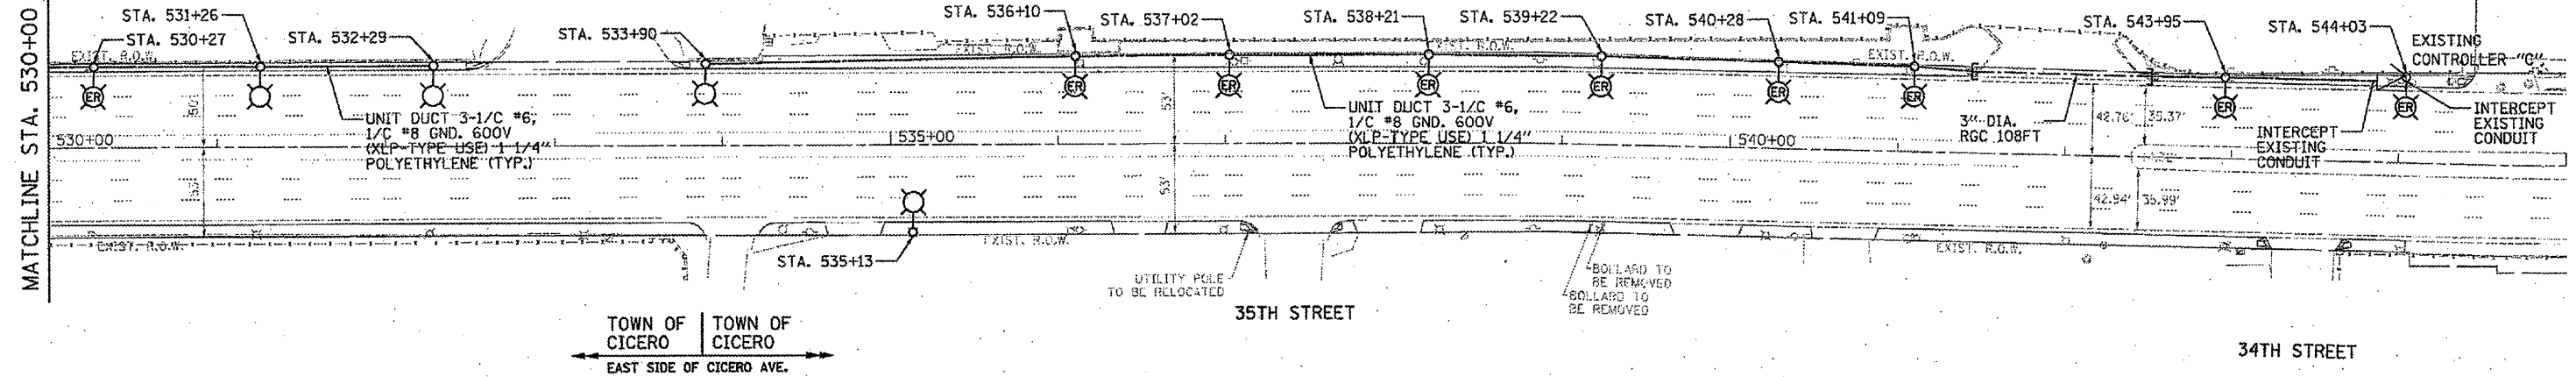

FILE NAME =	USER NAME = #USER#	DESIGNED - MK	REVISED -	STATE OF ILLINOIS DEPARTMENT OF TRANSPORTATION	IL RTE. 50 (CICERO AVE.) - (34TH STREET TO PERSHING ROAD) PROPOSED LIGHTING PLAN	F.A.P. RTE. 350	SECTION 2010-050-1	COUNTY COOK	TOTAL SHEETS 44	SHEET NO. 20		
#FILES#	PLOT SCALE = #SCALE#	DRAWN - YJ	REVISED -			SCALE: 1"= 50'	SHEET NO. OF SHEETS	STA. 530+00.00 TO STA. 545+00.00	ILLINOIS FED. AID PROJECT			
	PLOT DATE = #DATE#	CHECKED - GR	REVISED -						CONTRACT NO. 60L26			
		DATE - 10/14/11	REVISED -									