
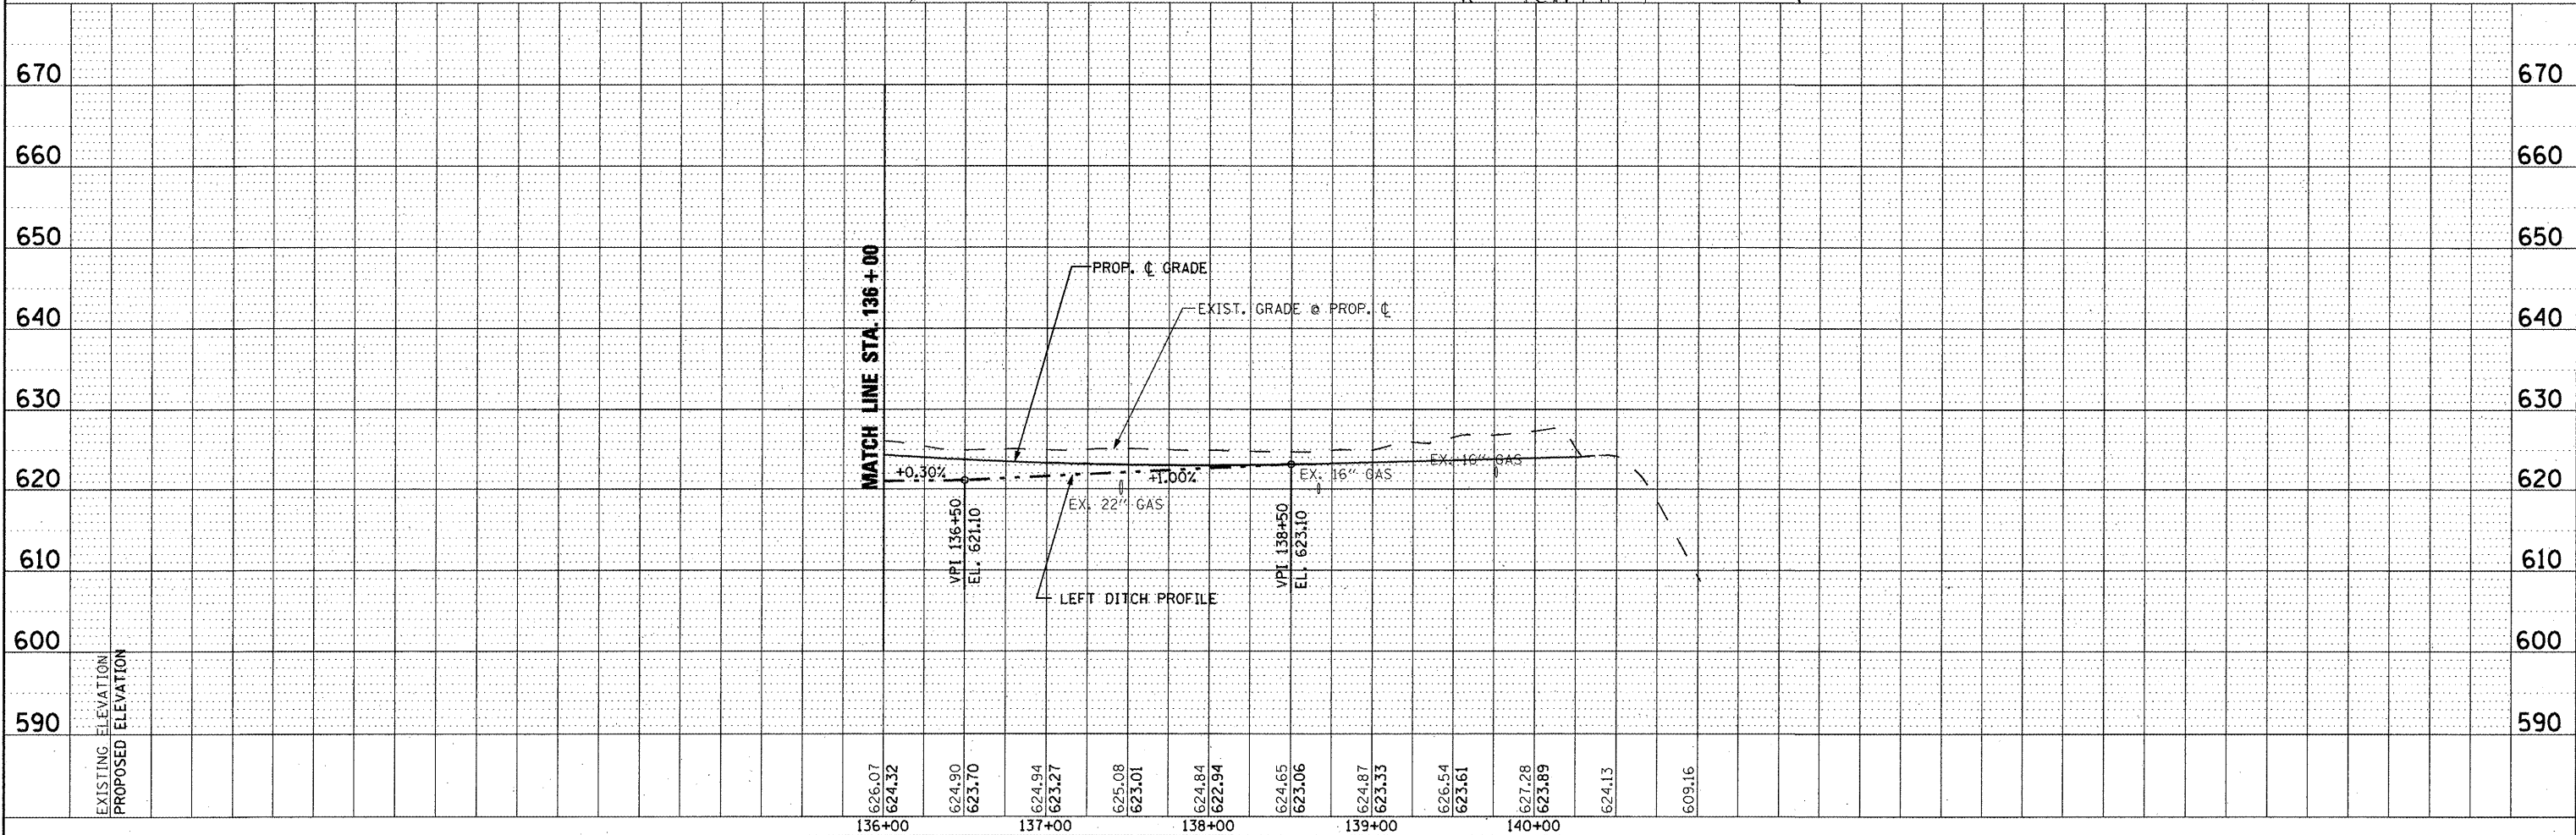
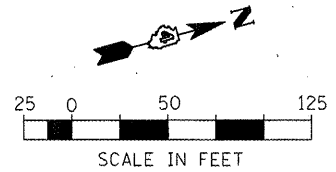


PLAN	DATE
BY	
DESIGNED	
CHECKED	
DATE	
PROJECT	
NO.	

PROFILE	DATE
BY	
DESIGNED	
CHECKED	
DATE	
PROJECT	
NO.	

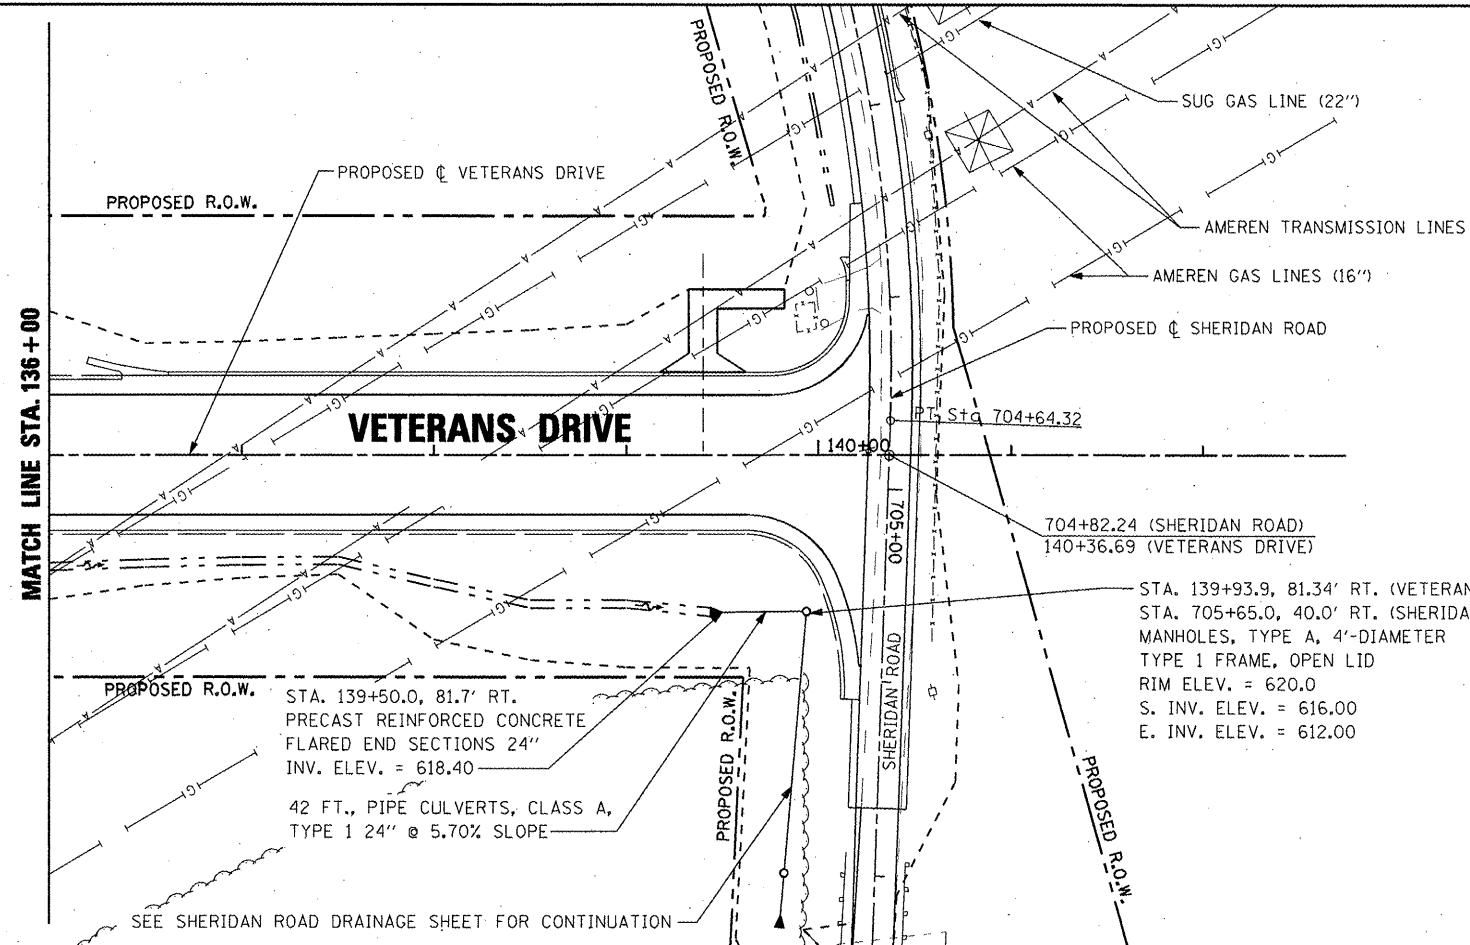

FILE NAME =	USER NAME = IDDT	DESIGNED <i>REW/KRS</i>	REVISED -	STATE OF ILLINOIS DEPARTMENT OF TRANSPORTATION	VETERANS DRIVE IMPROVEMENTS DRAINAGE PLAN AND PROFILE - LEFT	F.A.U. RTE.	SECTION	COUNTY	TOTAL SHEETS	SHEET NO.
DR 136-140 LT.dgn	DRAWN <i>CAM</i>	REVISED -	6768			10-00169-00-RP	TAZEWELL	98	36	
PLOT SCALE = 100.0000' / IN.	CHECKED <i>KMC</i>	REVISED -	CONTRACT NO. 89588							
PLOT DATE = 4/12/2012	DATE <i>3-21-12</i>	REVISED -	ILLINOIS FED. AID PROJECT							