
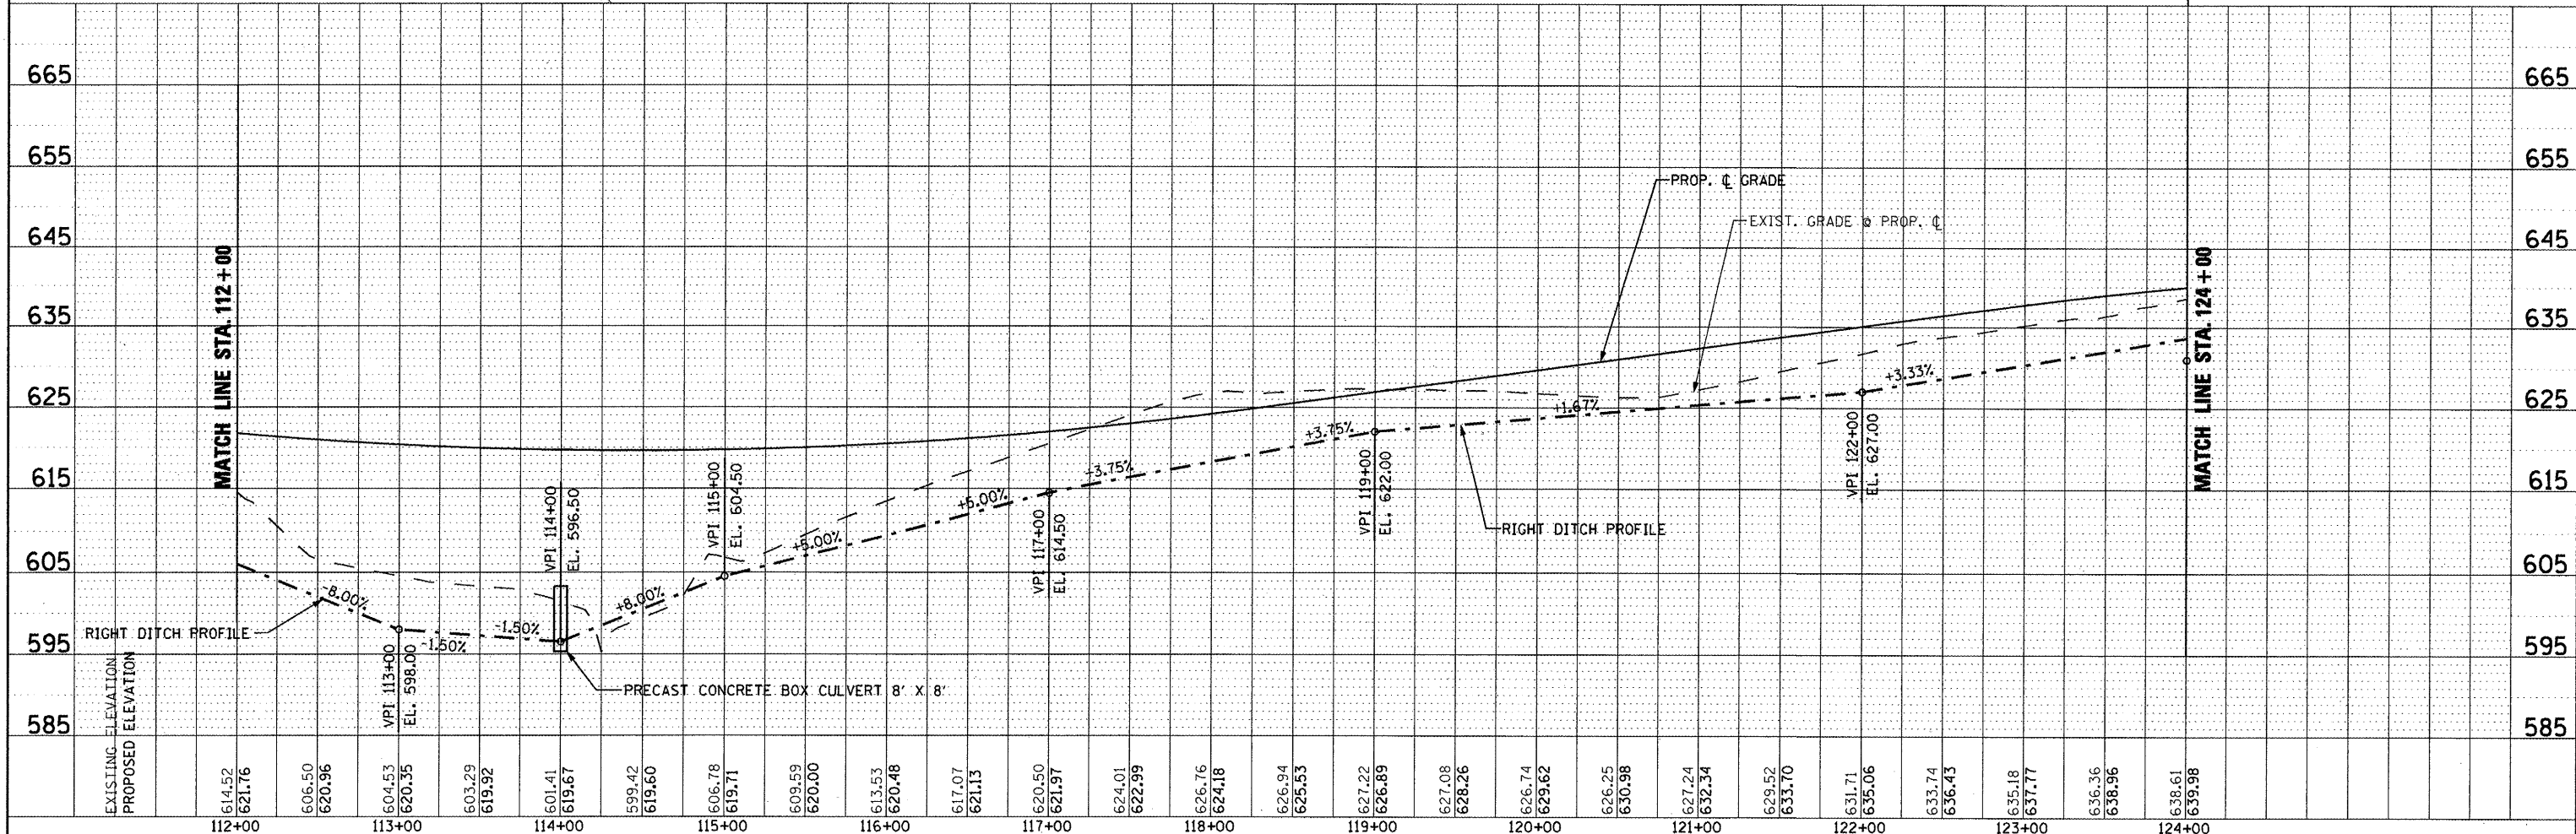
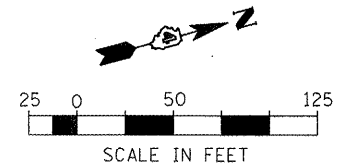


DATE	
BY	
DESIGNED	
PLANNED	
ALIGNED	
CHECKED	
NO. _____	
NOTE BOOK	
NO. _____	
FILE NAME	

DATE	
BY	
DESIGNED	
PLANNED	
ALIGNED	
CHECKED	
NO. _____	
NOTE BOOK	
NO. _____	
FILE NAME	

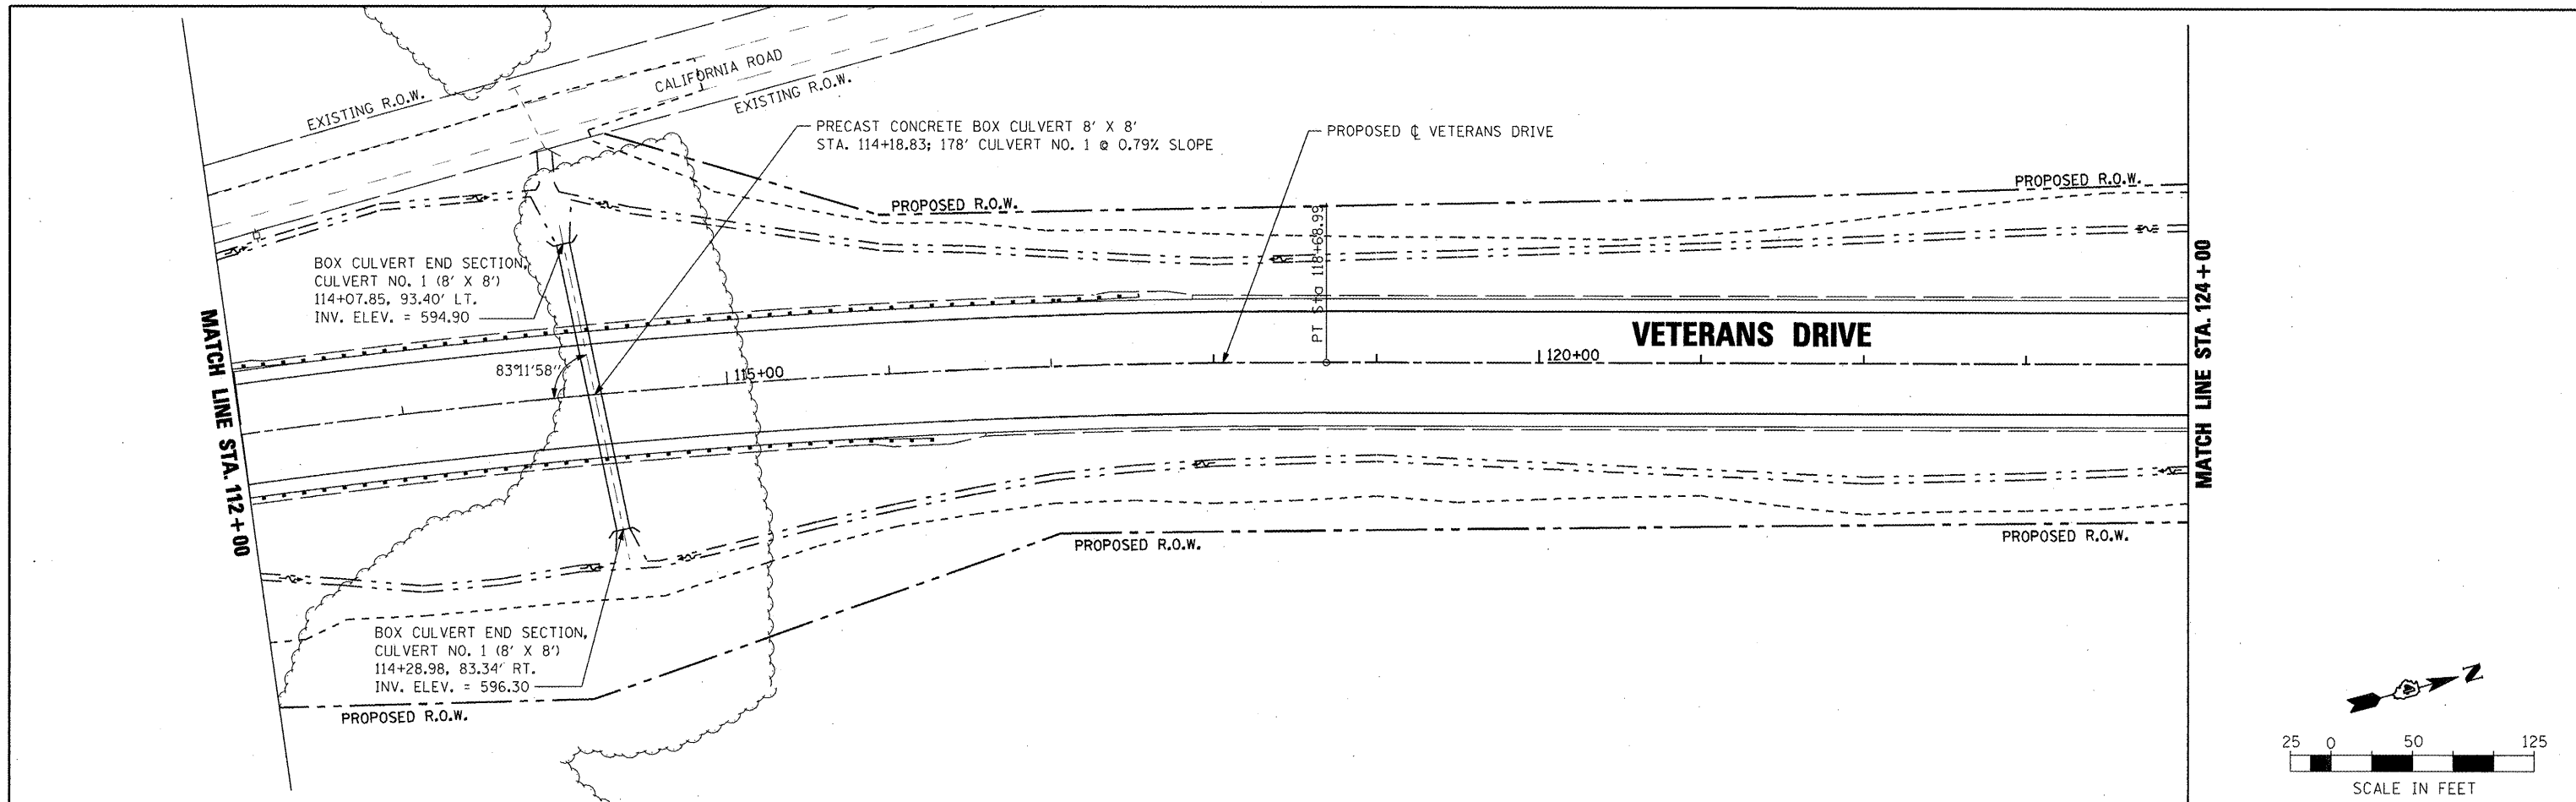

FILE NAME =	USER NAME = IDDT	DESIGNED <i>REW/KRS</i>	REVISED -	STATE OF ILLINOIS DEPARTMENT OF TRANSPORTATION	VETERANS DRIVE IMPROVEMENTS DRAINAGE PLAN AND PROFILE - RIGHT	F.A.U. RTE.	SECTION	COUNTY	TOTAL SHEETS	SHEET NO.
W:\projects\200805025\dn\plans and xref\DR 112-124 RT.dgn	DRAWN <i>CAM</i>	REVISED -	6768			10-00169-00-RP	TAZEWELL	98	38	
PLOT SCALE = 100.000000' / IN.	CHECKED <i>KMC</i>	REVISED -	CONTRACT NO. 89588							
PLOT DATE = 4/12/2012	DATE <i>3-21-12</i>	REVISED -	ILLINOIS FED. AID PROJECT							
SCALE:		SHEET NO. OF SHEETS		STA. 112+00 TO STA. 124+00						