
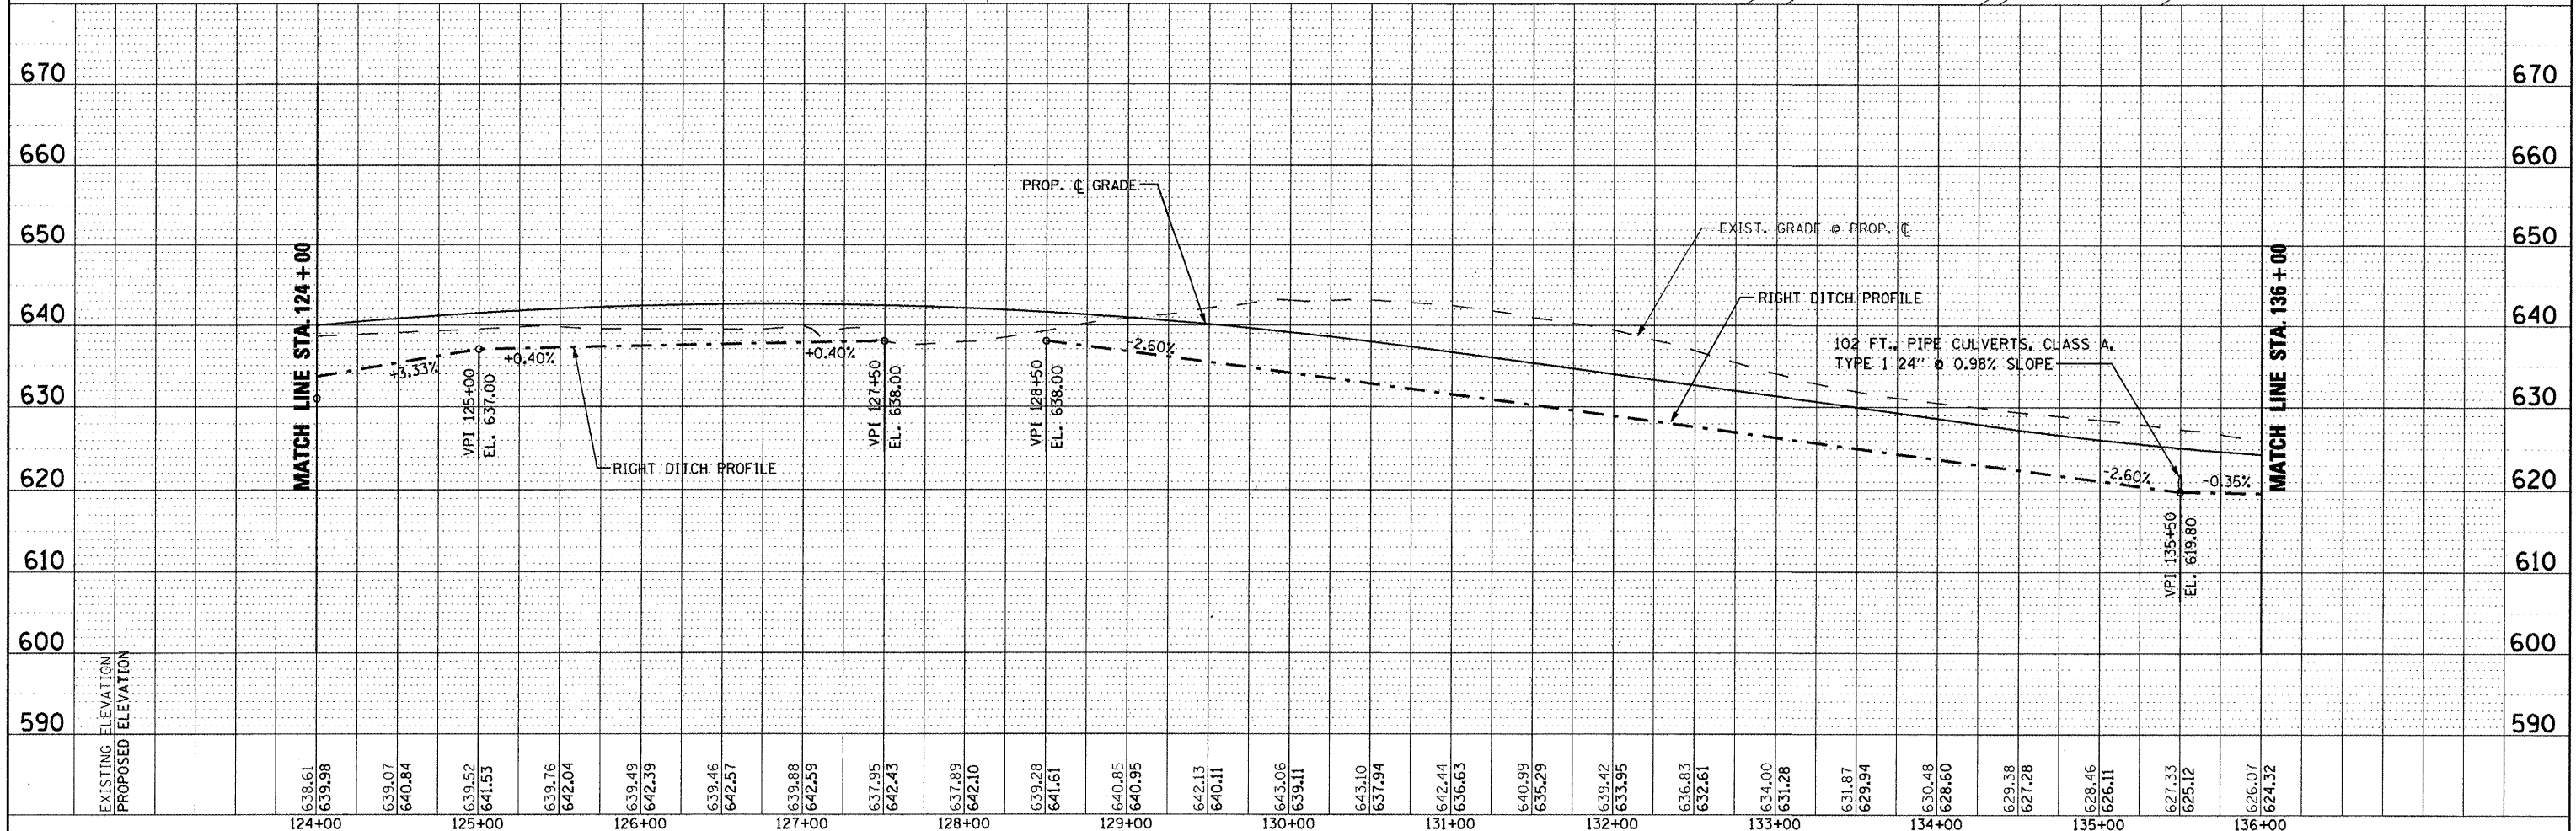
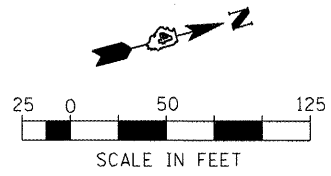


PLAN	NO.
REVISIONS	DATE
NOTED	
CHECKED	
DATE	

PROFILE	NO.
REVISIONS	DATE
NOTED	
CHECKED	
DATE	

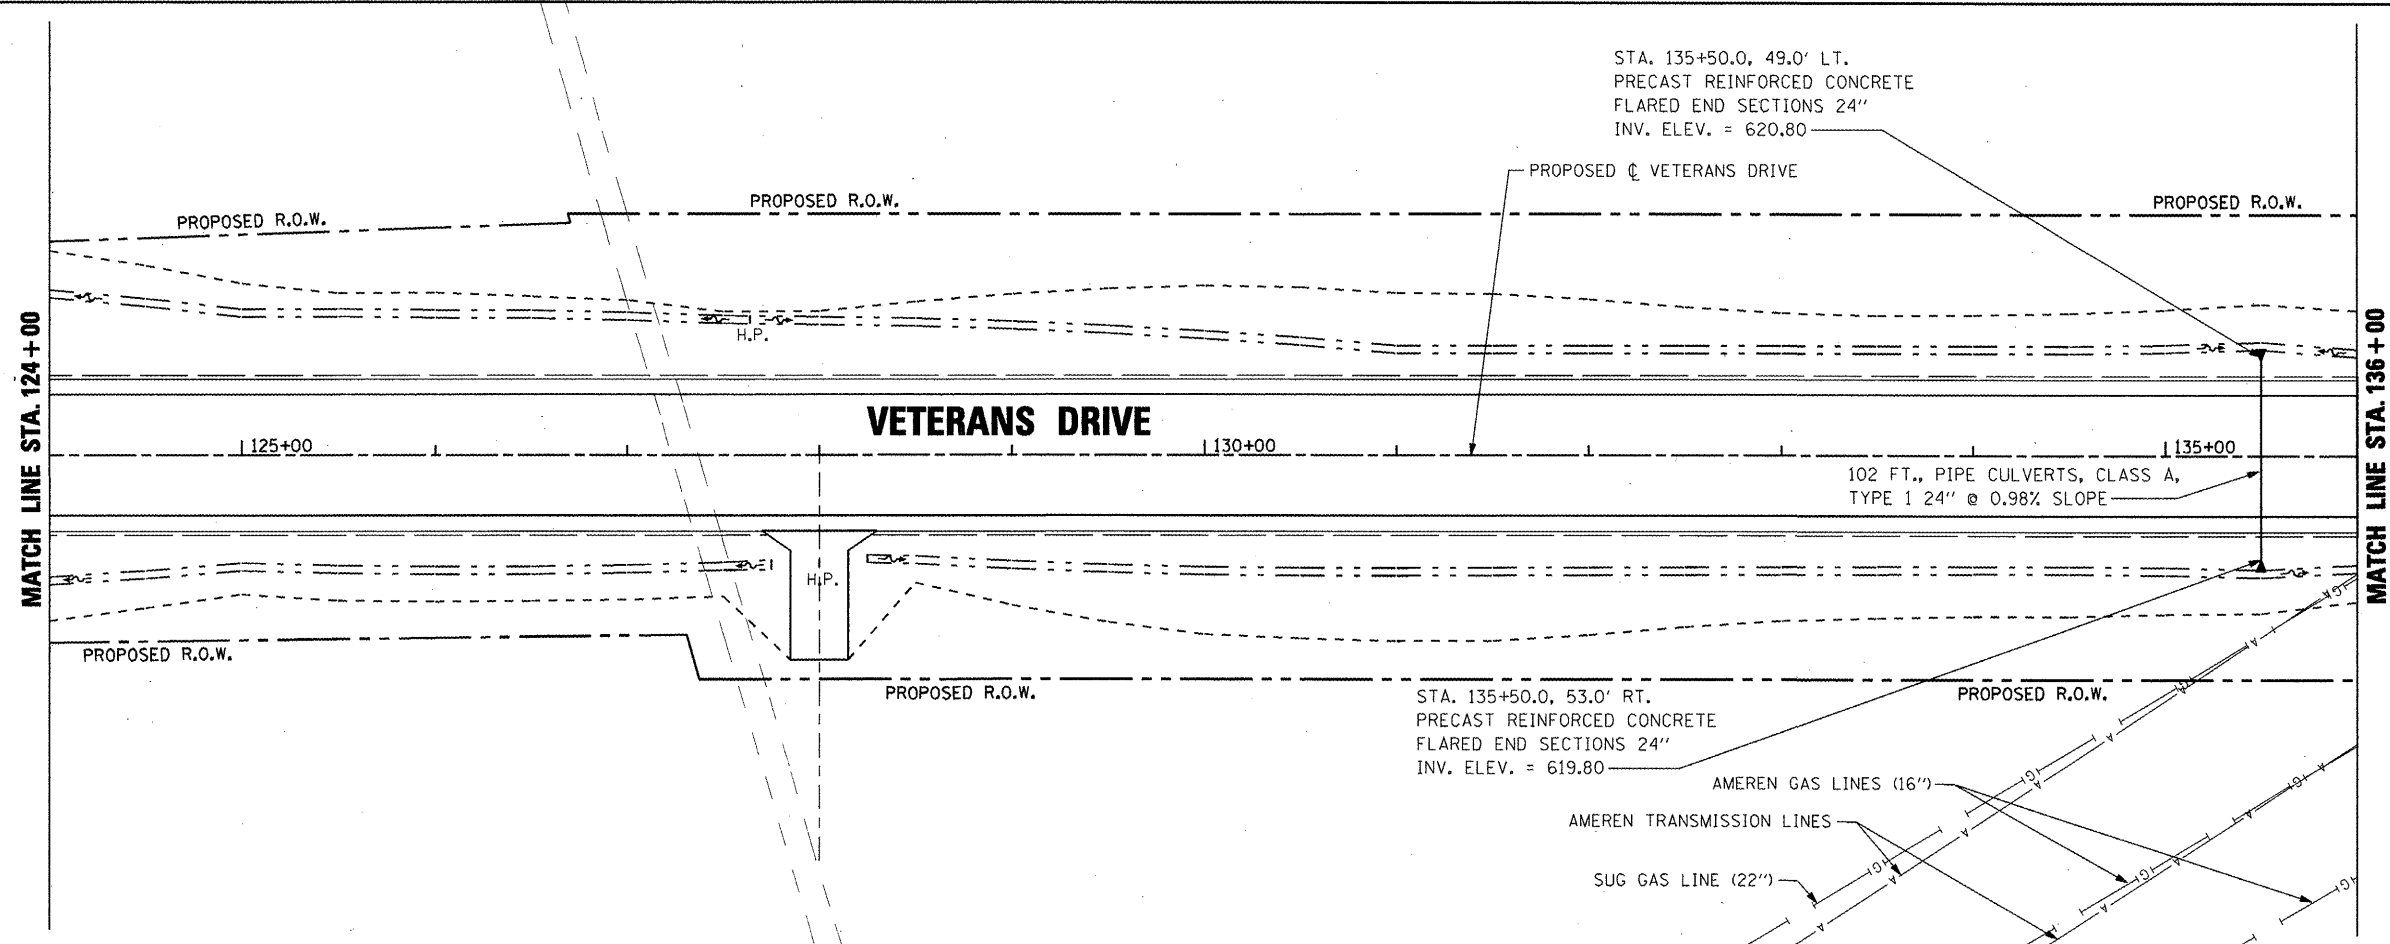

FILE NAME =	USER NAME = IDDT	DESIGNED <i>REW/KRS</i>	REVISED -	STATE OF ILLINOIS DEPARTMENT OF TRANSPORTATION	VETERANS DRIVE IMPROVEMENTS DRAINAGE PLAN AND PROFILE - RIGHT	F.A.U. RTE.	SECTION	COUNTY	TOTAL SHEETS	SHEET NO.	
PROJECT NO. = 100.0000	DATE = 4/12/2012	DRAWN <i>CAM</i>	REVISED -			6768	10-00169-00-RP	TAZEWELL	98	39	
PLOT SCALE = 1/8" = 1'	DATE = 3-21-12	CHECKED <i>KMC</i>	REVISED -			CONTRACT NO. 89588					
						ILLINOIS FED. AID PROJECT					