

F.A.U. ROUTE	SECTION	COUNTY	TOTAL SHEETS	SHEET NUMBER
9910	10-00050-00-RS	UNION	16	1
CITY OF ANNA		PROJECT NO. M-5080(006)		
CONTRACT NO. 99470		JOB NO. C99-542-10		



STATE OF ILLINOIS
DEPARTMENT OF TRANSPORTATION
DIVISION OF HIGHWAYS
PLANS FOR PROPOSED
FEDERAL - AID URBAN PROJECT
CITY OF ANNA
F.A.U. ROUTE 9910
SECTION 10-00050-00-RS
UNION COUNTY
JOB NO. C99-542-10
PROJECT NO. M-5080(006)
CONTRACT NO. 99470
IMPROVEMENTS TO EAST DAVIE STREET

INDEX OF SHEETS

SHEET NO	DESCRIPTION
1	TITLE AND COVER SHEET INDEX OF SHEETS, LOCATION MAP
2	TYPICAL SECTIONS, SUMMARY OF QUANTITIES
3	DETAILS - STORM WATER
4	CONSTRUCTION LAYOUT AND STORM SEWER PLAN
5	REMOVAL PLAN - INTERSECTION DETAIL
6	PLAN AND PROFILE
7	STORM WATER POLLUTION PREVENTION PLAN - TRAFFIC CONTROL PLAN
8	PAVEMENT MARKING PLAN
9	ELECTRICAL SITE PLAN
10	SERVICE DETAILS - ELECTRICAL NOTES - LIGHT FOUNDATIONS
11-16	CROSS SECTIONS

LIST OF HIGHWAY STANDARDS

HIGHWAY STANDARD NO.	TITLE
424001-06	PERPENDICULAR CURB RAMPS FOR SIDEWALKS
424006	DIAGONAL CURB RAMPS FOR SIDEWALKS
424011	CORNER PARALLEL CURB RAMPS FOR SIDEWALKS
424021	DEPRESSED CORNER FOR SIDEWALKS
602301-03	INLET - TYPE A
602401-03	MANHOLE TYPE A
602801-02	PRECAST REINFORCED CONCRETE FLAT SLAB TOP
602701-02	MANHOLE STEPS
604001-03	FRAME AND LIDS TYPE 1
604066-02	FRAME AND LID TYPE 15
606001-04	CONCRETE CURB TYPE B AND COMBINATION CONCRETE CURB AND GUTTER
701001-02	OFF-RD OPERATIONS, 2L, 2W, MORE THAN 15' (4.5 M) AWAY
701006-03	OFF-RD OPERATIONS, 2L 2W, 15' (4.5 M) TO 24" (600 MM) FROM PAVEMENT EDGE
701011-02	OFF-RD MOVING OPERATIONS, 2L, 2W, DAY ONLY
701201-04	LANE CLOSURE, 2L, 2W, DAY ONLY, FOR SPEEDS ≥ 45 MPH
701301-04	LANE CLOSURE, 2L, 2W, SHORT TIME OPERATIONS
701311-03	LANE CLOSURE 2L, 2W MOVING OPERATIONS-DAY ONLY
701502-04	URBAN LANE CLOSURE, 2L, 2W, WITH BIDIRECTIONAL LEFT TURN LANE
701901-02	TRAFFIC CONTROL DEVICES
720001-01	SIGN PANEL MOUNTING DETAILS
720006-03	SIGN PANEL ERECTION DETAILS
720001-01	METAL POSTS FOR SIGNS, MARKERS & DELINEATORS
729001-01	APPLICATIONS OF TYPES A & B METAL POSTS (FOR SIGNS & MARKERS)
888001-01	DETECTOR LOOP INSTALLATIONS
888006-01	TYPICAL LAYOUTS FOR DETECTION LOOPS
B.L.R. 17-4	TRAFFIC CONTROL DEVICES - DAY LABOR CONSTRUCTION

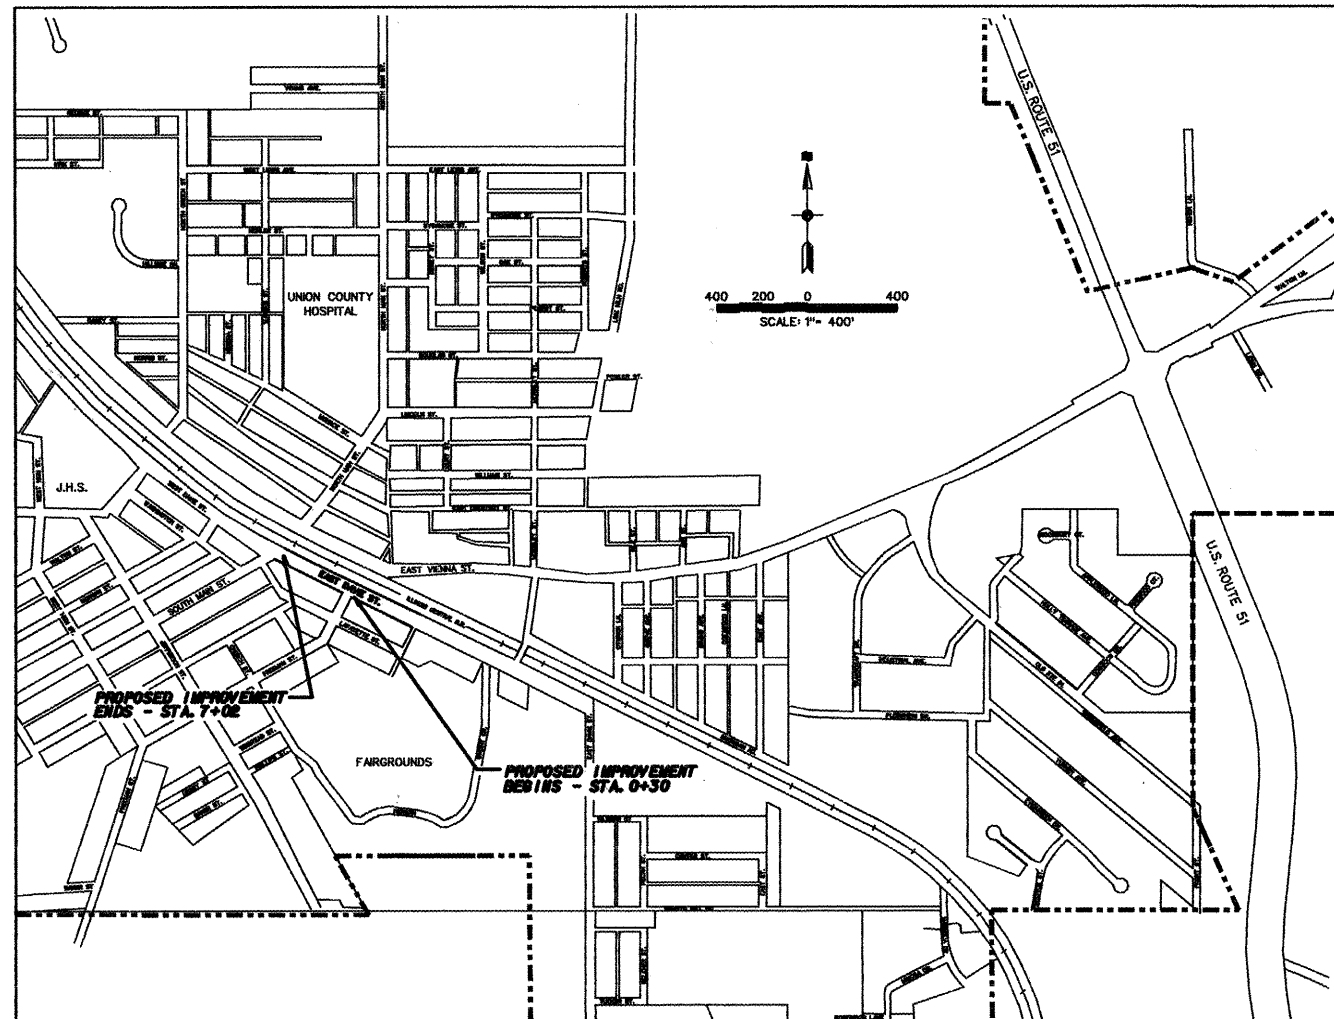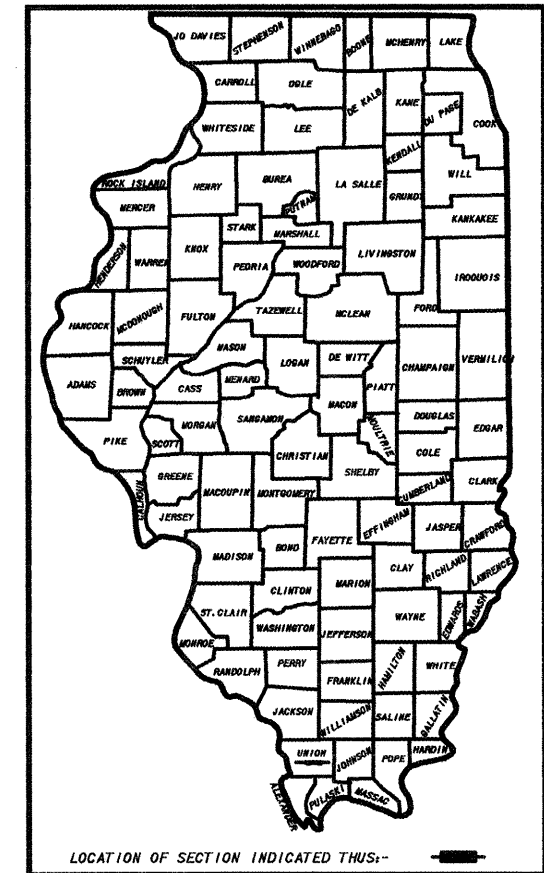

CITY OF ANNA

LAYOUT
 APPROXIMATE SCALE: 1 INCH = 400 FT.
 NET LENGTH OF PROJECT - 672 FT. - 0.127 M.


UTILITIES ON PROJECT

- | | |
|--------------------------------------|---------------------|
| CITY OF ANNA | - GAS, WATER, SEWER |
| AMEREN ILLINOIS COMPANY, MARION, IL. | - ELECTRIC |
| FRONTIER, MARION, IL. | - TELEPHONE |
| NEW WAVE COMMUNICATIONS, ANNA, IL. | - CABLE TV |

SCALES

PLAN	1 INCH = 20 FEET
PROFILE	1 INCH = 20 FEET HORIZ. 1 INCH = 5 FEET VERT.
CROSS SECTIONS	1 INCH = 5 FEET HORIZ. 1 INCH = 5 FEET VERT.

SCALE AS SHOWN	J. T. BLANKINSHIP, INC. CONSULTING ENGINEERS & LAND SURVEYORS ILLINOIS PROFESSIONAL DESIGN FIRM NO. 1504 P.O. BOX 40 401 S. 17TH STREET MURPHYSBORO, ILLINOIS 62569	FILE NO. E-9394
DATE FEB., 2012		SHEET NO.

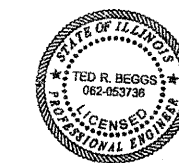

Ted R. Beggs
 TED R. BEGGS P.E.
 REG. NO. 062-053736
 DATE 04/12/12
 EXPIRES 11-30-13

DESIGN SPEED - 20 M.P.H.
 CLASSIFICATION - COLLECTOR
 A.D.T. - 3,500
 J.U.L.I.E. - 1-800-892-0123

STATE OF ILLINOIS DEPARTMENT OF TRANSPORTATION	
APPROVED	04-13 2012 <i>James Cross</i> JAMES CROSS - MAYOR CITY OF ANNA
PASSED	4/18 2012 <i>Dennis Hillebrunner</i> DENNIS HILLEBRUNNER - DISTRICT 9 ENGINEER OF LOCAL ROADS & STREETS
RELEASING FOR BID BASED ON LIMITED REVIEW	4/18 2012 <i>Omer Demas</i> OMER DEMAS - DEPUTY DIRECTOR OF HIGHWAYS, REGION 5 ENGINEER