


F.A. RTE.	SECTION	COUNTY	TOTAL SHEETS	SHEET NO.
*	2004-025-RS	LAKE	116	52
STA.		TO STA.		
FED. ROAD DIST. NO.		ILLINOIS FED. AID PROJECT		
* PARK ROADS		CONTRACT NO. 62745		
		IDNR FILE NO. 2-03-025		

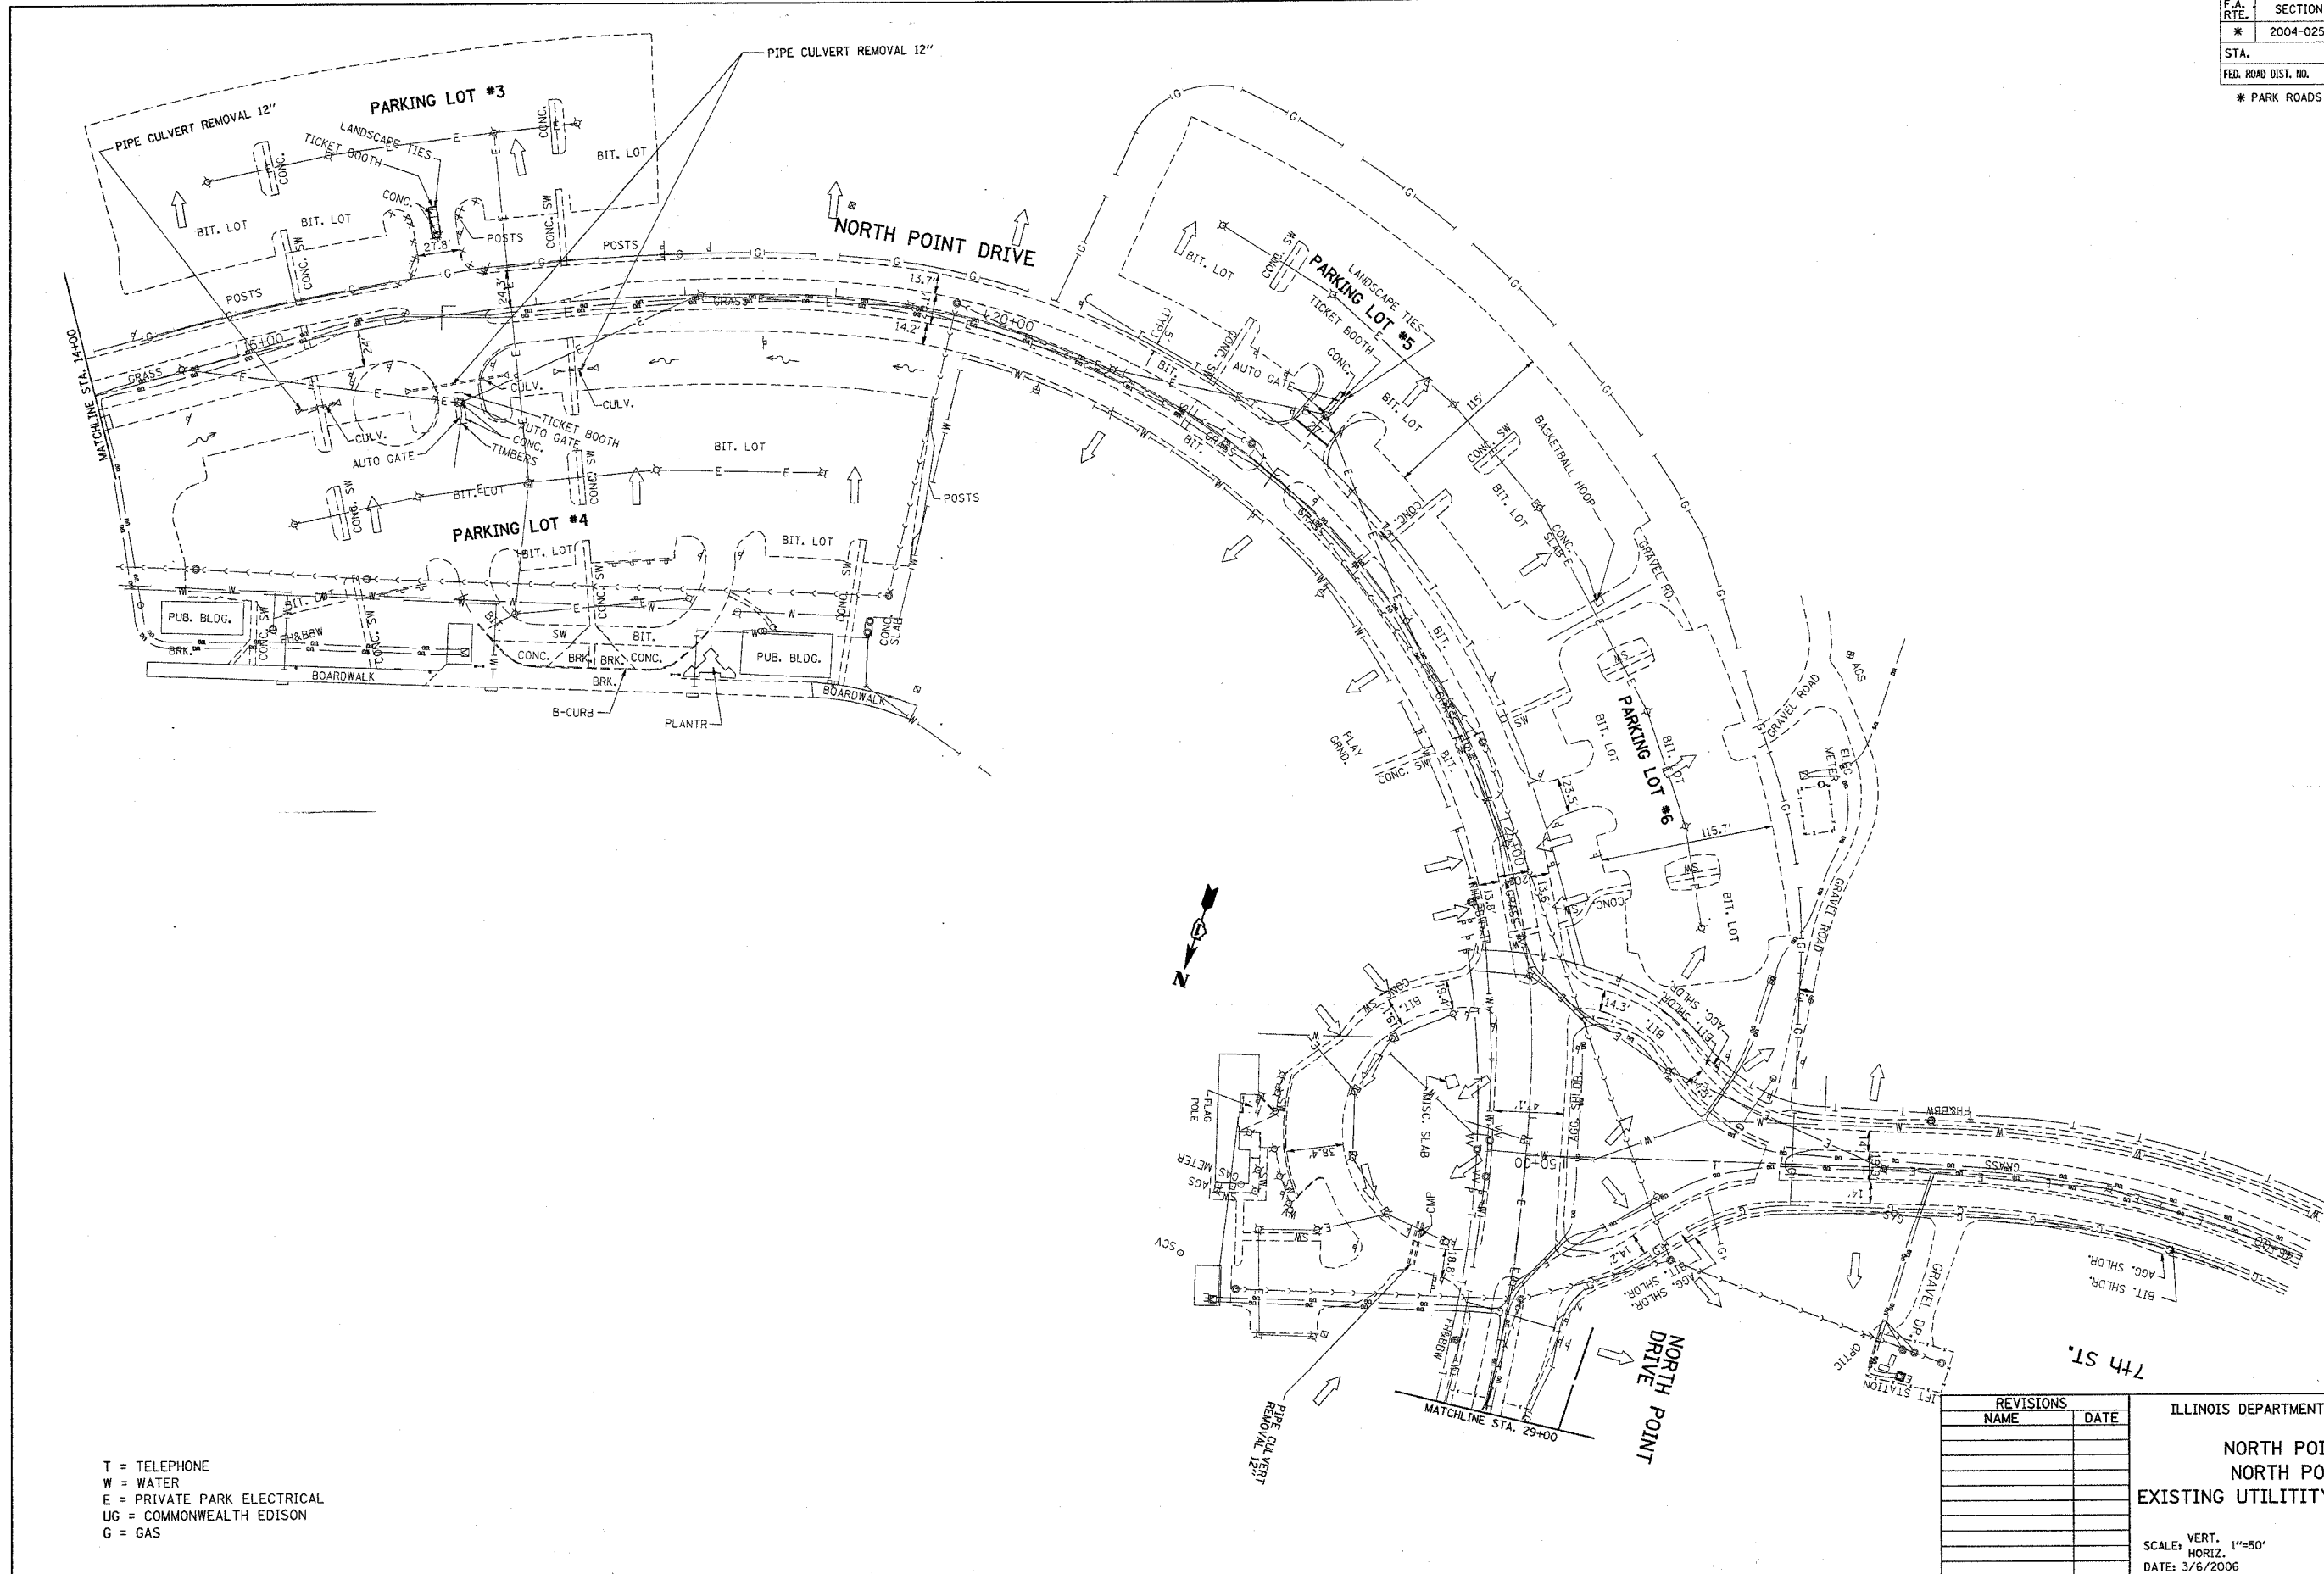

PLOT DATE = 3/6/2006
 FILE NAME = c:\projects\2004\025\ah.dwg
 PLOT SCALE = 1/8\"/>

T = TELEPHONE
 W = WATER
 E = PRIVATE PARK ELECTRICAL
 UG = COMMONWEALTH EDISON
 G = GAS

REVISIONS	
NAME	DATE

ILLINOIS DEPARTMENT OF TRANSPORTATION
NORTH POINT MARINA
NORTH POINT DRIVE
EXISTING UTILITY & DRAINAGE PLAN
 SCALE: VERT. 1"=50'
 HORIZ. 1"=50'
 DATE: 3/6/2006
 DRAWN BY _____
 CHECKED BY _____