
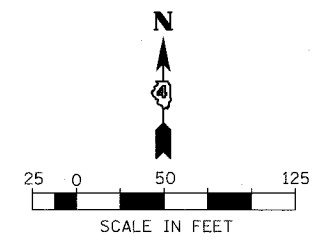
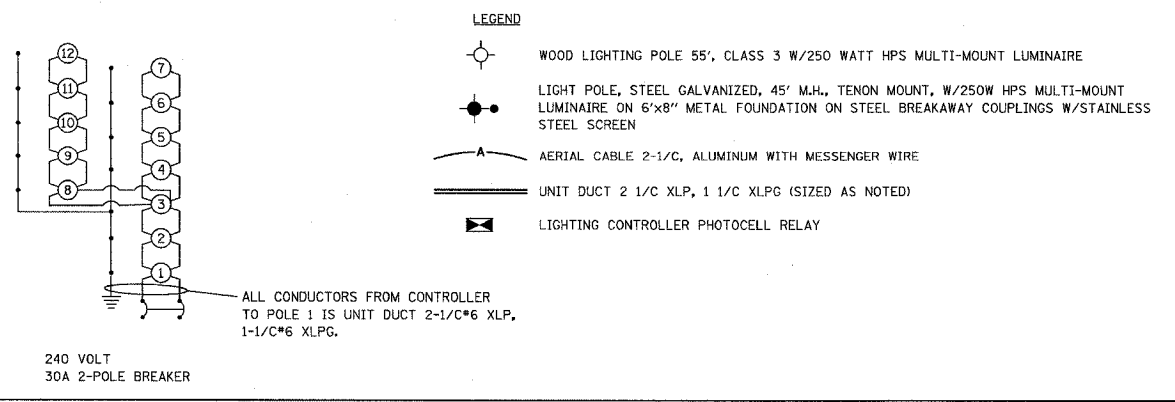
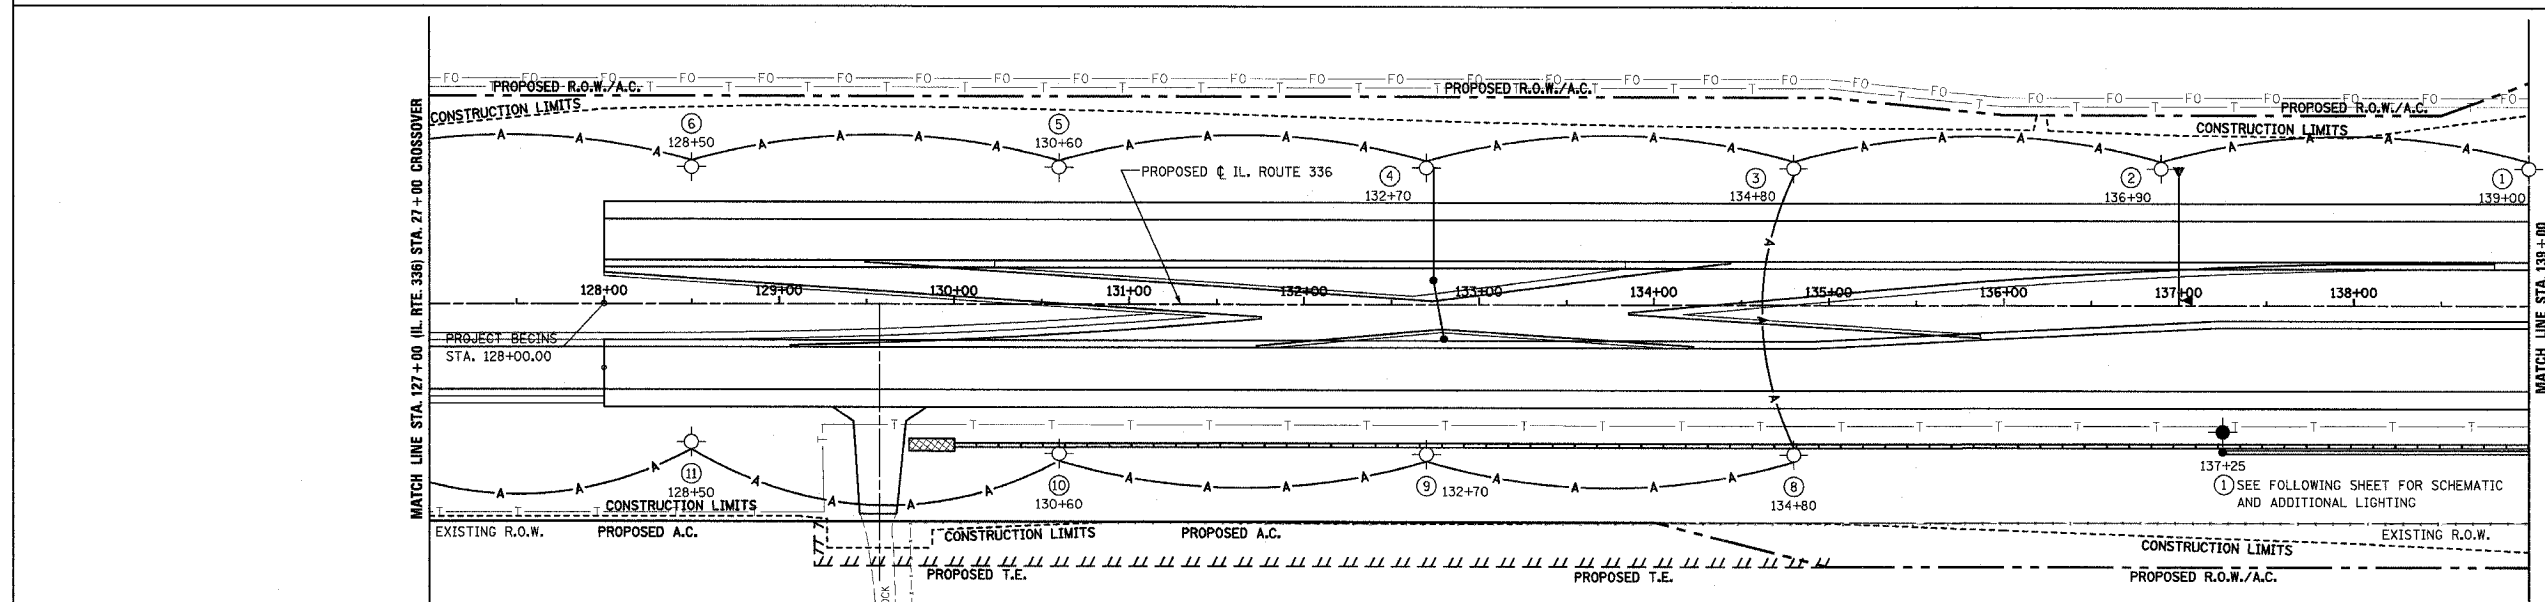


F.A.P. RTE.	SECTION	COUNTY	TOTAL SHEETS	SHEET NO.
315	55-2	McDONOUGH	1025	425
STA. 116+00		TO STA. 139+00		
FED. ROAD DIST. NO. 4 ILLINOIS FED. AID PROJECT				

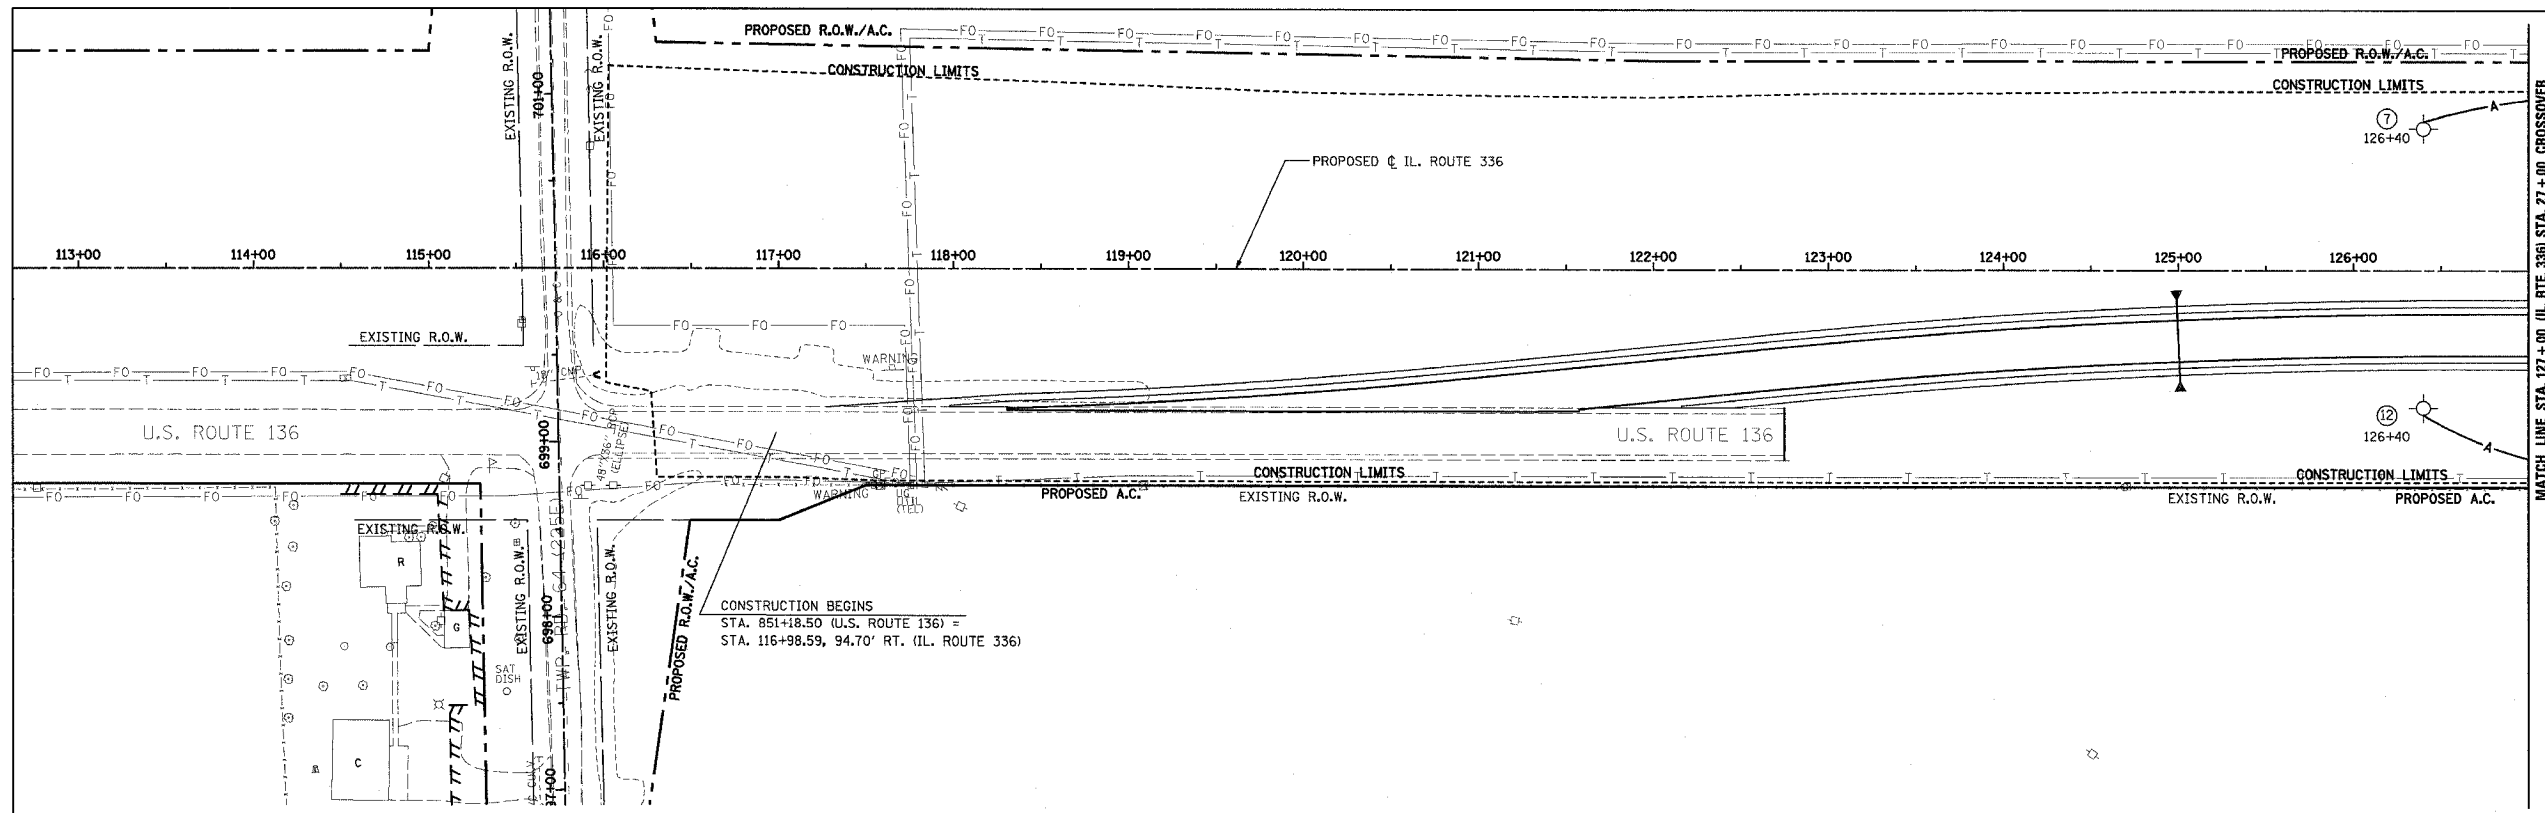

REVISIONS	
NAME	DATE

ILLINOIS DEPARTMENT OF TRANSPORTATION
LIGHTING PLAN
IL. ROUTE 336
STA. 116+00 TO STA. 139+00
 DATE 3/30/06
 DRAWN BY
 CHECKED BY

3/30/06 7:45:15 AM