

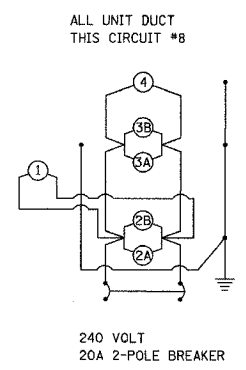


F.A.P. RTE.	SECTION	COUNTY	TOTAL SHEETS	SHEET NO.
315	55-2	McDONOUGH	1025	427
STA. 163+00		TO STA. 187+00		
FED. ROAD DIST. NO. 4		ILLINOIS FED. AID PROJECT		

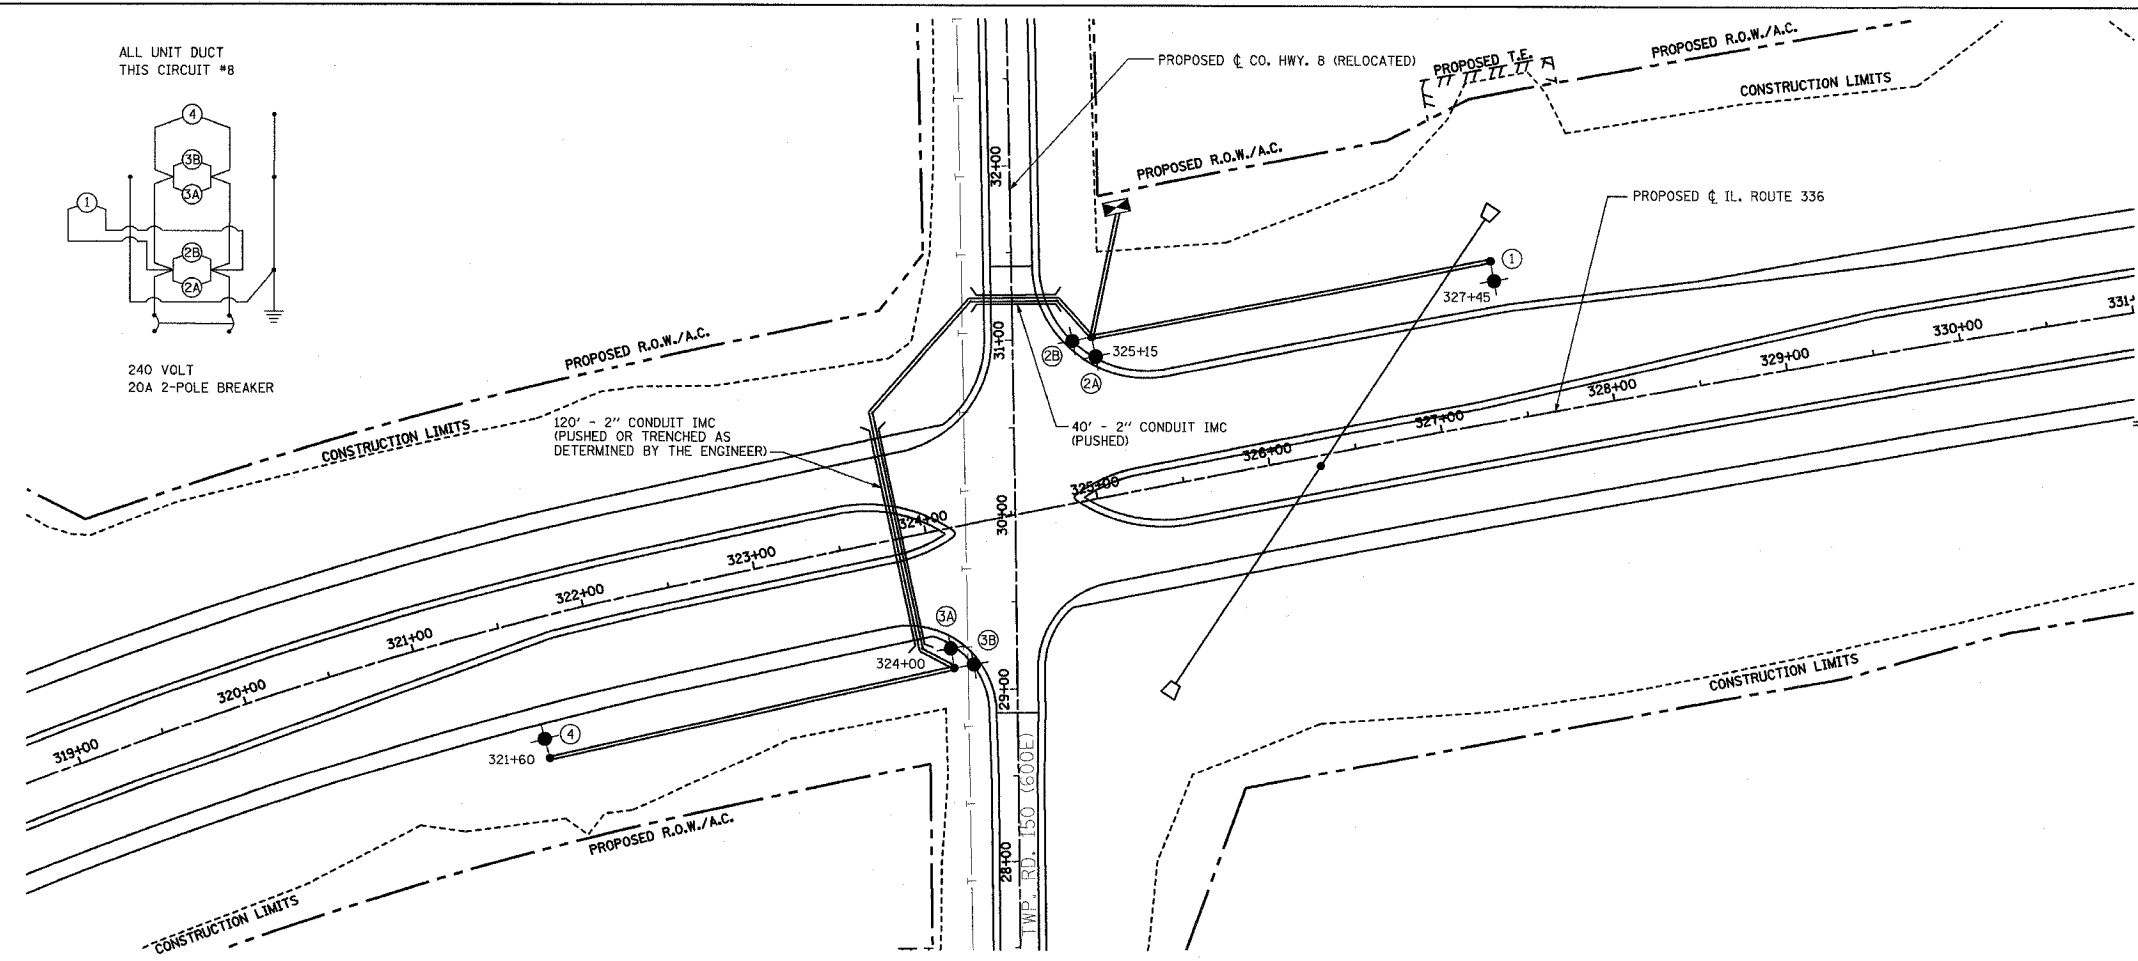

- LEGEND**
- WOOD LIGHTING POLE 55', CLASS 3 W/250 WATT HPS MULTI-MOUNT LUMINAIRE
 - LIGHT POLE, STEEL GALVANIZED, 45' M.H., TENON MOUNT, W/250W HPS MULTI-MOUNT LUMINAIRE ON 6'x8" METAL FOUNDATION ON STEEL BREAKAWAY COUPLINGS W/STAINLESS STEEL SCREEN
 - LIGHT POLE, STEEL GALVANIZED, 45' M.H., TENON MOUNT TWIN, W/250W HPS MULTI-MOUNT LUMINAIRE ON 8'x8" METAL FOUNDATION ON STEEL BREAKAWAY COUPLINGS W/STAINLESS STEEL SCREEN
 - LIGHTING CONTROLLER PHOTOCELL RELAY
 - UNIT DUCT 2 1/C XLP, 1 1/C XLPG (SIZED AS NOTED)
 - CONDUIT (PUSHED OR TRENCHED, SIZED AS NOTED)

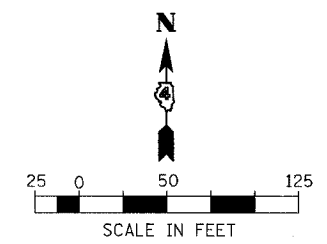

REVISIONS	
NAME	DATE

ILLINOIS DEPARTMENT OF TRANSPORTATION

LIGHTING PLAN
IL. ROUTE 336
STA. 319+00 TO STA. 330+00

DATE 3/30/06

DRAWN BY _____
CHECKED BY _____

3/30/06 10:59:11 AM 4/17/2006 7:14:28 AM