

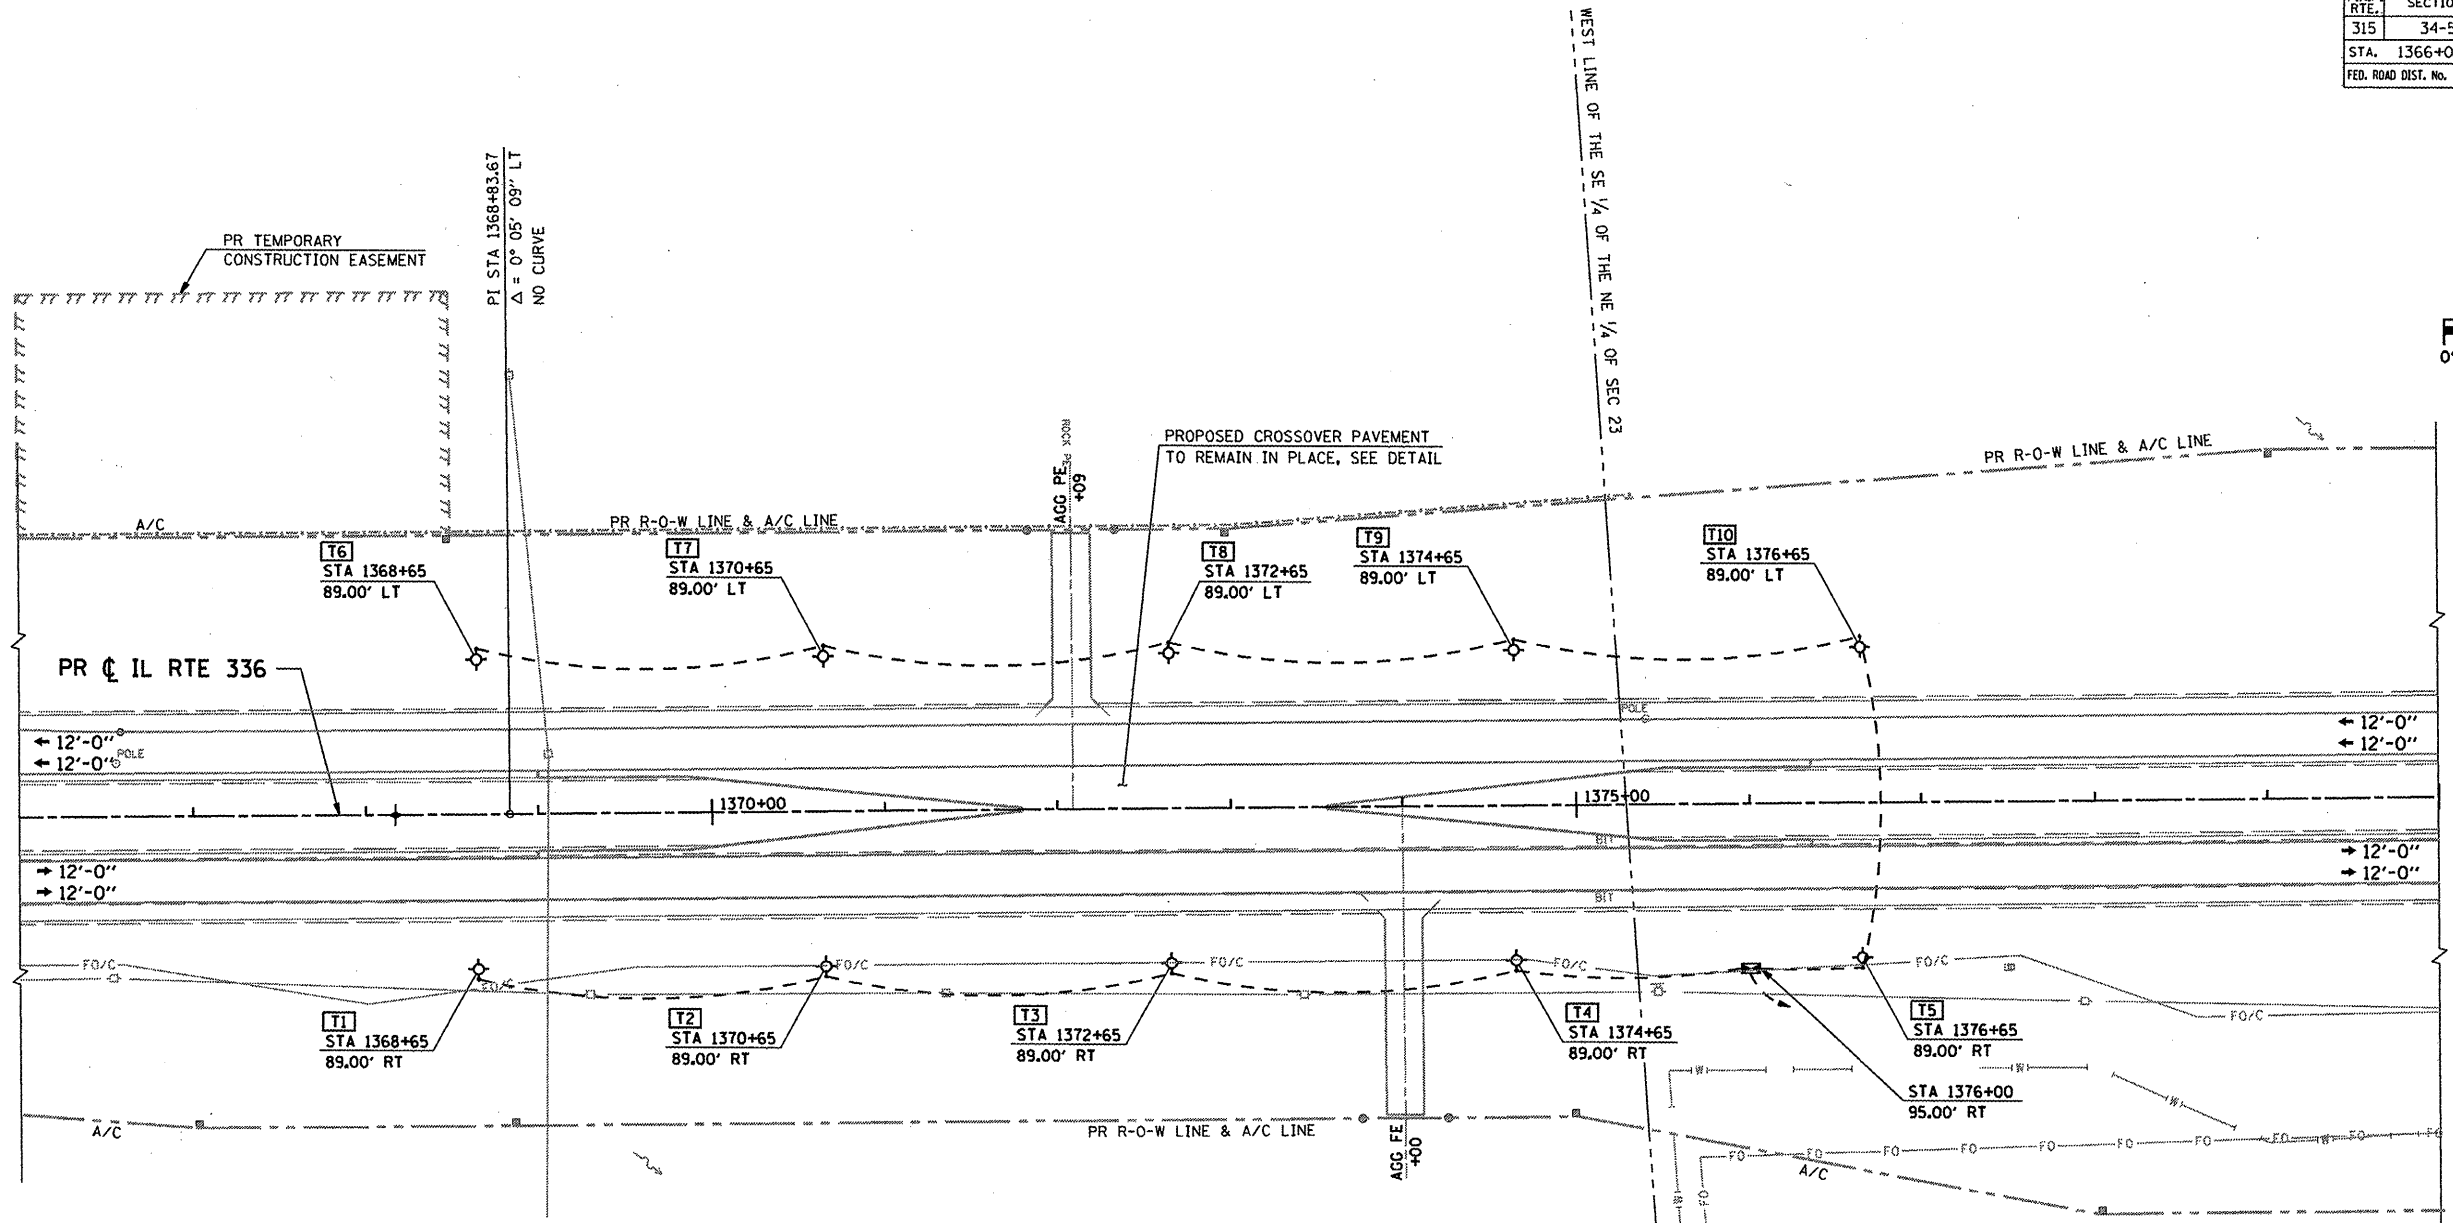


F.A.P. RTE.	SECTION	COUNTY	TOTAL SHEETS	SHEET No.
315	34-5	HANCOCK	612	241
STA. 1366+00		TO STA. 1380+00		
FED. ROAD DIST. No.		ILLINOIS FED. AID PROJECT		

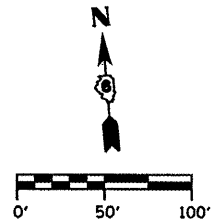

TEMPORARY LIGHTING BILL OF MATERIALS			
CODE NO.	ITEM	UNIT	QUANTITY
80400100	ELECTRIC SERVICE INSTALATION	EACH	1
80700106	GROUND ROD, 5/8" DIA. x 10 FT.	EACH	1
80803100	WOOD LIGHTING POLE, 50 FOOT, CLASS 3	EACH	10
81800620	AERIAL CABLE, 2-1C NO. 4, ALUMINUM, WITH MESSENGER WIRE	FOOT	1800
82103800	LUMINAIRE, SODIUM VAPOR, MULTI-MOUNT, 250 WATT	EACH	10
87500805	LIGHTING CONTROLLER PHOTOCELL RELAY	EACH	1
X220000	ELECTRIC SERVICE INSTALLATION	EACH	1

- LEGEND**
- ⊕ WOOD LIGHTING POLE 50' CLASS 3
W / LUMINAIRE, SODIUM VAPOR, MULTI-MOUNT, 250 WATT
 - ☒ LIGHTING CONTROLLER PHOTOCELL
120 / 240 VOLT SERVICE (POLE MOUNT)
 - AERIAL CABLE, 2-1/C #4 ALUMINUM WITH MESSENGER WIRE.

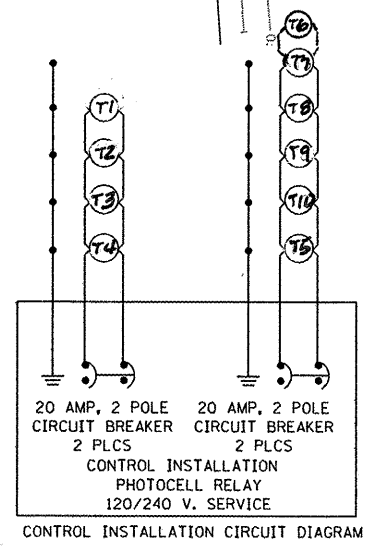

REVISIONS	
NAME	DATE

ILLINOIS DEPARTMENT OF TRANSPORTATION
TEMPORARY LIGHTING PLAN
IL RTE 336
STA. 1366+00 TO STA. 1380+00
 SCALE: _____ DRAWN BY: RG
 DATE: MARCH 10, 2006 CHECKED BY: JAC

DGN-SPEC
 DATE-TIME
 *REF01

D6 PROJECT: FILE:

Rev.