
 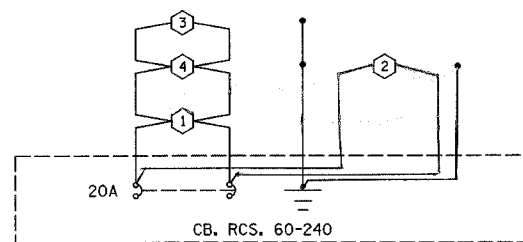


F.A.P. RTE.	SECTION	COUNTY	TOTAL SHEETS	SHEET NO.
774	107 WRS-2, L	EFFINGHAM	127	55
FED. ROAD DIST. NO.	ILLINOIS	FED. AID PROJECT		


CONTRACT NO. 74130



CONTROL ONE LINE

LEGEND:

- CONDUIT w/GROUND
- CONTROLLER
- LIGHT UNIT-1
- SERVICE POLE

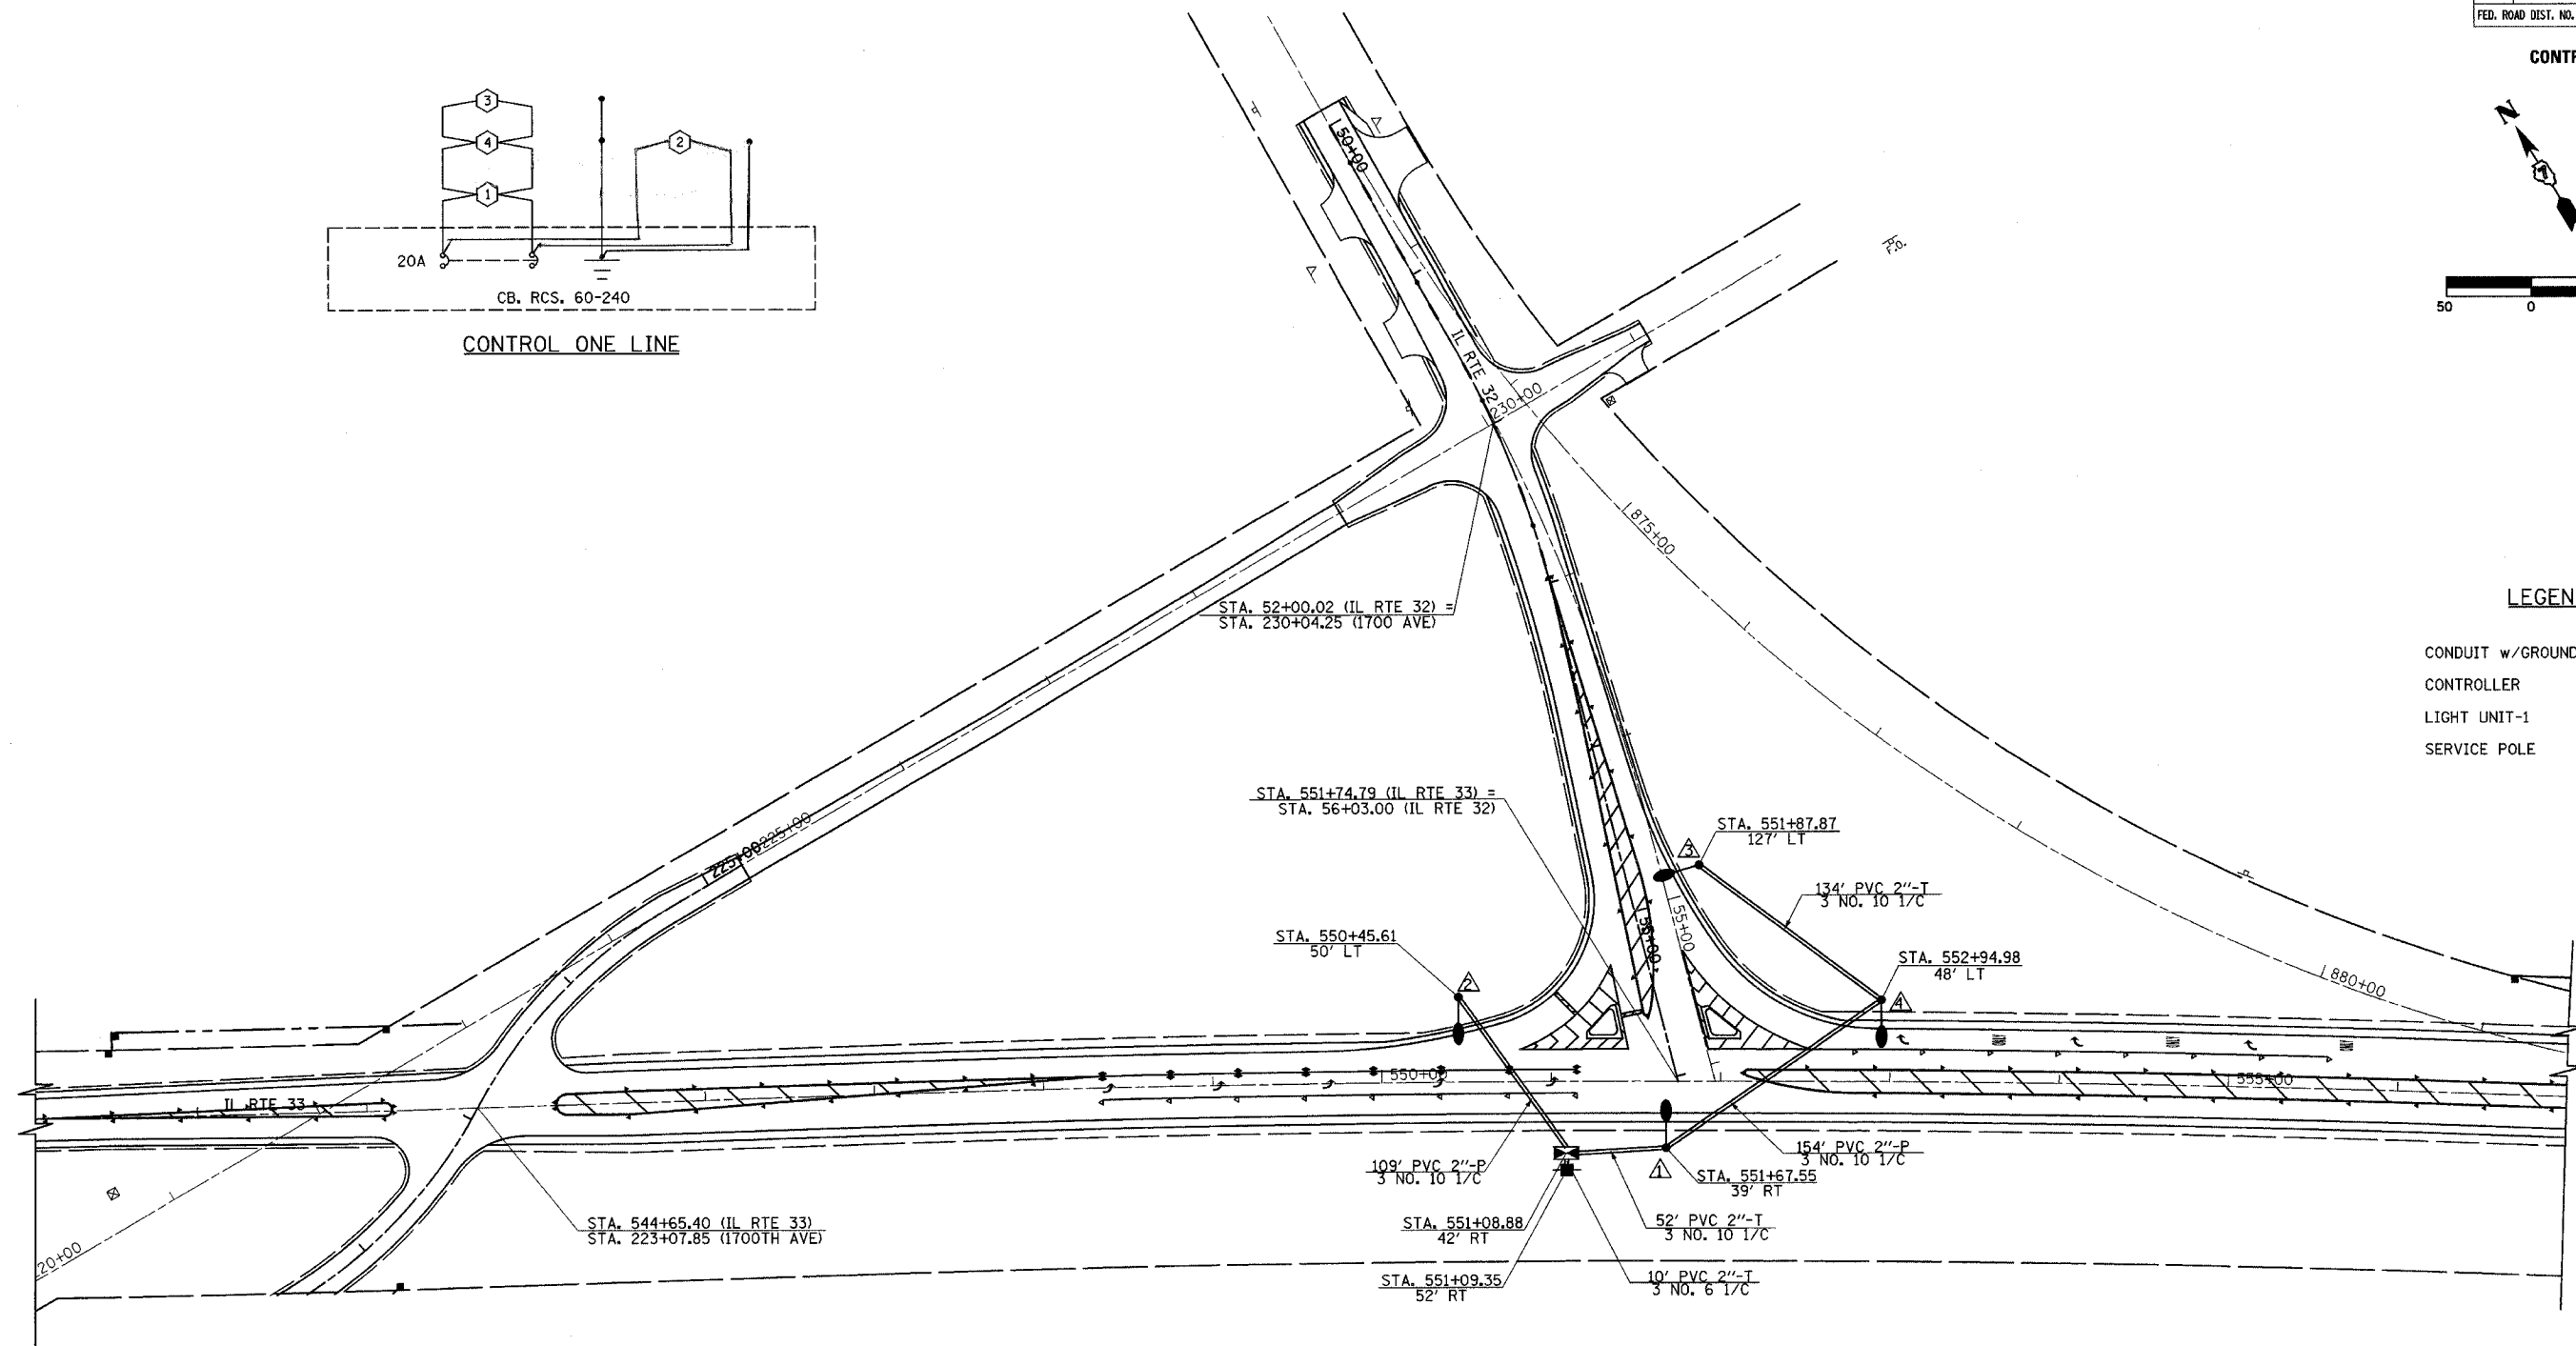

LIGHT/CABLE LAYOUT

REVISIONS	
NAME	DATE

ILLINOIS DEPARTMENT OF TRANSPORTATION

IL RTE 32/33 WYE
LIGHTING PLANS
SHEET 1 OF 6

DATE 8/02

DRAWN BY ASB
CHECKED BY BWD