

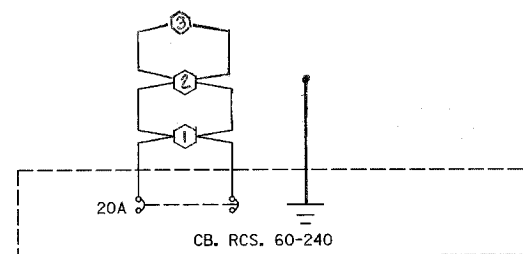


F.A.P. RTE.	SECTION	COUNTY	TOTAL SHEETS	SHEET NO.
774	107 WRS-2, L	EFFINGHAM	127	57
FED. ROAD DIST. NO.	ILLINOIS	FED. AID PROJECT		

CONTRACT NO. 74130

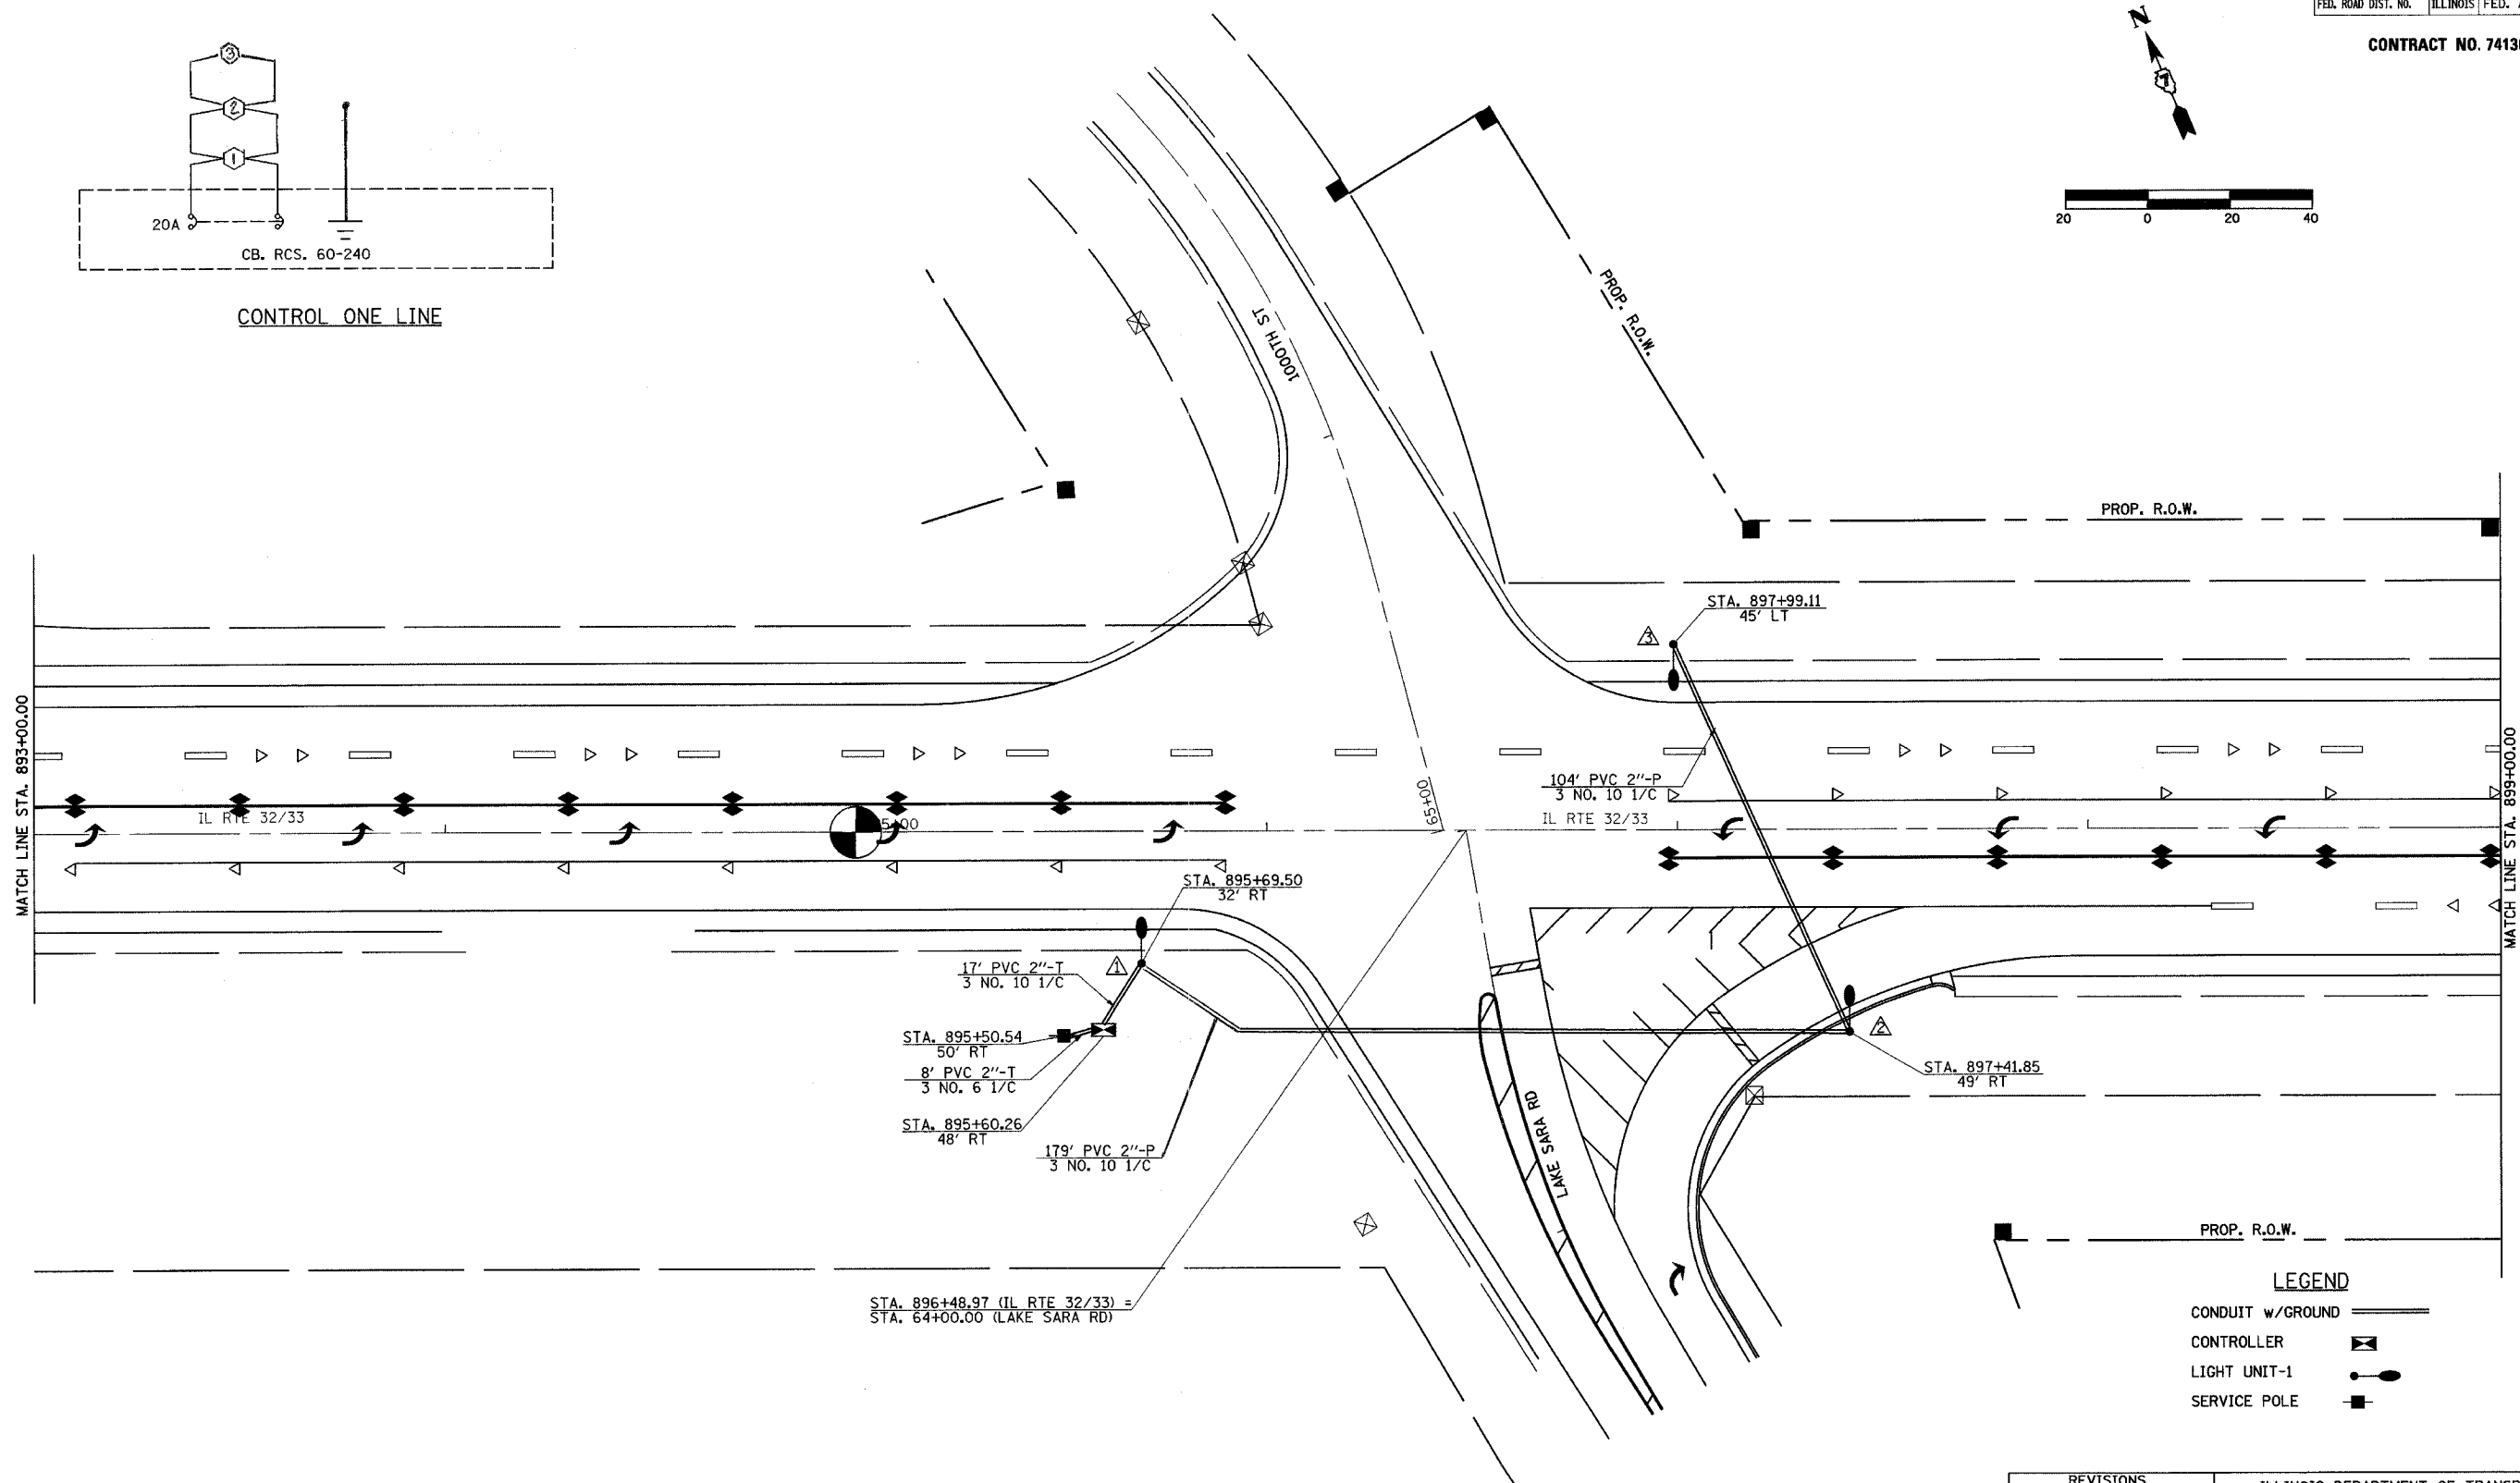

CONTROL ONE LINE

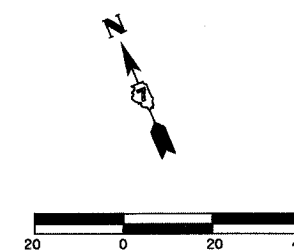

LIGHT/CABLE LAYOUT

LEGEND

CONDUIT w/GROUND	
CONTROLLER	
LIGHT UNIT-1	
SERVICE POLE	

REVISIONS	
NAME	DATE

ILLINOIS DEPARTMENT OF TRANSPORTATION

LAKE SARA ROAD
LIGHTING PLANS
SHEET 3 OF 6

DATE 8/02

DRAWN BY ASB
CHECKED BY BWD