


THE LOCATION, SIZE AND TYPE OF MATERIAL OF EXISTING UNDERGROUND UTILITIES INDICATED ON THE PLANS IS NOT REPRESENTED AS BEING ACCURATE, SUFFICIENT OR COMPLETE. IT SHALL BE THE CONTRACTOR'S RESPONSIBILITY TO DETERMINE THE ACTUAL LOCATION OF ALL SUCH FACILITIES, INCLUDING SERVICE CONNECTIONS TO UNDERGROUND UTILITIES. PRIOR TO CONSTRUCTION, THE CONTRACTOR SHALL NOTIFY THE UTILITY COMPANIES OF HIS OPERATIONAL PLANS AND SHALL OBTAIN FROM THE RESPECTIVE UTILITY COMPANIES DETAILED INFORMATION AND ASSISTANCE RELATIVE TO THE LOCATION OF THEIR FACILITIES AND THE WORKING SCHEDULE OF THE COMPANIES FOR REMOVAL OR ADJUSTMENT WHERE REQUIRED. IN THE EVENT AN UNEXPECTED UTILITY INTERFERENCE IS ENCOUNTERED DURING CONSTRUCTION, THE CONTRACTOR SHALL IMMEDIATELY NOTIFY THE UTILITY COMPANY OF JURISDICTION. THE ENGINEER SHALL ALSO BE IMMEDIATELY NOTIFIED. ANY SUCH MAINS AND SERVICES SHALL BE RESTORED TO SERVICE AT ONCE AND PAID FOR BY THE CONTRACTOR AT NO ADDITIONAL COST TO THE CONTRACT.

CALL J.U.L.I.E. FOR UTILITY INFORMATION AT 1-800-892-0123. CONTACT AIRPORT PERSONNEL FOR ASSISTANCE IN LOCATING AIRPORT CABLES.


QUANTITIES				
ITEM No.	DESCRIPTION	UNIT	QUANTITY	AS BUILT QUANTITY
AR108158	1/C #8 5 KV UG CABLE IN UD	L.F.	5,800	
AR110014	4" DIRECTIONAL BORE	L.F.	156	
AR110504	4-WAY CONCRETE ENCASED DUCT	L.F.	81	
AR110550	SPLIT DUCT	L.F.	12	
AR110558	EXTEND 8-WAY DUCT	L.F.	16	
AR110710	ELECTRICAL MANHOLE	EACH	1	
AR125410	MITL-STAKE MOUNTED	EACH	33	
AR125415	MITL-BASE MOUNTED	EACH	3	
AR125442	TAXI GUIDANCE SIGN, 2 CHARACTER	EACH	1	
AR125443	TAXI GUIDANCE SIGN, 3 CHARACTER	EACH	2	
AR125452	TAXI GUIDANCE SIGN, 12 CHARACTER	EACH	1	
AR125565	SPLICE CAN	EACH	4	
AR125961	RELOCATE STAKE MOUNTED LIGHT	EACH	4	
AR125962	RELOCATE BASE MOUNTED LIGHT	EACH	2	
AR125964	RELOCATE TAXI GUIDANCE SIGN	EACH	1	

LEGEND

- EXISTING PAVEMENT
- EXISTING LIGHTING CABLES
- ABANDONED ELECTRICAL CABLES
- EXISTING ELECTRICAL DUCT
- EXISTING STAKE MOUNTED TAXIWAY LIGHT
- EXISTING BASE MOUNTED TAXIWAY LIGHT
- EXISTING TAXIWAY GUIDANCE SIGN
- EXISTING BASE MOUNTED RUNWAY LIGHT
- EXISTING ELECTRICAL HANDHOLE
- PROPOSED PAVEMENT
- PROPOSED LIGHTING CABLES
- PROPOSED ELECTRICAL DUCT/DUCT EXTENSION
- PROPOSED STAKE MOUNTED TAXIWAY LIGHT
- PROPOSED BASE MOUNTED TAXIWAY LIGHT
- PROPOSED TAXIWAY GUIDANCE SIGN
- PROPOSED SPLICE CAN
- PROPOSED ELECTRICAL MANHOLE
- PROPOSED BASE MOUNTED RUNWAY LIGHT (RELOCATED)

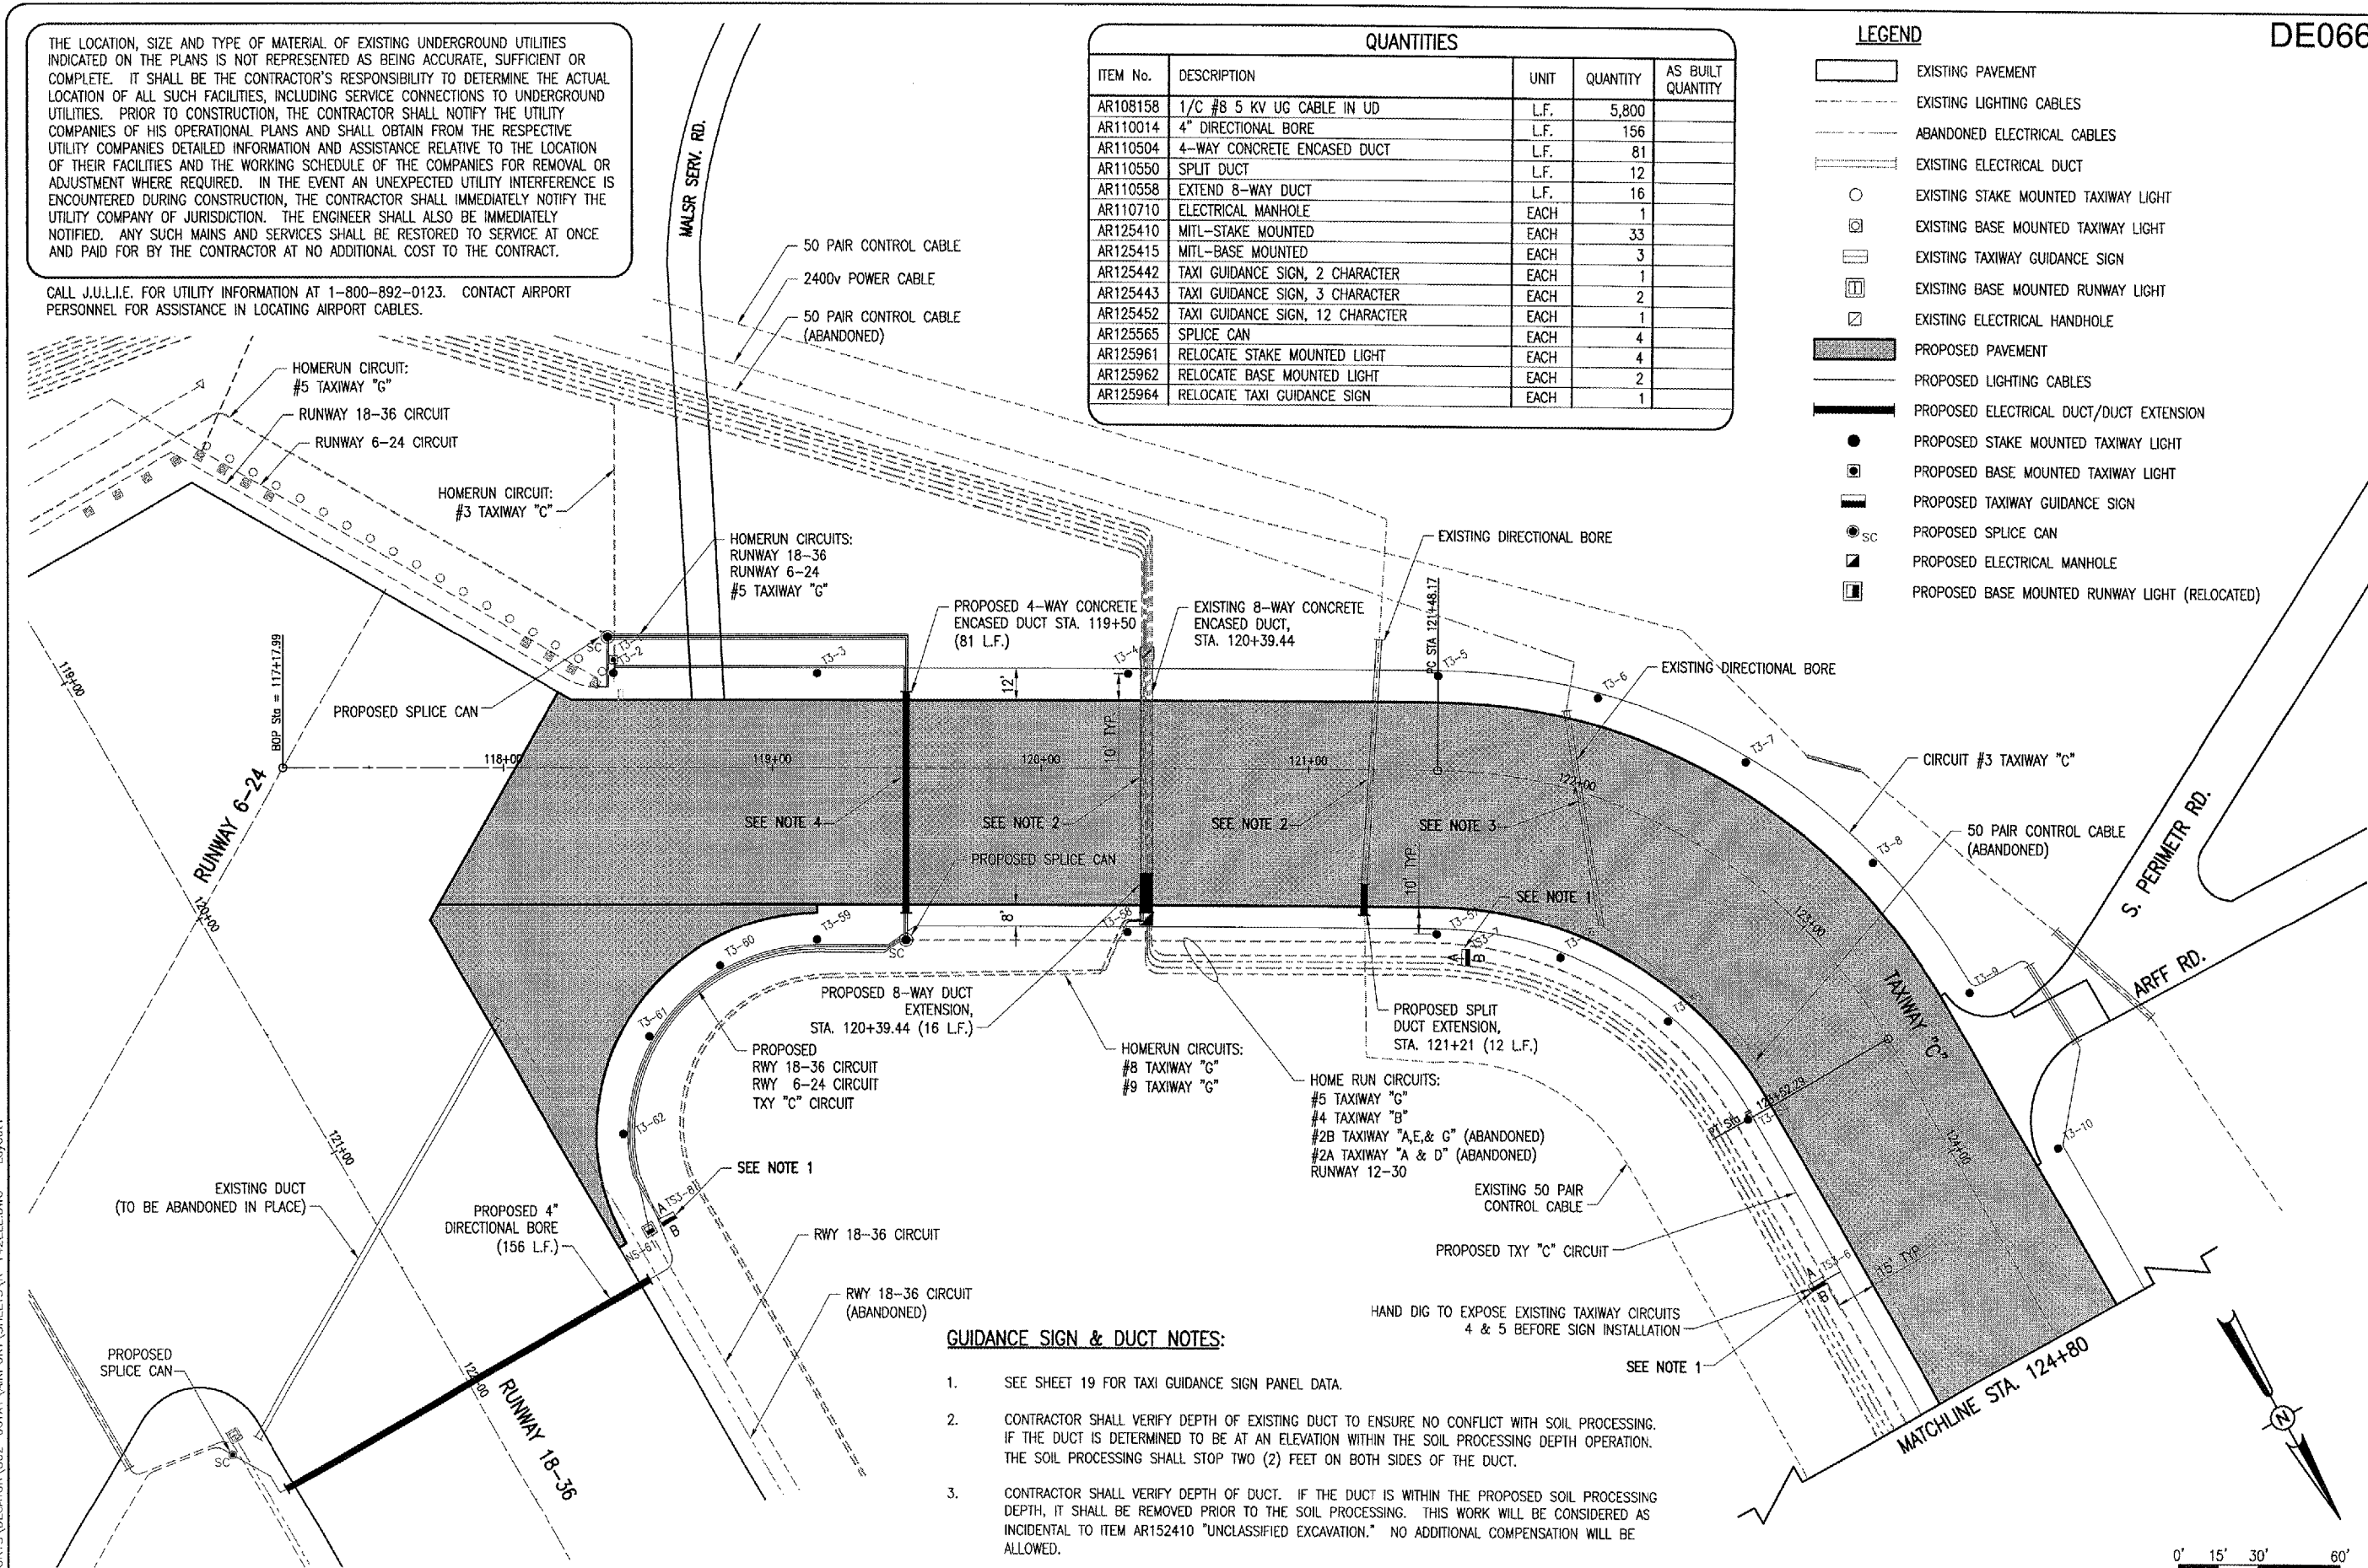

- GUIDANCE SIGN & DUCT NOTES:**
- SEE SHEET 19 FOR TAXI GUIDANCE SIGN PANEL DATA.
 - CONTRACTOR SHALL VERIFY DEPTH OF EXISTING DUCT TO ENSURE NO CONFLICT WITH SOIL PROCESSING. IF THE DUCT IS DETERMINED TO BE AT AN ELEVATION WITHIN THE SOIL PROCESSING DEPTH OPERATION. THE SOIL PROCESSING SHALL STOP TWO (2) FEET ON BOTH SIDES OF THE DUCT.
 - CONTRACTOR SHALL VERIFY DEPTH OF DUCT. IF THE DUCT IS WITHIN THE PROPOSED SOIL PROCESSING DEPTH, IT SHALL BE REMOVED PRIOR TO THE SOIL PROCESSING. THIS WORK WILL BE CONSIDERED AS INCIDENTAL TO ITEM AR152410 "UNCLASSIFIED EXCAVATION." NO ADDITIONAL COMPENSATION WILL BE ALLOWED.
 - DUCT SHALL BE CONSTRUCTED AT A DEPTH BELOW THE PROPOSED SOIL PROCESSING.

 

DE066

DATE	REVISION	BY

HANSON
 Decatur, Illinois
 A.I.P. PROJ.: 3-17-00

HEL Project No.	802-06TXD-0800
Drawn	R-142ELE.DWG
Scale	1"=30'
Date	02/24/06
LAYOUT	CCC 02/24/06
DRAWN	CCC 02/24/06
REVIEWED	WJM 03/31/06

HANSON
 Hanson Professional Services Inc.
 1525 South Sixth Street
 Springfield, Illinois 62703-2886
 Offices Nationwide

TAXIWAY "C"
 RECONSTRUCTION
 PROPOSED ELECTRICAL PLAN
 STA. 117+99 TO STA. 124+80

APR 27, 2006 11:06 PM RAW
 I:\AIRPORTS\DECATUR\802-06TXD\AIRPORT SHEETS\R-142ELE.DWG - Layout1