


DK050

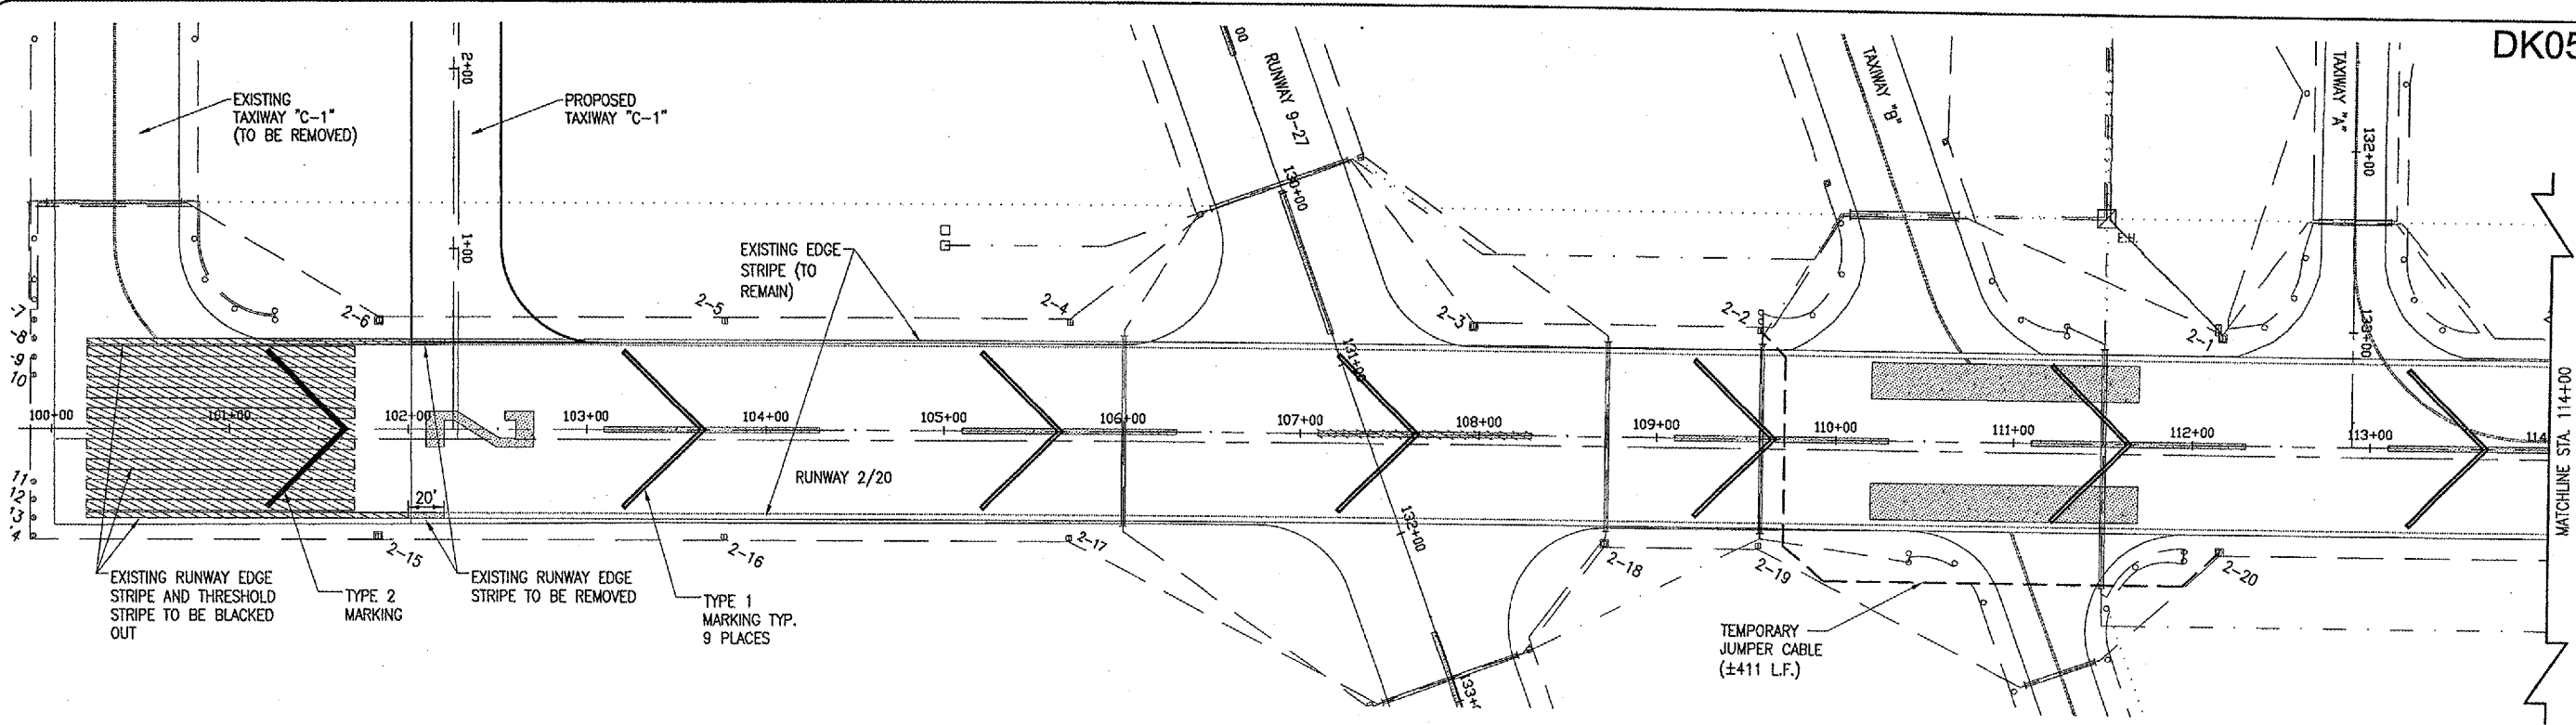

MARKING TO BE BLACKED OUT NOTE:

THE EXISTING MARKING DESIGNATED TO BE BLACKED OUT IS SHOWN ON THIS SHEET. THE RUNWAY 2-20 CENTERLINE LOCATED AT STA. 107+10 TO STA. 108+30 WILL BE BLACKED OUT WHILE RUNWAY 9-27 IS MONITORED FOR TRAFFIC. THIS WILL PREVENT CLOSING THE AIRPORT AND/OR RUNWAY 9-27 DURING THE RUNWAY 2-20 DISPLACEMENT.

 
 

THE CHEVRON AT THE INTERSECTION OF THE TWO RUNWAYS WILL NOT BE PLACED UNTIL RUNWAY 9-27 IS DISPLACED.

THE CONTRACTOR WILL COVER THE DESIGNATED MARKING WITH BLACK PAINT AS A BLOCK SO THE SHAPE OF THE EXISTING MARKING CANNOT BE DETERMINED.

THE BLACKING OUT OF THE EXISTING MARKING SHALL BE PAID FOR UNDER ITEM:
AR620912 "TEMPORARY MARK AND LIGHT" ____ L.S.

LEGEND

- EXISTING PAVEMENT
- PROPOSED PAVEMENT
- EXISTING MARKING (TO BE REMOVED)
- EXISTING MARKING (TO BE BLACKED OUT)
- PROPOSED MARKING (TYPE 1)
- PROPOSED MARKING (TYPE 2)
- EXISTING ELECTRICAL CABLES
- EXISTING ELECTRICAL DUCT
- EXISTING REIL CABLES
- EXISTING PAPI CABLES
- PROPOSED ELECTRICAL CABLES
- EXISTING STAKE MOUNTED RUNWAY LIGHT
- EXISTING BASE MOUNTED RUNWAY LIGHT
- EXISTING STAKE MOUNTED TAXIWAY LIGHT
- EXISTING BASE MOUNTED TAXIWAY LIGHT
- EXISTING THRESHOLD LIGHT (TO BE RELOCATED)
- EXISTING P.A.P.I. (TO BE RELOCATED)
- E.H. EXISTING ELECTRICAL HANDHOLE
- PROPOSED TEMPORARY RELOCATED THRESHOLD LIGHT

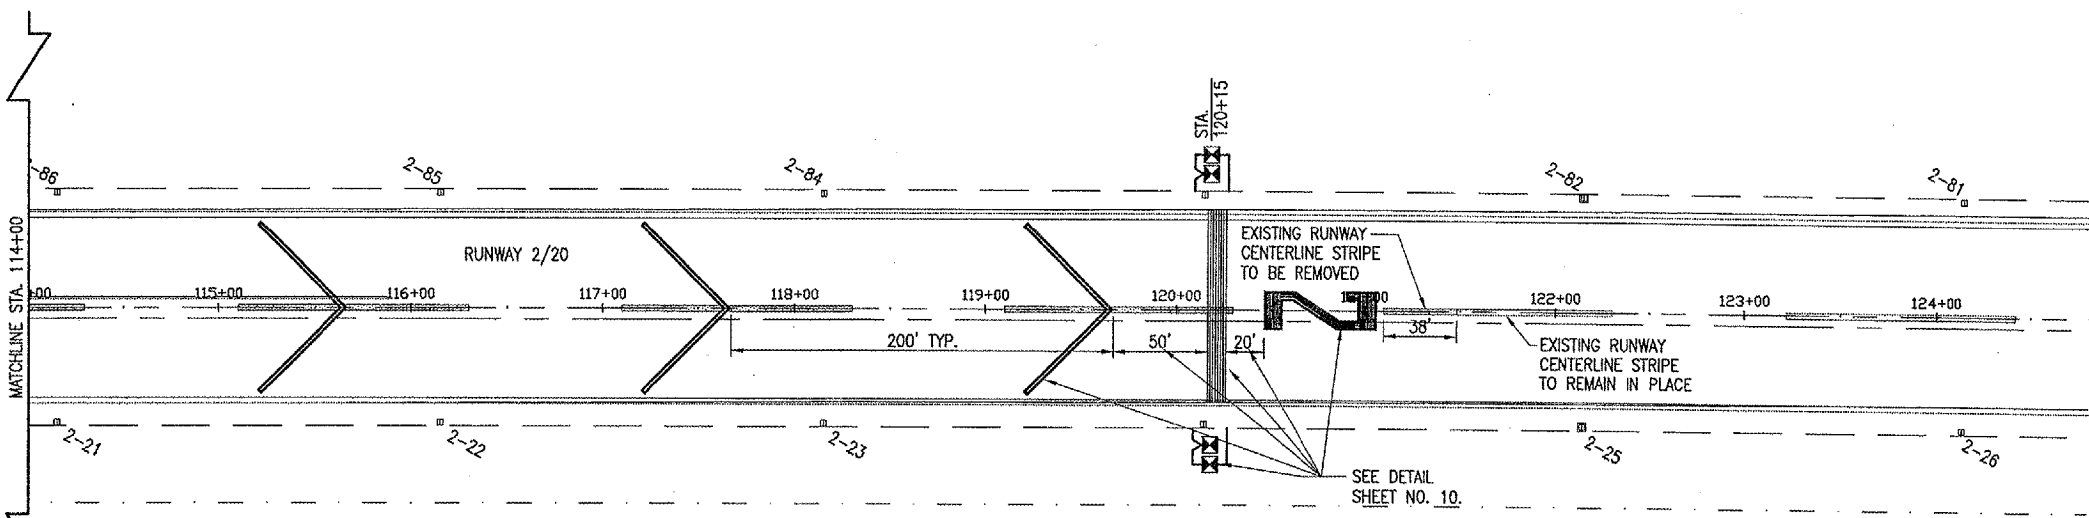

DATE	REVISION	BY

DITMA
DEKALB TAYLOR MUNICIPAL AIRPORT
IL. PROJ.: DK8-3448 AIP PROJ.: 3-17-0139-B43

HPS Project No. 803051XAD_0800		R-152TEMP_MRK.DWG	
Scale	1" = 50'	Date	01/10/05
LAYOUT	JMB	01/10/05	
DRAWN	JMB	01/10/05	
REVIEWED	CAH	03/06/06	

HANSON
Hanson Professional Services Inc.
1925 South Sixth Street
Springfield, Illinois 62703-2886
Offices Nationwide

DEKALB AIRPORT IMPROVEMENTS
PROPOSED TEMPORARY MARKING AND LIGHTING PLAN
STA. 100+00 TO STA. 125+00

MAY 15, 2006 3:40 PM CAH
I:\AIRPORTS\DEKALB\803-051XAD\AIRPORT\GENERAL\152TEMP_MRK.DWG