


F.A.P. RTE.	SECTION	COUNTY	TOTAL SHEETS	SHEET NO.
337	20R-5	LAKE	562	402
STA. 101+800		TO STA. 102+050		
FED. ROAD DIST. NO.		ILLINOIS	FED. AID PROJECT	
D-91-552-99		CONTRACT #60881		


FINAL SURVEY	BY	DATE
SURVEY PLOTTED		
NOTE BOOK		
TEMP. DATE		
AREAS CHECKED		
NO.		

ORIGINAL SURVEY	BY	DATE
SURVEY PLOTTED		
NOTE BOOK		
TEMP. DATE		
AREAS CHECKED		
NO.		

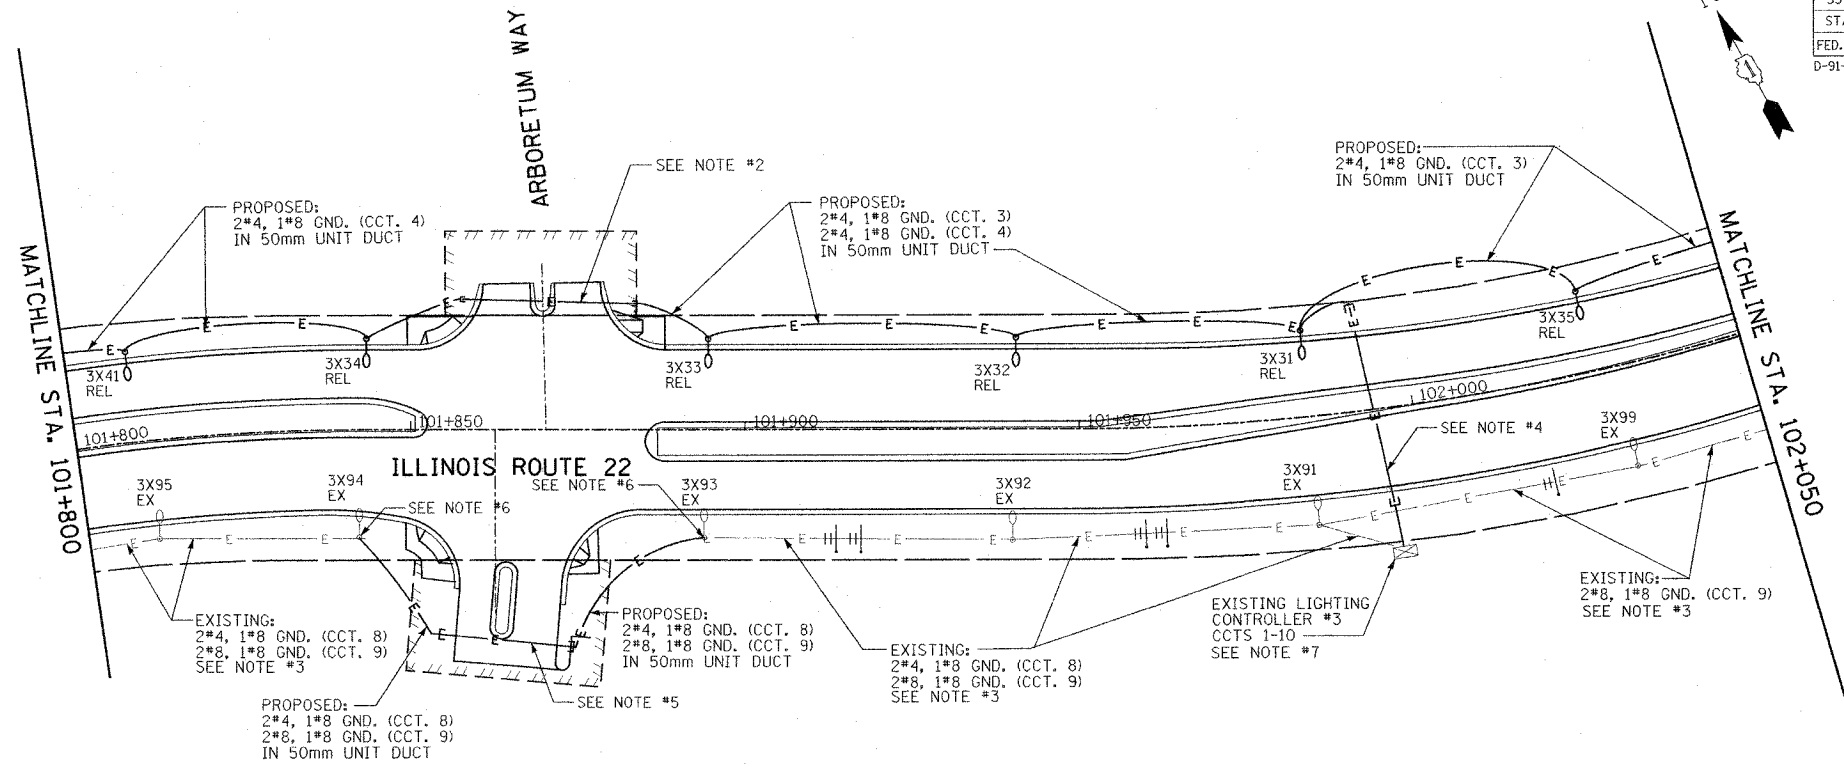

NOTES:

1. EXACT LOCATIONS OF RELOCATED AND PROPOSED POLES AND CONDUIT/CABLE ROUTINGS SHALL BE COORDINATED WITH UNDERGROUND UTILITIES, OWNER AND ENGINEER. LOCATIONS AND ROUTING SHOWN ON PLANS ARE APPROXIMATE.
2. PROPOSED 100mm PUSHED GRS CONDUIT (28m) WITH: 2*4, 1*8 GND. (CCT 3) AND 2*4, 1*8 GND. (CCT 4) IN 50mm UNIT DUCT
3. LOCATE AND PROTECT EXISTING CONDUIT AND WIRING TO REMAIN AS REQUIRED.
4. PROPOSED 100mm PUSHED GRS CONDUIT (32m) WITH: 2*4, 1*8 GND. (CCT 3) AND 2*4, 1*8 GND. (CCT 4) IN 50mm UNIT DUCT
5. PROPOSED 100mm PUSHED GRS CONDUIT (21m) WITH: 2*4, 1*8 GND. (CCT 8) AND 2*8, 1*8 GND. (CCT 9) IN 50mm UNIT DUCT
6. CONTRACTOR SHALL REMOVE EXISTING WIRING IN POLES 3X93 AND 3X94 AND SPLICE PROPOSED WIRING IN EXISTING LIGHT POLE HANDHOLE AS REQUIRED.
7. PROVIDE ONE (1) 2-POLE, 40A, 240V, 10 KAIC BRANCH BREAKER IN EXISTING CONTROLLER FOR PROPOSED CIRCUIT (CCT. 10).

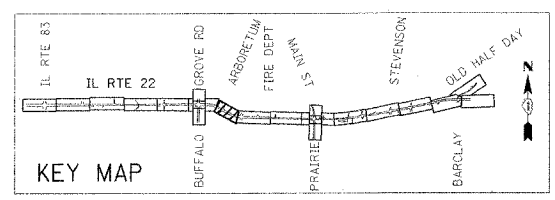

REVISIONS	
NAME	DATE

ILLINOIS DEPARTMENT OF TRANSPORTATION
 IL RTE 22 (FAP 337)
 IL RTE 83 TO US 45 / IL 21 (MILWAUKEE AVE)
PROPOSED LIGHTING PLAN (3 OF 10)
 STA. 101+800 TO STA. 102+050
 SCALE: 1:500
 DATE: 03-22-2004
 DRAWN BY: CMW
 CHECKED BY: MAR