



F.A.I. RTE.	SECTION	COUNTY	TOTAL SHEETS	SHEET NO.
94	*	COOK	860	197A
STA. 2200+00.00 TO STA. 2362+00.00				
FED. ROAD DIST. NO. ILLINOIS FED. AID PROJECT				
(1516.1, 1717 & 1818) R-8 62694				

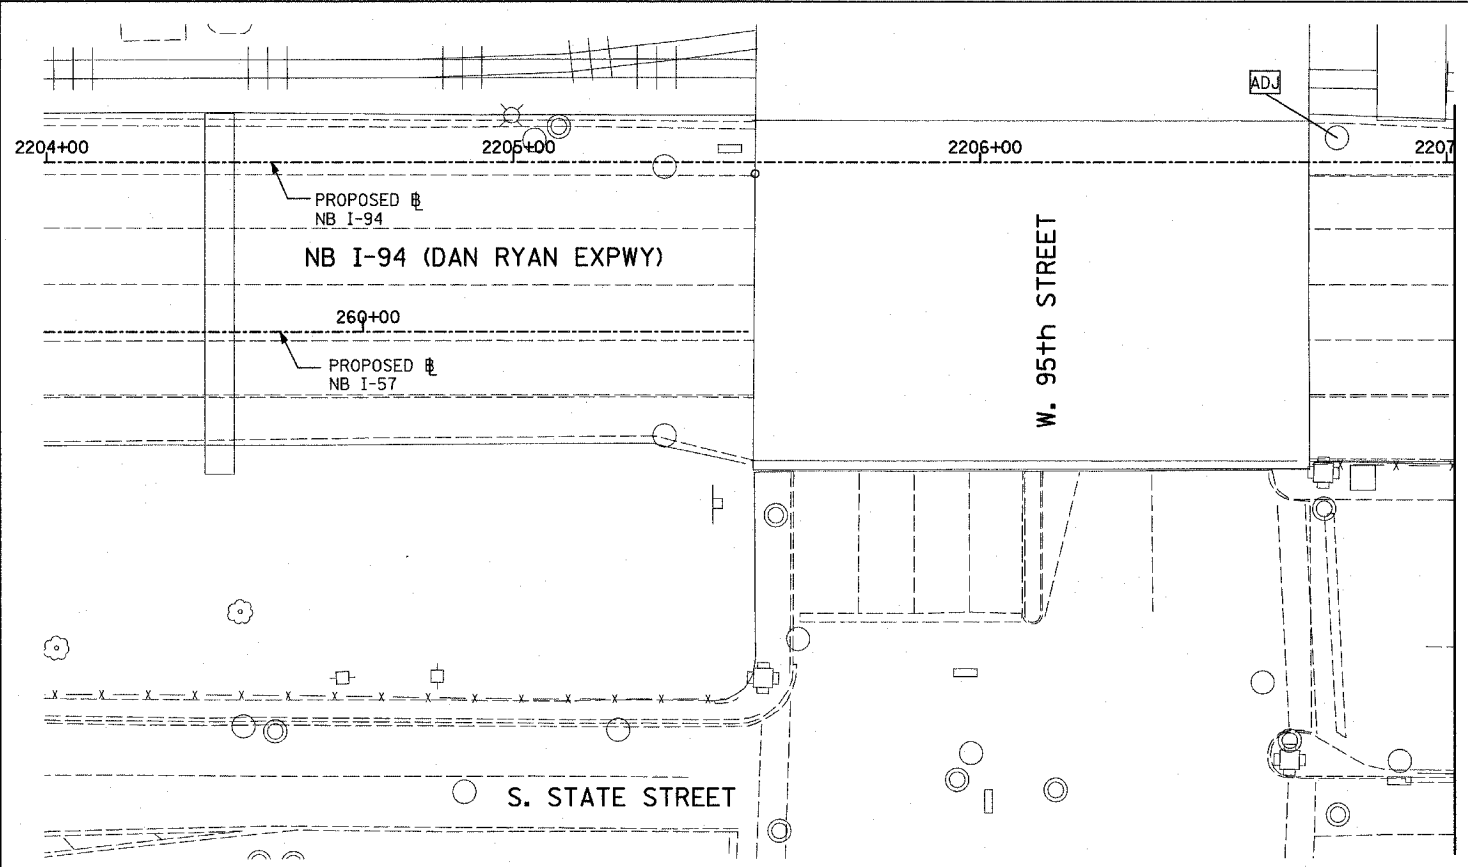

MATCHLINE NB STA. 2207+00.00



EXISTING CONDITIONS
PROPOSED IMPROVEMENTS

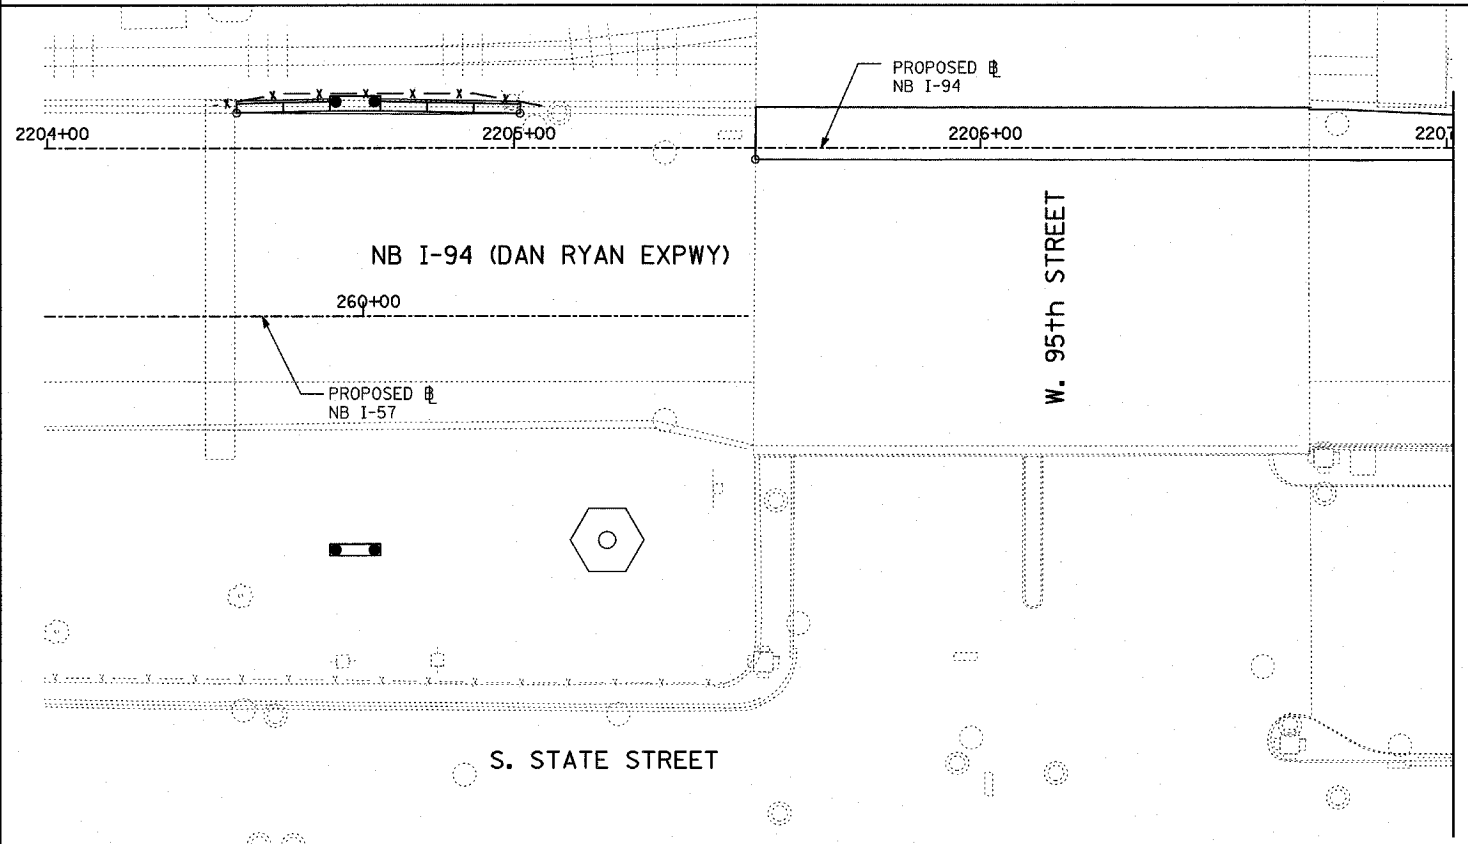

MATCHLINE NB STA. 2207+00.00

LEGEND:

	EXISTING COMBINED SEWER		HIGH MAST LIGHT TOWER FOUNDATION (BY OTHERS - SEE CONTRACT 62583)
	PROPOSED STORM SEWER NUMBER (X=SHEET NO., Y=PIPE NO.)		HIGH MAST LIGHT TOWER FOUNDATION, WALL MOUNTED
	PROPOSED STRUCTURE NUMBER (X=SHEET NO., Y=STRUCTURE NO.)		HIGH MAST LIGHT TOWER FOUNDATION (BY OTHERS - SEE CONTRACT 62583)
	PIPE STUBOUT TO BE PLUGGED		F.V. FIELD VERIFY
	UTILITY REMOVAL		
	UTILITY REMOVAL PLUG		

 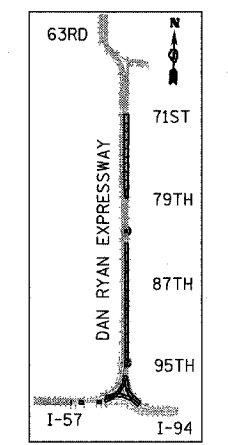

REVISIONS		ILLINOIS DEPARTMENT OF TRANSPORTATION F.A.I. 94 (DAN RYAN EXPRESSWAY) DRAINAGE AND UTILITY PLANS NB I-94 (DAN RYAN EXPWY) NB STA. 2204+00.00 TO 2207+00.00
NAME	DATE	
REVISED	04/15/05	SCALE: 1"=20' DATE: MARCH 18, 2005
		DRAWN BY: MB CHECKED BY: DA

TYLIN INTERNATIONAL

P:\02373\Road\Civil\Auto\As976933.dwg 5/28/05 4/13/2005