


F.A.I. RTE.	SECTION	COUNTY	TOTAL SHEETS	SHEET NO.
94	*	COOK	907	390
STA.		TO STA.		
FED. ROAD DIST. NO.	ILLINOIS	FED. AID PROJECT		
*(1516, 1, 1717 & 1818) R-9		62695		

 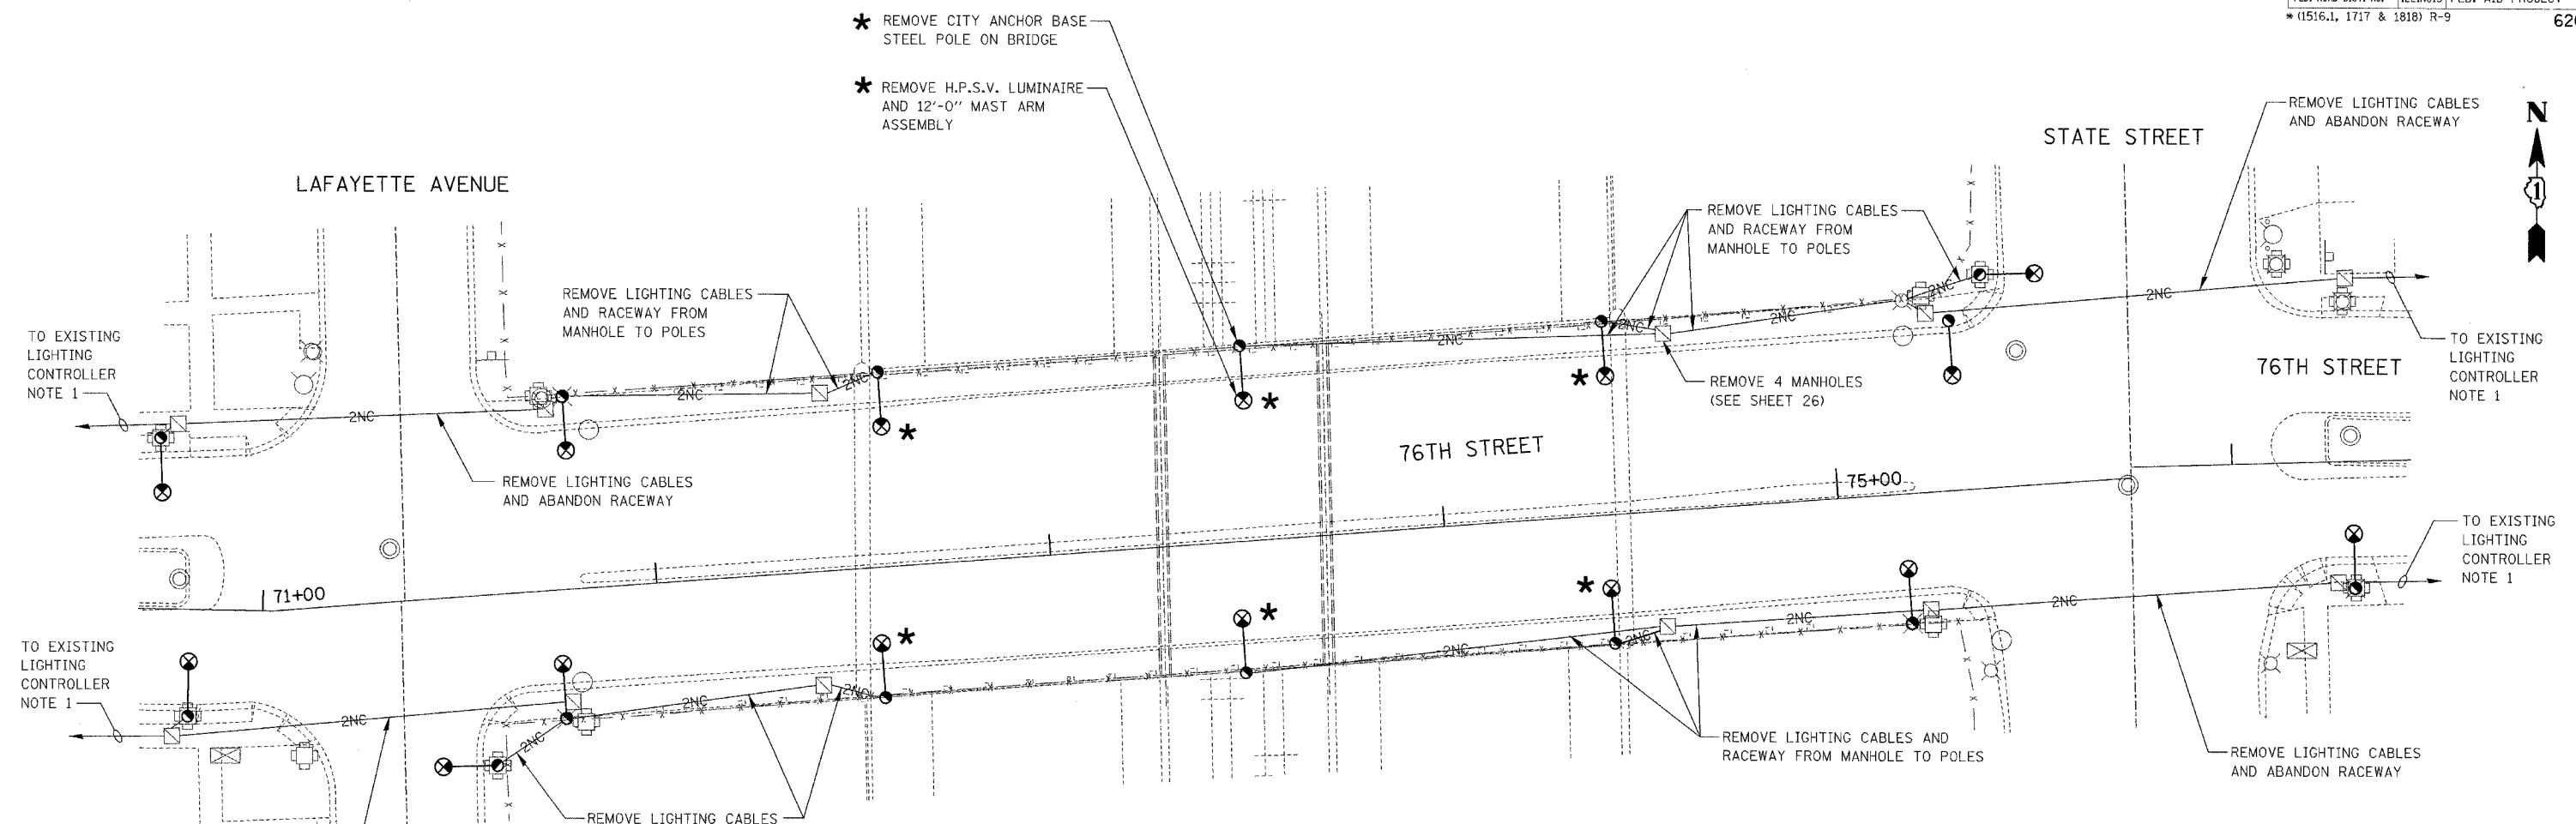


**REMOVAL OF EXISTING OVERPASS STREET LIGHTING
(CITY OF CHICAGO)**

REMOVAL NOTE

1. THE ELECTRICAL SERVICE CABLES FROM THE CONTROLLER TO THE REMOVED STREET LIGHTS WILL BE RE-USED FOR ELECTRICAL SUPPLY TO THE PROPOSED STREET LIGHTING. PROVISIONS SHALL BE MADE AT THE MANHOLES OR LIGHT POLES FOR SPLICING THE EXISTING CABLES TO THE PROPOSED CABLES TO THE NEW STREET LIGHTING.

LEGEND		
PROPOSED	EXISTING	
⊗	⊗	LUMINAIRE H.P.S.V. AND LAMP, 400W, 240V, WITH INTEGRAL BALLAST.
⊙	●	POLE, CITY STEEL, ANCHOR BASE, 32'-6" 7 GA., AND FND WITH 1 1/2" B.C. AND 1/4" ANCHOR RODS.
	⊗	LUMINAIRE, TO REMAIN
	○	MANHOLE
-2NC-		CABLE, STREET LIGHT, 2-1/2" NO. 6 IN CONDUIT
-----		PVC - SCHEDULE 40



REVISIONS	
NAME	DATE

ILLINOIS DEPARTMENT OF TRANSPORTATION
F.A.I. 94 (DAN RYAN EXPRESSWAY)
**76TH STREET
OVERPASS LIGHTING PLAN
REMOVAL**

SCALE: AS SHOWN DRAWN BY: RC
DATE: MARCH 25, 2005 CHECKED BY: ASN

FILE: L:\ES94\02\Corp\UShears\Bridges\76th\Lighting\ES940221.dwg

