


F.A.I. RTE.	SECTION	COUNTY	TOTAL SHEETS	SHEET NO.
74	(72-71R-3)	PEORIA	1360	1196
STA.		TO STA.		
FED. ROAD DIST. NO.		ILLINOIS	FED. AID PROJECT	

CONTRACT NO. 68200

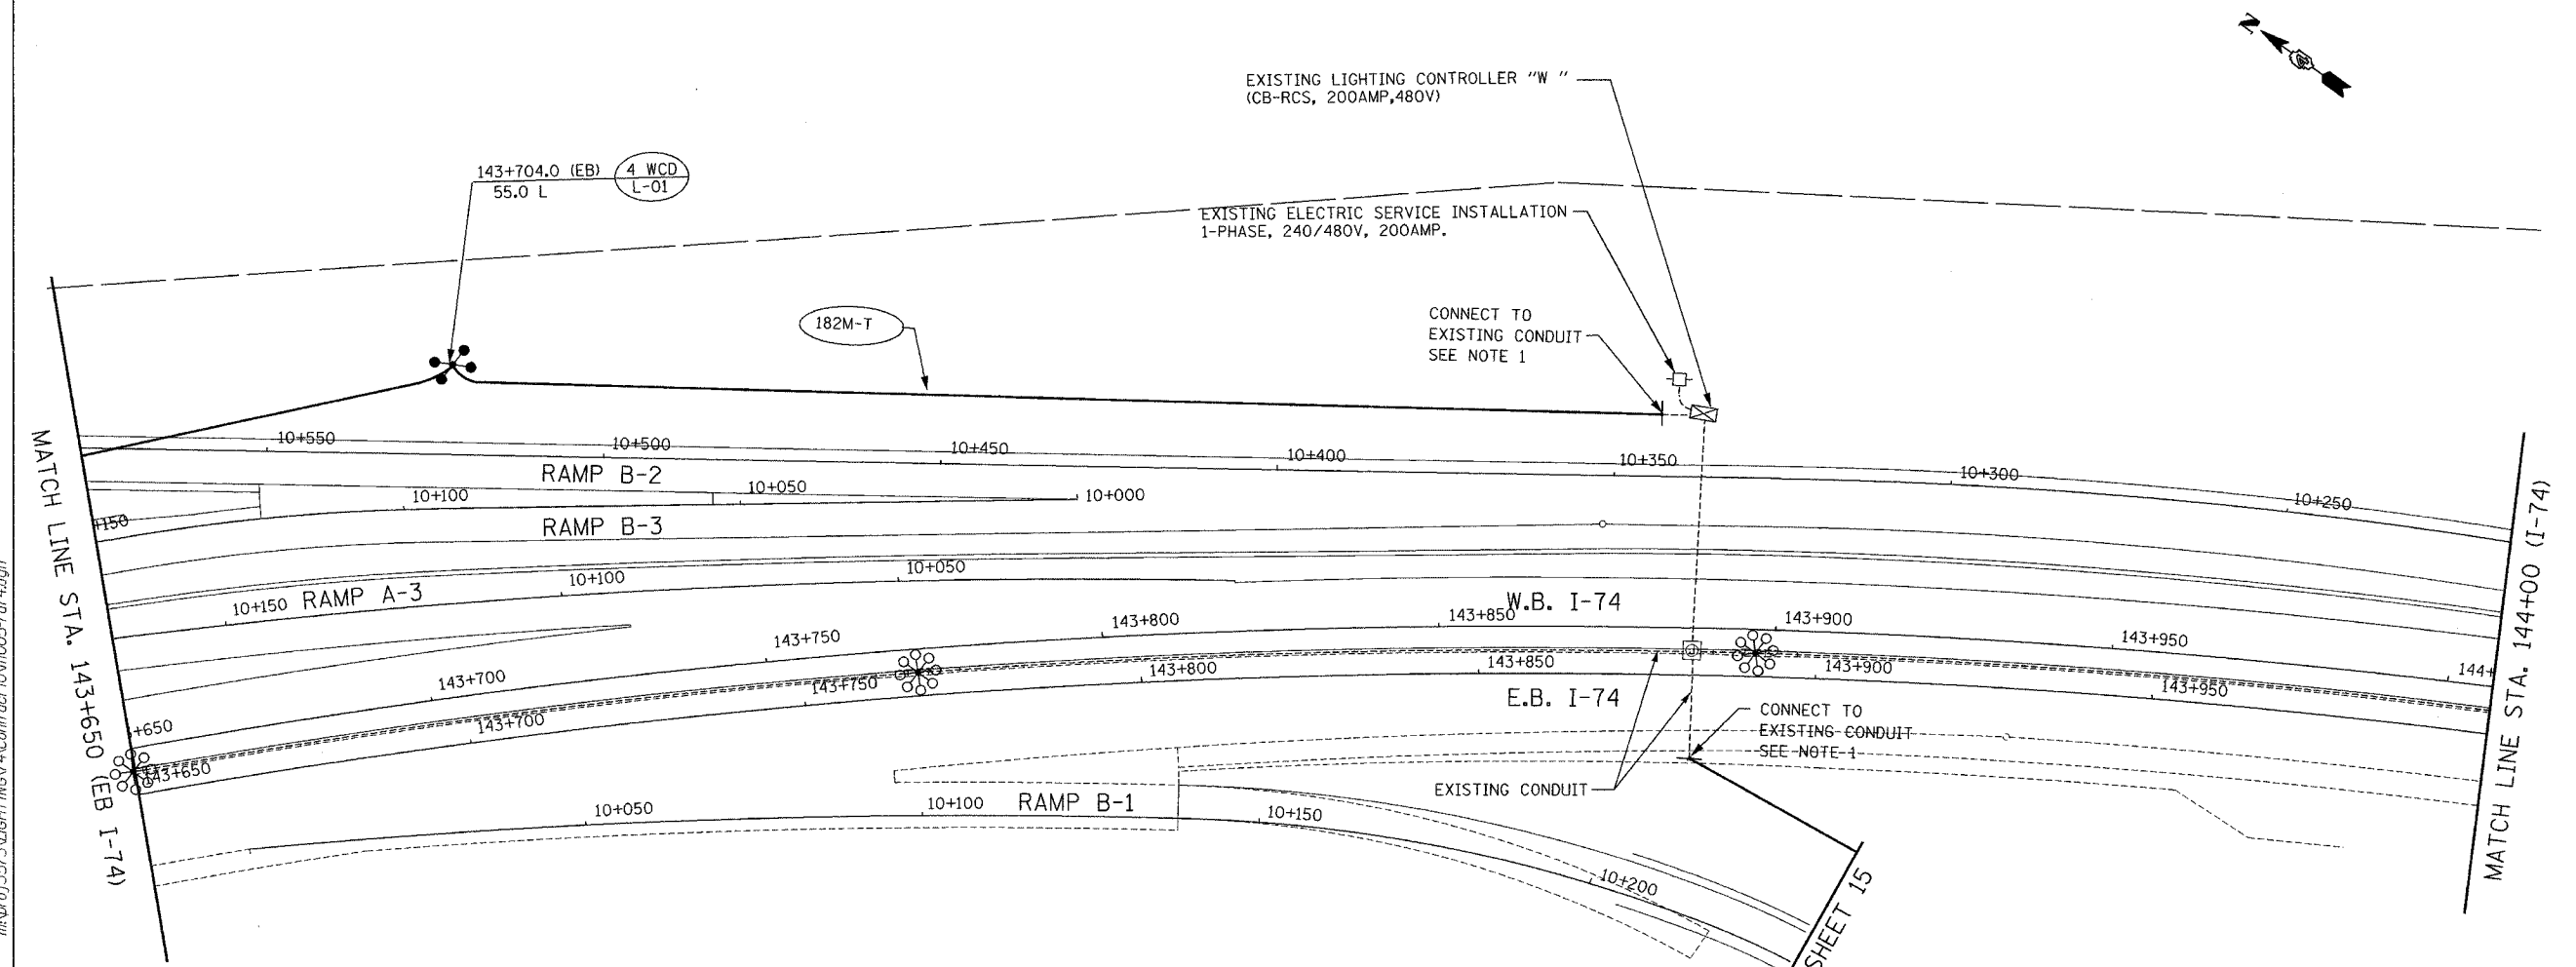

STREET LIGHTING - BILL OF MATERIAL THIS SHEET

PAY ITEM	UNIT	QUANTITY
CONDUIT IN TRENCH, 75MM DIA., PVC	METER	182.0
TRENCH AND BACKFILL FOR ELECTRICAL WORK	METER	182.0
LIGHT TOWER FOUNDATION	METER	5.5
HIGH MAST LUMINAIRE, (INSTALL ONLY)	EACH	4
LIGHT TOWER, INSTALL ONLY	EACH	1

 
LENGTH IN METERS

- ES: EMBEDDED IN STRUCTURE
- T: TRENCH
- P: PUSHED
- CT: COMMON TRENCH
- CTT: COMMON TRENCH WITH TRAFFIC SIGNAL CONDUIT (TRENCH AND BACKFILL BY TRAFFIC SIGNAL CONTRACTOR)

PROPOSED CONDUIT CALL-OUT

NOTE:
1. USE CONDUIT COUPLING TO CONNECT PROPOSED CONDUIT TO EXISTING CONDUIT. COST OF CONNECTION SHALL BE INCLUDED IN "CONDUIT IN TRENCH, 75mm DIA., PVC" PAY ITEM.

LIGHTING SHEET 12 OF 64



ab **alfred benesch & company**
CONSULTING ENGINEERS
205 NORTH MICHIGAN AVENUE, CHICAGO, ILLINOIS 60601

REVISIONS	
NAME	DATE

ILLINOIS DEPARTMENT OF TRANSPORTATION
PROPOSED LIGHTING PLAN
I-74
STA. 143+650 TO STA. 144+000
DRAWN BY DJK
CHECKED BY MKR
DATE: 11/12/04

m:\proj\3573\LIGHTING\74-Contract\0711005-7a74.dgn

10:48:20 AM

11/15/2004