
 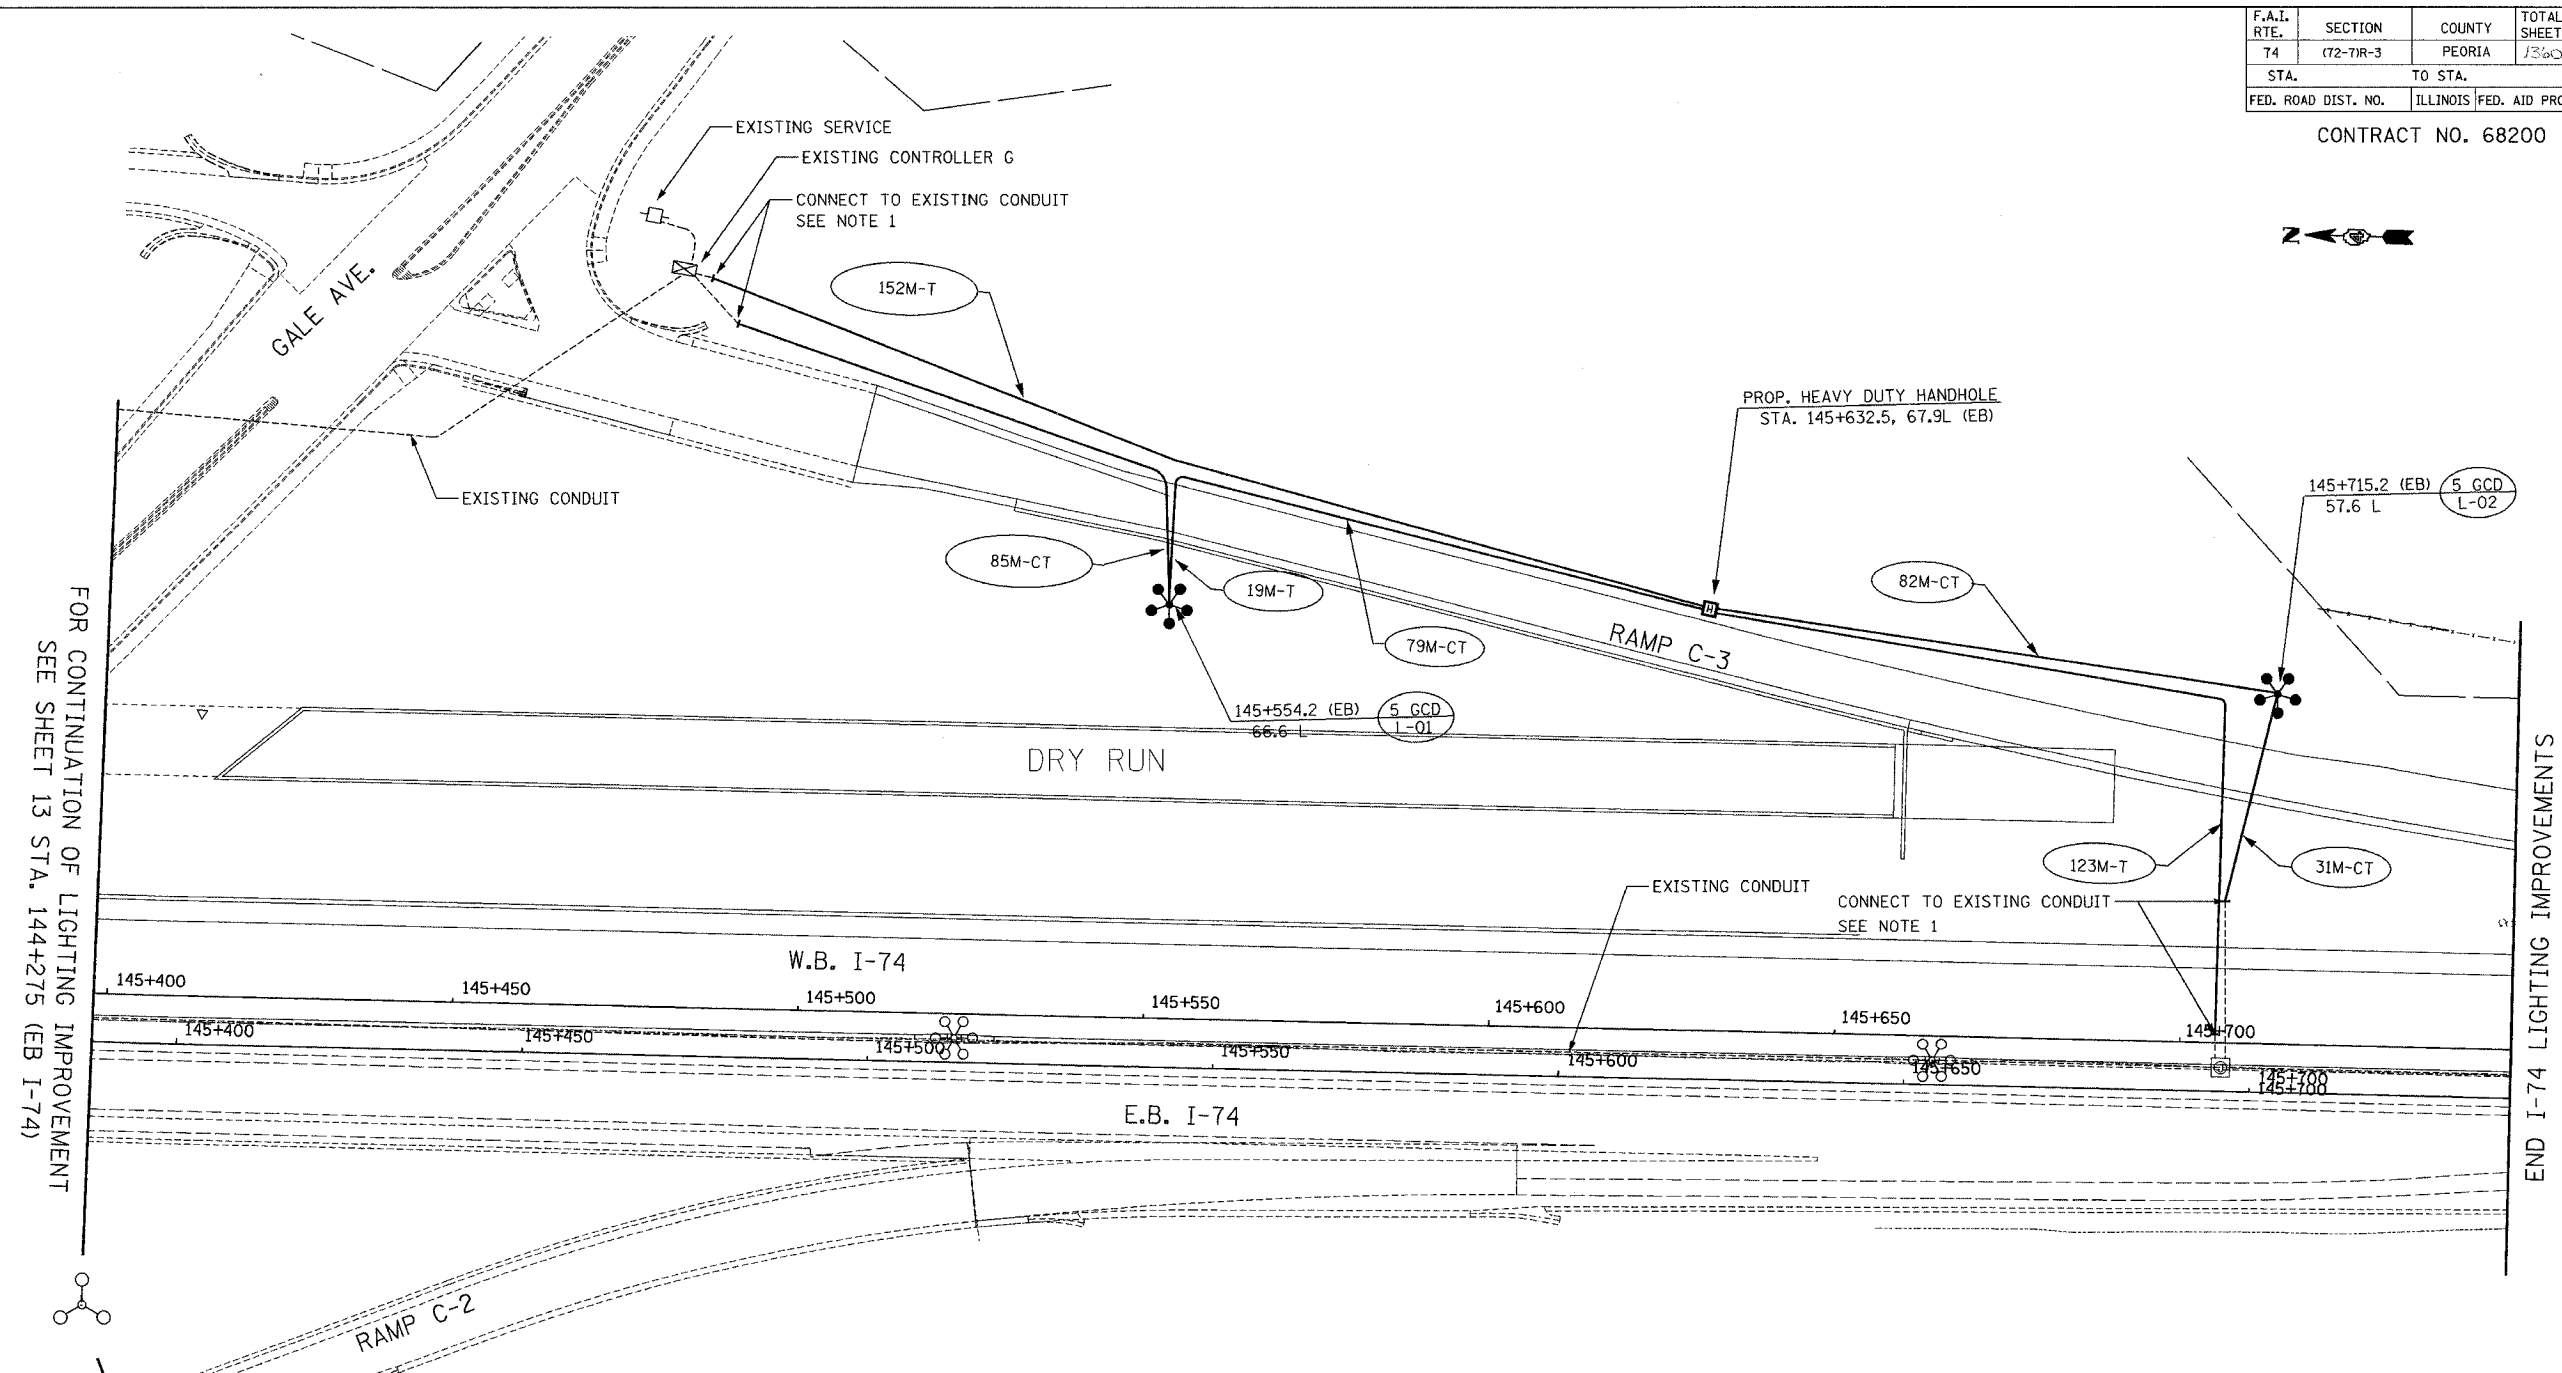


F.A.I. RTE.	SECTION	COUNTY	TOTAL SHEETS	SHEET NO.
74	(72-71R-3)	PEORIA	1360	1199
STA.		TO STA.		
FED. ROAD DIST. NO.		ILLINOIS FED. AID PROJECT		

CONTRACT NO. 68200



FOR CONTINUATION OF LIGHTING IMPROVEMENT SEE SHEET 13 STA. 144+275 (EB I-74)


END I-74 LIGHTING IMPROVEMENTS

11/15/2004 10:52:36 AM m:\proj\3573\LIGHTING\4-Contract\DWG\I0107a14.dgn

STREET LIGHTING - BILL OF MATERIAL THIS SHEET

PAY ITEM	UNIT	QUANTITY
CONCRETE HEAVY-DUTY HANDHOLE	EACH	1
CONDUIT IN TRENCH, 75MM DIA., PVC	METER	571.0
TRENCH AND BACKFILL FOR ELECTRICAL WORK	METER	294.0
LIGHT TOWER FOUNDATION	METER	12.0
HIGH MAST LUMINAIRE, (INSTALL ONLY)	EACH	10
LIGHT TOWER, INSTALL ONLY	EACH	2

 NOTE 1:
USE CONDUIT COUPLING TO CONNECT PROPOSED CONDUIT TO EXISTING CONDUIT. COST OF CONNECTION SHALL BE INCLUDED IN "CONDUIT IN TRENCH, 75mm, DIA., PVC " PAY ITEM.



ab **alfred benesch & company**
CONSULTING ENGINEERS
205 NORTH MICHIGAN AVENUE, CHICAGO, ILLINOIS 60601

REVISIONS	
NAME	DATE

ILLINOIS DEPARTMENT OF TRANSPORTATION
PROPOSED LIGHTING PLAN
I-74
STA. 145+400 TO STA. 145+750
DRAWN BY DJK
CHECKED BY MKR
DATE: 11/12/04

LIGHTING SHEET 14 OF 64