


 
F.A.I. RTE.	SECTION	COUNTY	TOTAL SHEETS	SHEET NO.
74	(72-7R-3)	PEORIA	136	1001
STA.	TO STA.			
FED. ROAD DIST. NO.	ILLINOIS	FED. AID PROJECT		

CONTRACT NO. 68200

STREET LIGHTING - BILL OF MATERIAL THIS SHEET


PAY ITEM	UNIT	QUANTITY
ELECTRIC SERVICE INSTALLATION	EACH	2
LUMINAIRE, SODIUM VAPOR, HORIZONTAL MOUNT, 400 WATT	EACH	1
LIGHTING CONTROLLER TYPE CB-RCS 200AMP-480VOLT	EACH	1

- NOTE:
- FOR RAMPS B-3 & B-5 OVER WAR MEMORIAL DRIVE UNDERPASS LIGHTING, SEE SHEET 26.
 - PROPOSED RCOC LIGHTING CONTROLLER SHALL BE FURNISHED BY THE CITY OF PEORIA. SEE SHEET 41 FOR LIGHTING CONTROLLER WIRING DIAGRAM.

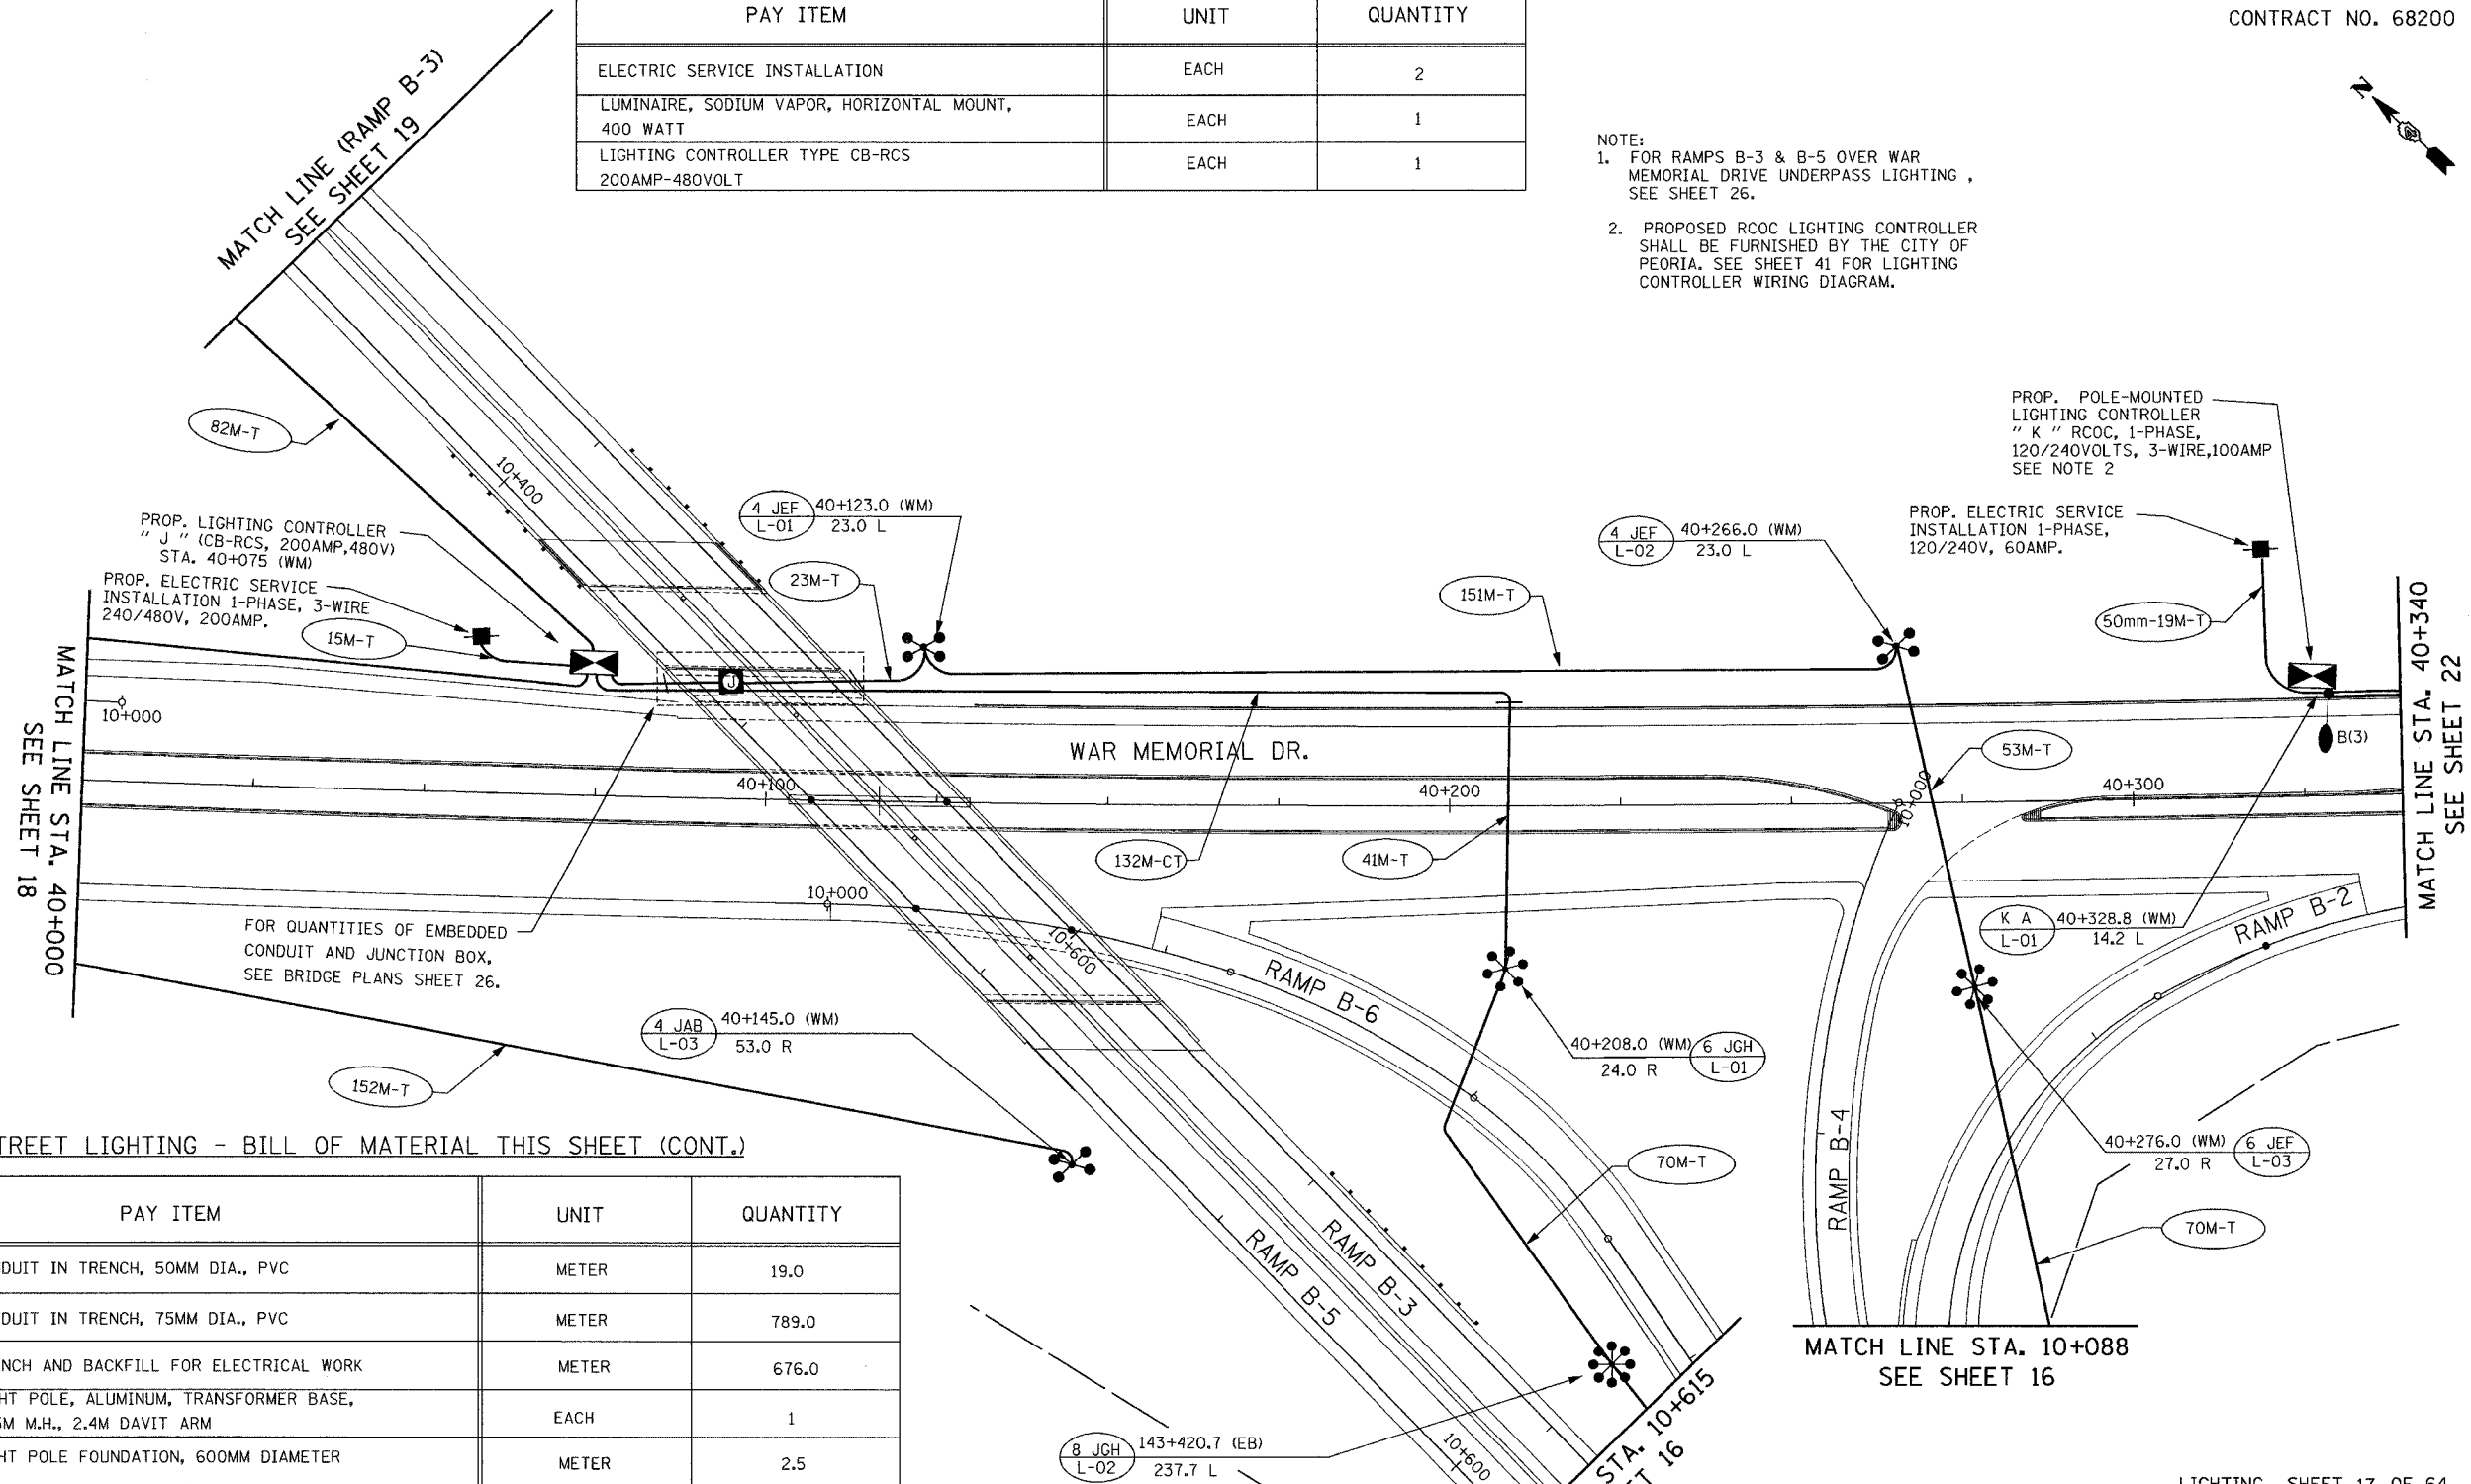

STREET LIGHTING - BILL OF MATERIAL THIS SHEET (CONT.)

PAY ITEM	UNIT	QUANTITY
CONDUIT IN TRENCH, 50MM DIA., PVC	METER	19.0
CONDUIT IN TRENCH, 75MM DIA., PVC	METER	789.0
TRENCH AND BACKFILL FOR ELECTRICAL WORK	METER	676.0
LIGHT POLE, ALUMINUM, TRANSFORMER BASE, 13.5M M.H., 2.4M DAVIT ARM	EACH	1
LIGHT POLE FOUNDATION, 600MM DIAMETER	METER	2.5
LIGHT TOWER FOUNDATION	METER	35.2
HIGH MAST LUMINAIRE, (INSTALL ONLY)	EACH	32
LIGHT TOWER, INSTALL ONLY	EACH	6
INSTALL CONTROLLER	EACH	1

 

ab **alfred benesch & company**
CONSULTING ENGINEERS
205 NORTH MICHIGAN AVENUE, CHICAGO, ILLINOIS 60601

REVISIONS	
NAME	DATE

LIGHTING SHEET 17 OF 64

ILLINOIS DEPARTMENT OF TRANSPORTATION

PROPOSED LIGHTING PLAN
WAR MEMORIAL DR.
STA. 40+000 TO STA. 40+340

DATE: 11/12/04

DRAWN BY DJK
CHECKED BY MKR

11/15/2004 10:45:32 AM m:\proj\35273\LIGHTING\74-Contract ID\11004-7\awm.dgn