


F.A.I. RTE.	SECTION	COUNTY	TOTAL SHEETS	SHEET NO.
74		TAZEWELL	1366	272
STA. 2+300.000		TO STA. 2+450.000		
FED. ROAD DIST. NO. 4 ILLINOIS FED. AID PROJECT				
* (90-1)R-2;90(13,14,14-1)R-1				

DRAINAGE LEGEND

- | EXISTING | PROPOSED | |
|----------|----------|-------------------------|
| ○ | ● | CATCH BASIN |
| ○ | ○ | INLET |
| ○ | ○ | MANHOLE |
| △ | ▲ | CONC END SECTION |
| ✱ | ✱ | SAC |
| ↔ | ↔ | SUMMIT |
| → | → | DITCH |
| → | → | SWALE |
| → | → | SANITARY SEWER |
| → | → | STORM SEWER |
| → | → | CULVERT PIPE |
| → | → | TRENCH DRAIN |
| △ | | STRUCTURE NUMBER |
| ○ | | STORM SEWER PIPE NUMBER |

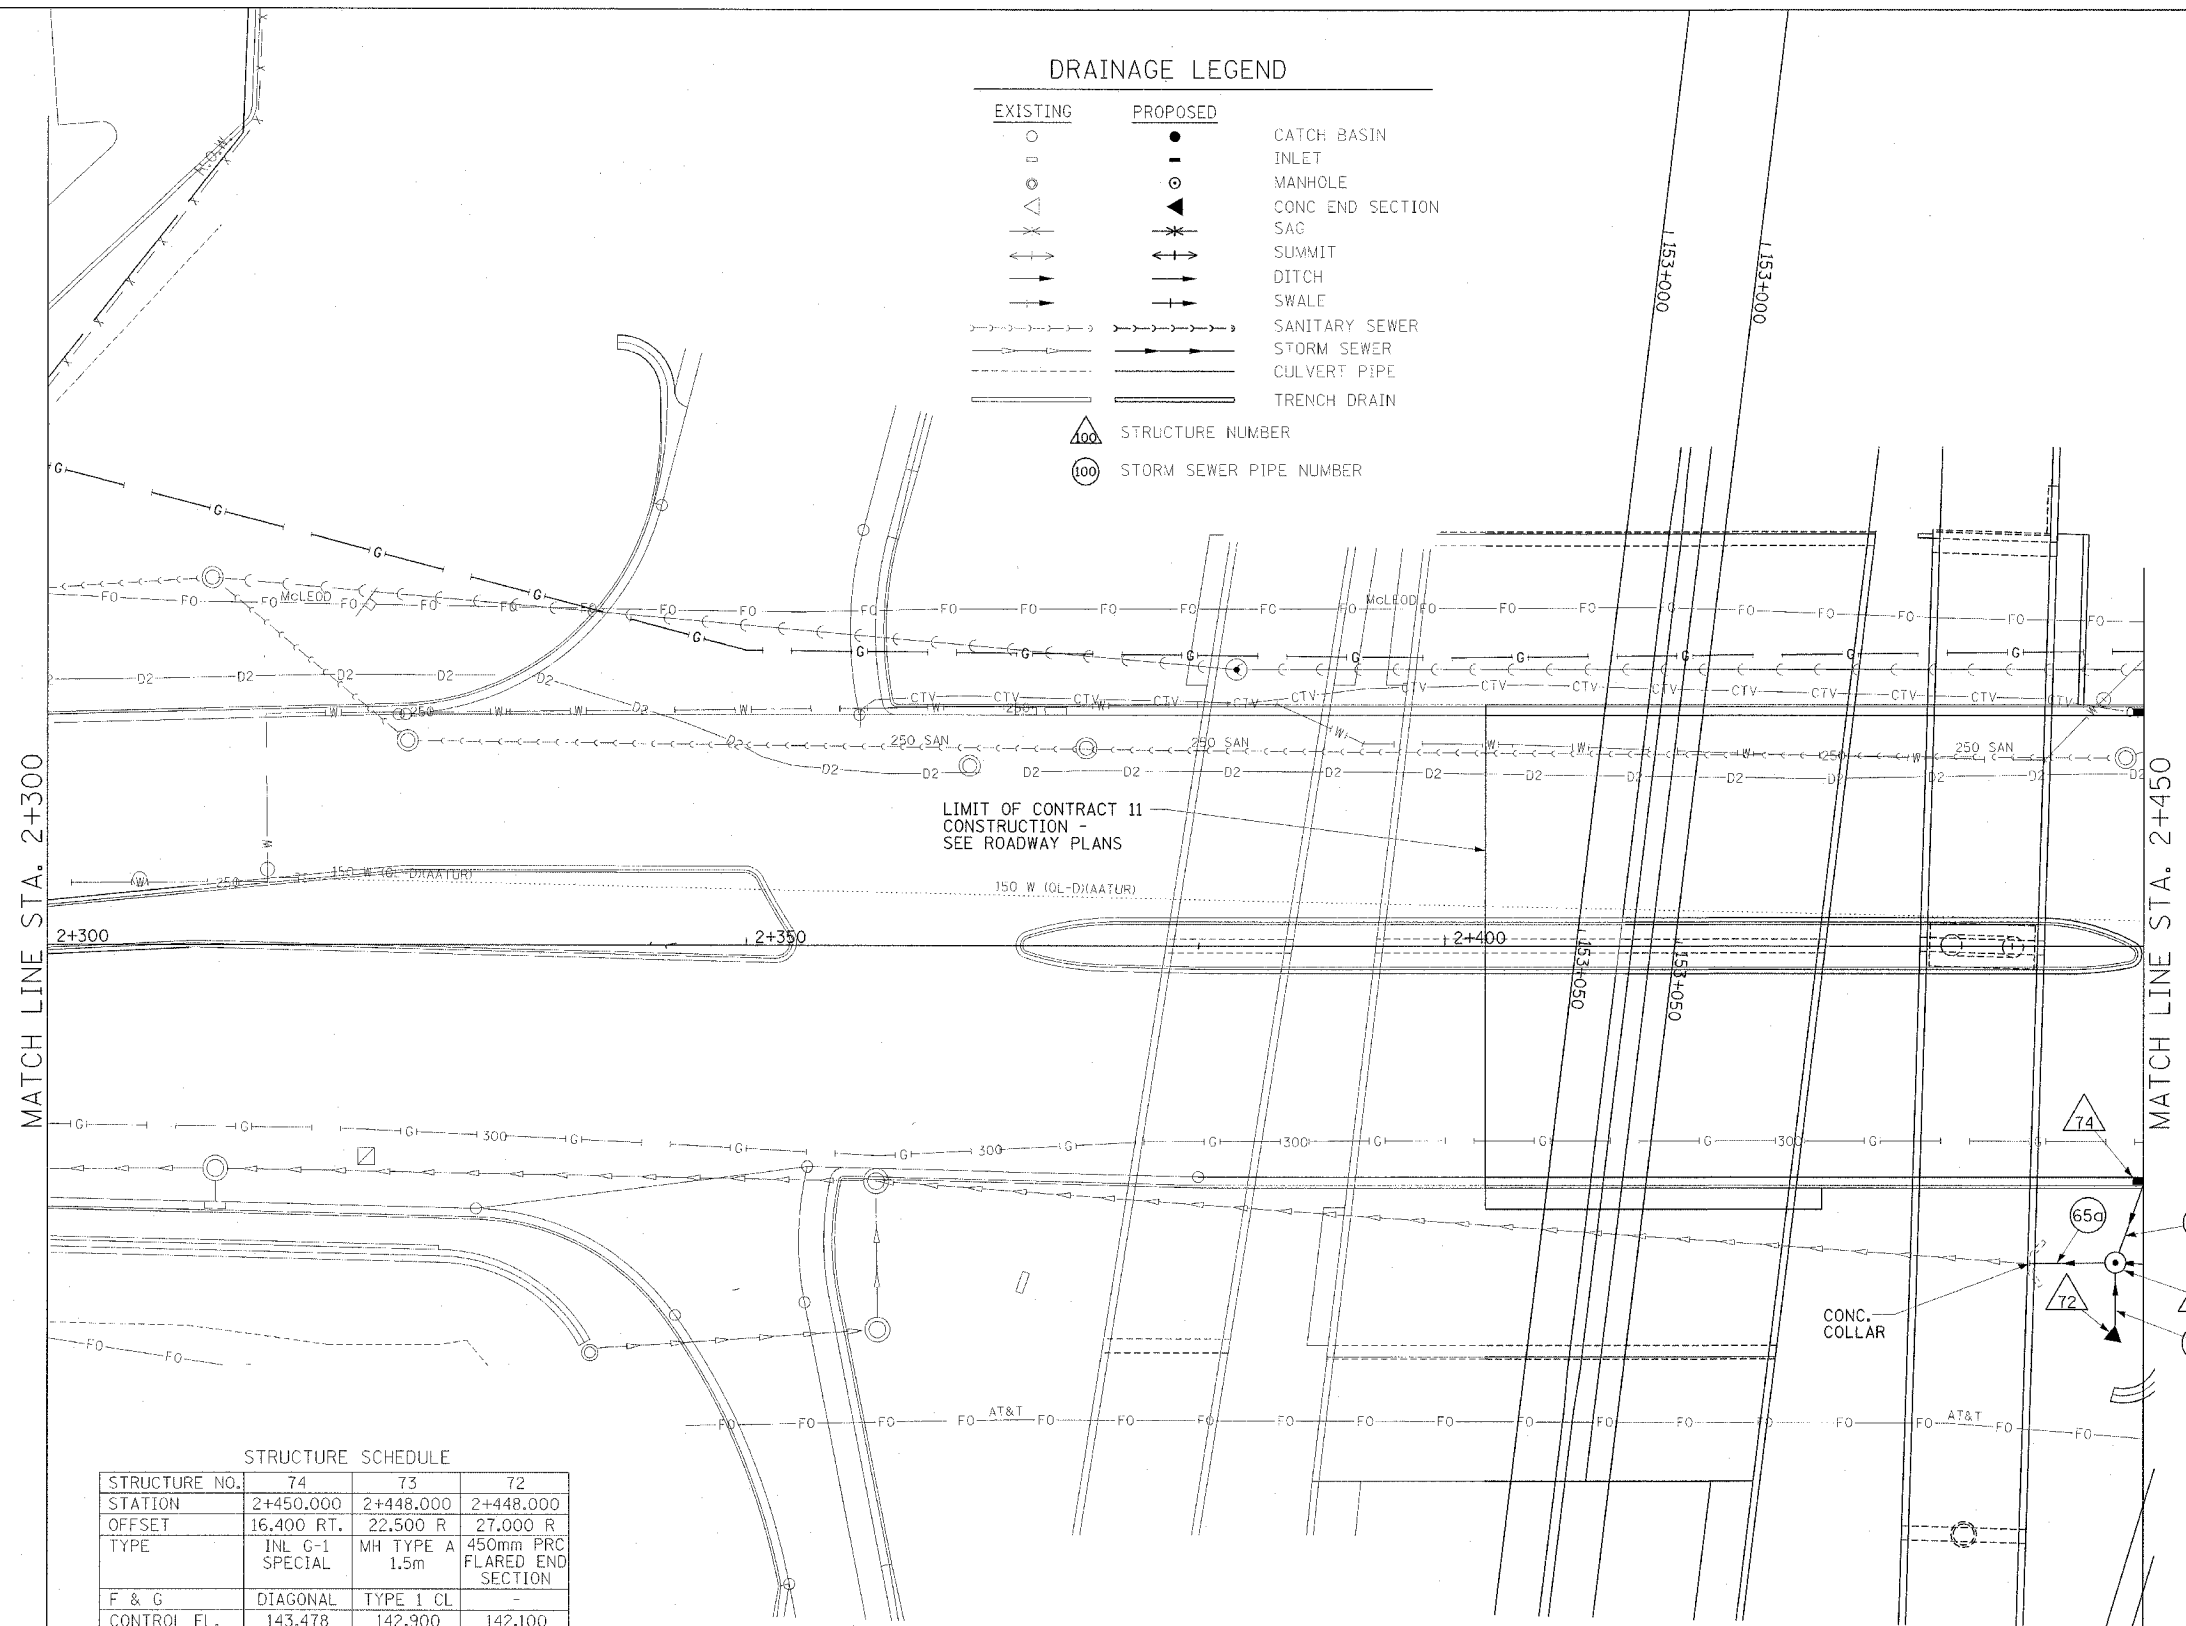


STRUCTURE SCHEDULE

STRUCTURE NO.	74	73	72
STATION	2+450.000	2+448.000	2+448.000
OFFSET	16,400 RT.	22,500 R	27,000 R
TYPE	INL G-1 SPECIAL	MH TYPE A 1.5m	450mm PRC FLARED END SECTION
F & G	DIAGONAL	TYPE 1 CL	-
CONTROL EL.	143.478	142.900	142.100
INV NW.	-	142.200	-
INV SE.	142.580	142.050	-
INV NE.	-	141.750	-
INV SW.	-	141.750	-
INV N.	-	-	-
INV S.	-	-	-
INV E.	-	-	-
INV W.	-	-	-
REMARKS	-	-	-

PIPE SCHEDULE

PIPE NO.	63	65a	73a
U/S-D/S	74 - 73	73 - EXISTING	72 - 73
LENGTH (m)	5.7	7.0	4.0
SIZE (mm)	300	750	450
CLASS/TYPE	A/1	A/1	A/1
T.B. (cu m)	0.3	0.0	0.0
REMARKS	-	CONC. COLLAR	-

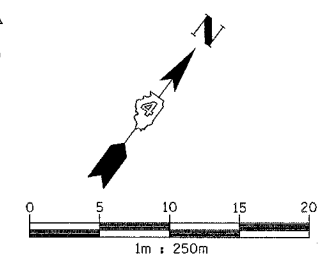

REVISIONS

NAME	DATE



PROPOSED IMPROVEMENT
 ILLINOIS DEPARTMENT OF TRANSPORTATION
DRAINAGE AND UTILITY PLAN
MAIN STREET
 STA 2+300 TO 2+450
 DATE 12/20/04
 DRAWN BY JAM
 CHECKED BY MJS